


LINESET SCHEDULE	
XX	DEADHUNG BOUNCE
38	8TH LX
37	BLACK OUT CURTAIN
36	
35	
34	
33	
32	
31	
30	7TH LX
29	SNOW BAG
28	
27	
26	6TH LX
25	
24	
23	
22	
21	
20	2ND LEGS
19	2ND BORDER
18	
17	
16	
15	
14	
13	1ST LEGS
12	1ST BORDER
11	
10	CHANDELIER
9	
8	
7	
6	2ND LX
5	
4	1ST LX
3	
2	RED CURTAIN
1	RED VALANCE

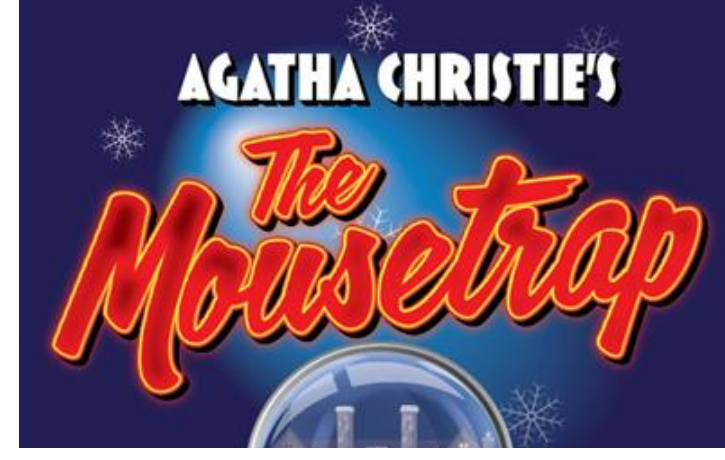

BRYCE CUTLER
SCENIC & MEDIA DESIGN
BRYCE.C.CUTLER@GMAIL.COM
561.389.3266
WWW.BRYCECUTLER.COM

BERKSHIRE THEATER GROUP PRESENTS...

THE MOUSETRAP

BY AGATHA CHRISTIE
DIRECTED BY GERRY MCINTYRE

PRODUCTION TEAM

- ARTISTIC DIRECTOR
KATE MAGUIRE
- DIRECTOR OF PRODUCTION
PETER DURGIN
- SCENIC & MEDIA DESIGNER
BRYCE CUTLER
- SCENIC ASSISTANT
JONAS HARRISON
- PROJECTIONS ASSISTANT
-
- LIGHTING DESIGNER
SAM RUSHEN
- COSTUME DESIGNER
DUSTIN CROSS
- SOUND DESIGNER
-
- PRODUCTION MANAGER
-
- TECHNICAL DIRECTOR
SETH CAVENAUGH
- PROPS COORDINATOR
RANDY PARSONS

The designer is responsible for the visual aspects of the production only, and the specification of the designer's designs relate solely to the appearance of the design and not to matters of safety. The designer agrees to make prompt correcting alterations to any specifications found to be incompatible with proper safety precautions.

THE COLONIAL THEATRE
11 South St., Pittsfield MA 01201

DATE: 05-04-2025



SCALE: 3/8" = 1'-0"

REVISION NO: -

DRAWN BY: JH

3/8" GROUNDPLAN

PLATE NO.

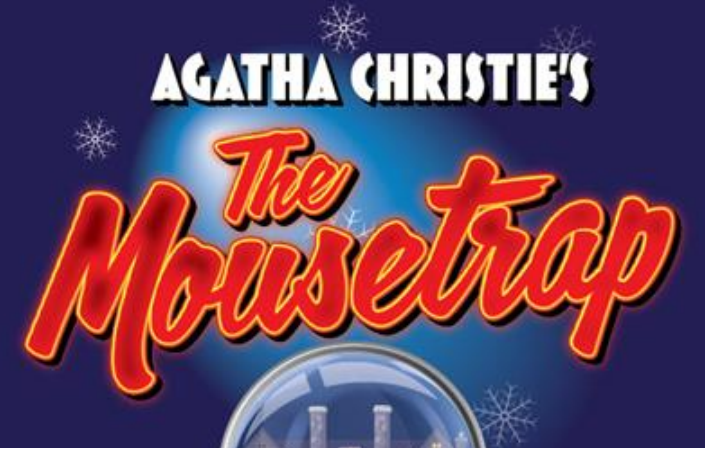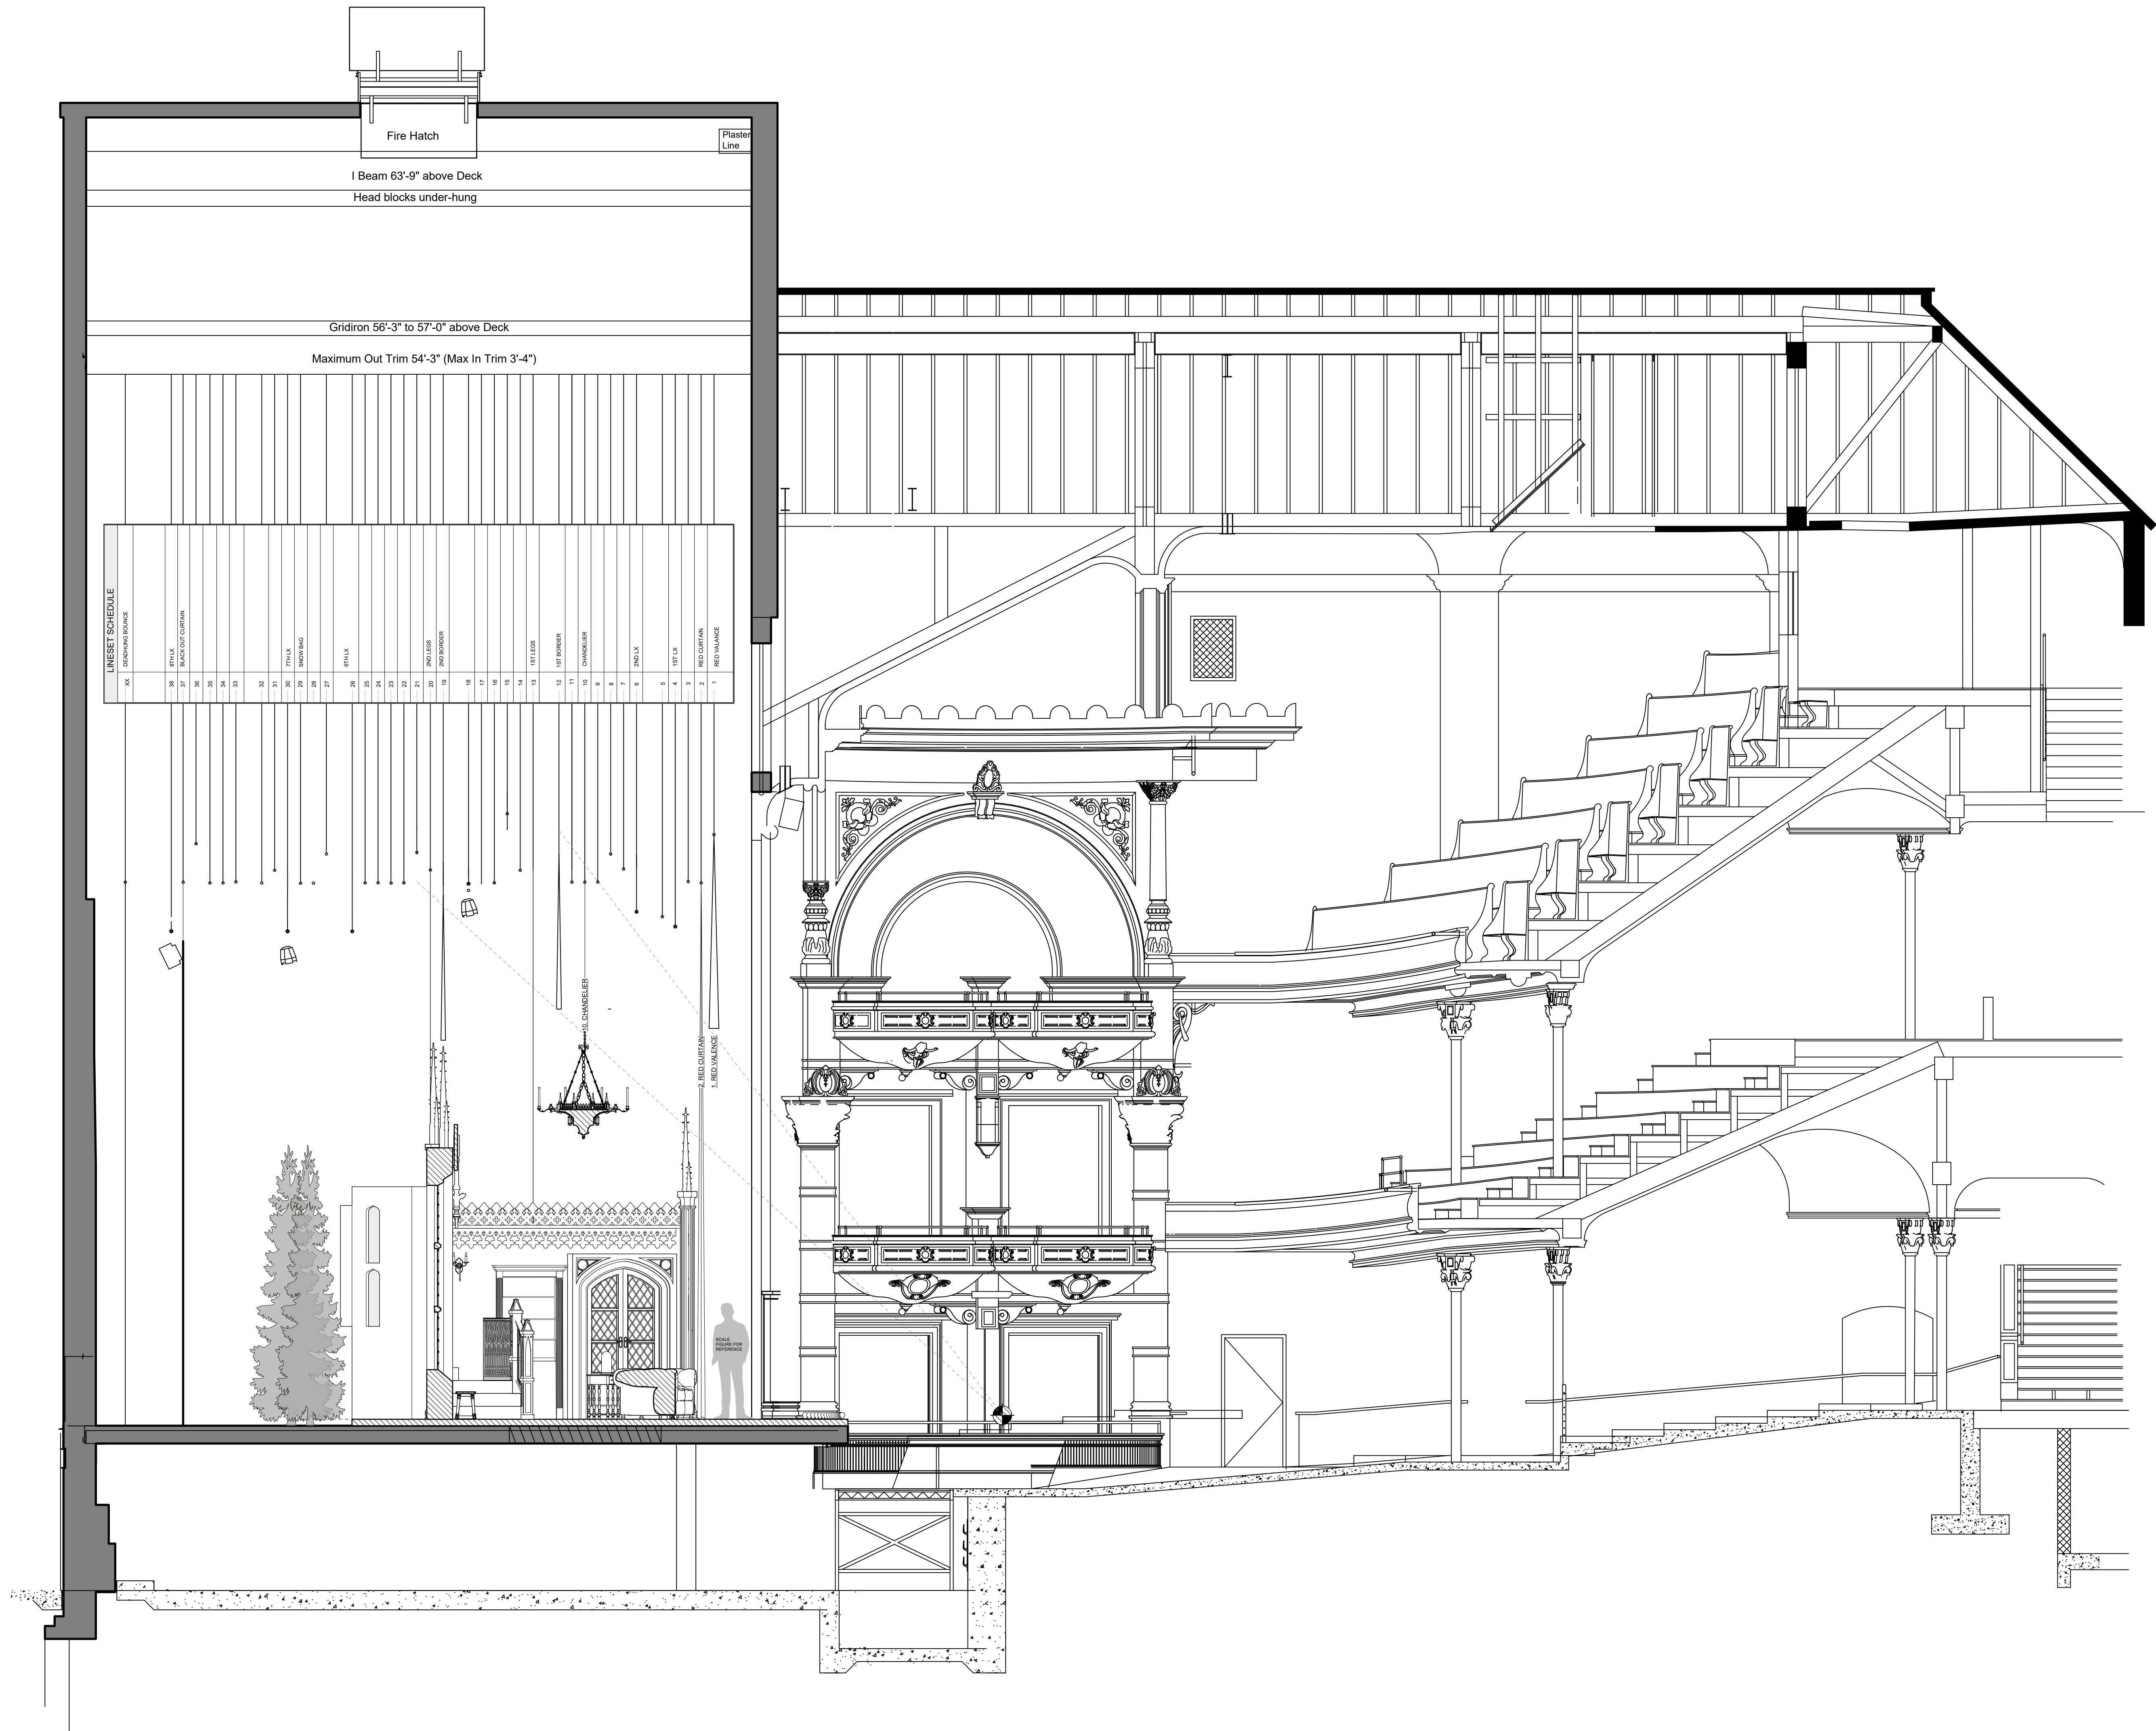

BRYCE CUTLER
SCENIC & MEDIA DESIGN
BRYCE.C.CUTLER@GMAIL.COM
561.389.3266
WWW.BRYCECUTLER.COM

BERKSHIRE THEATER GROUP PRESENTS...

THE MOUSETRAP

BY AGATHA CHRISTIE
DIRECTED BY
GERRY MCINTYRE

PRODUCTION TEAM

ARTISTIC DIRECTOR
KATE MAGUIRE
DIRECTOR OF PRODUCTION
PETER DURGIN
SCENIC & MEDIA DESIGNER
BRYCE CUTLER
SCENIC ASSISTANT
JONAS HARRISON
PROJECTIONS ASSISTANT
-
LIGHTING DESIGNER
SAM RUSHEN
COSTUME DESIGNER
DUSTIN CROSS
SOUND DESIGNER
-
PRODUCTION MANAGER
-
TECHNICAL DIRECTOR
SETH CAVENAUGH
PROPS COORDINATOR
RANDY PARSONS

The designer is responsible for the visual aspects of the production only, and the specification of the designer's designs relate solely to the appearance of the design and not to matters of safety. The designer agrees to make prompt correcting alterations to any specifications found to be incompatible with proper safety precautions.

THE COLONIAL THEATRE

11 South St., Pittsfield MA 01201

DATE: 05-04-2025

SCALE: 1/4" = 1'-0"

REVISION NO: -

DRAWN BY: JH

1/4" SECTION


PLATE NO.

2


OF 8

TRIM PURCHASE LINK:
<https://www.homedepot.com/p/Alexandria-Moulding-1-1-4-in-D-x-2-3-4-in-W-x-96-in-L-MDF-Primed-White-Crown-Moulding-Pack-4-Pack-CR001-9-6096PK/331519238>

BUILD x2 [A, N]

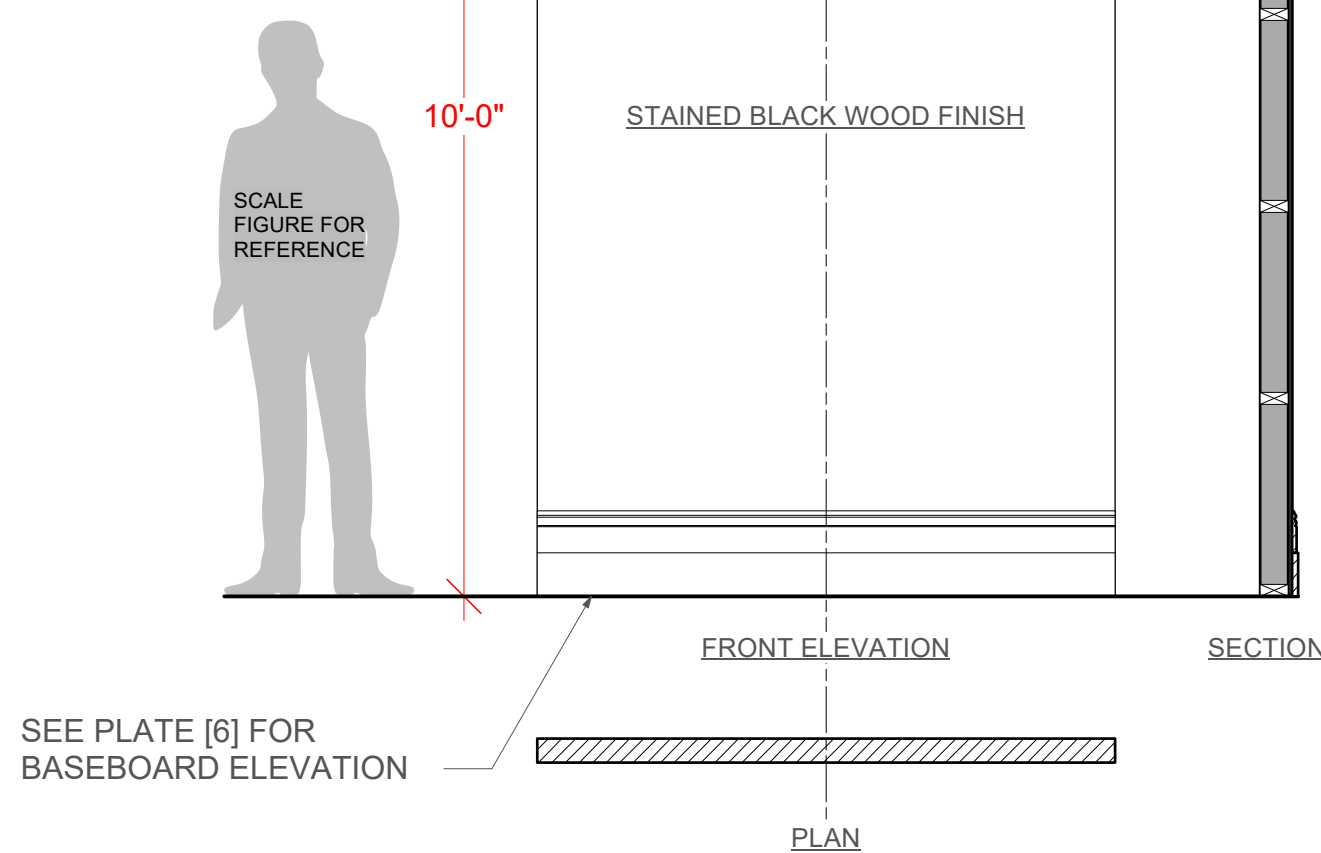

1 WALL A, N ELEVATION
Scale: 1/2" = 1'-0"

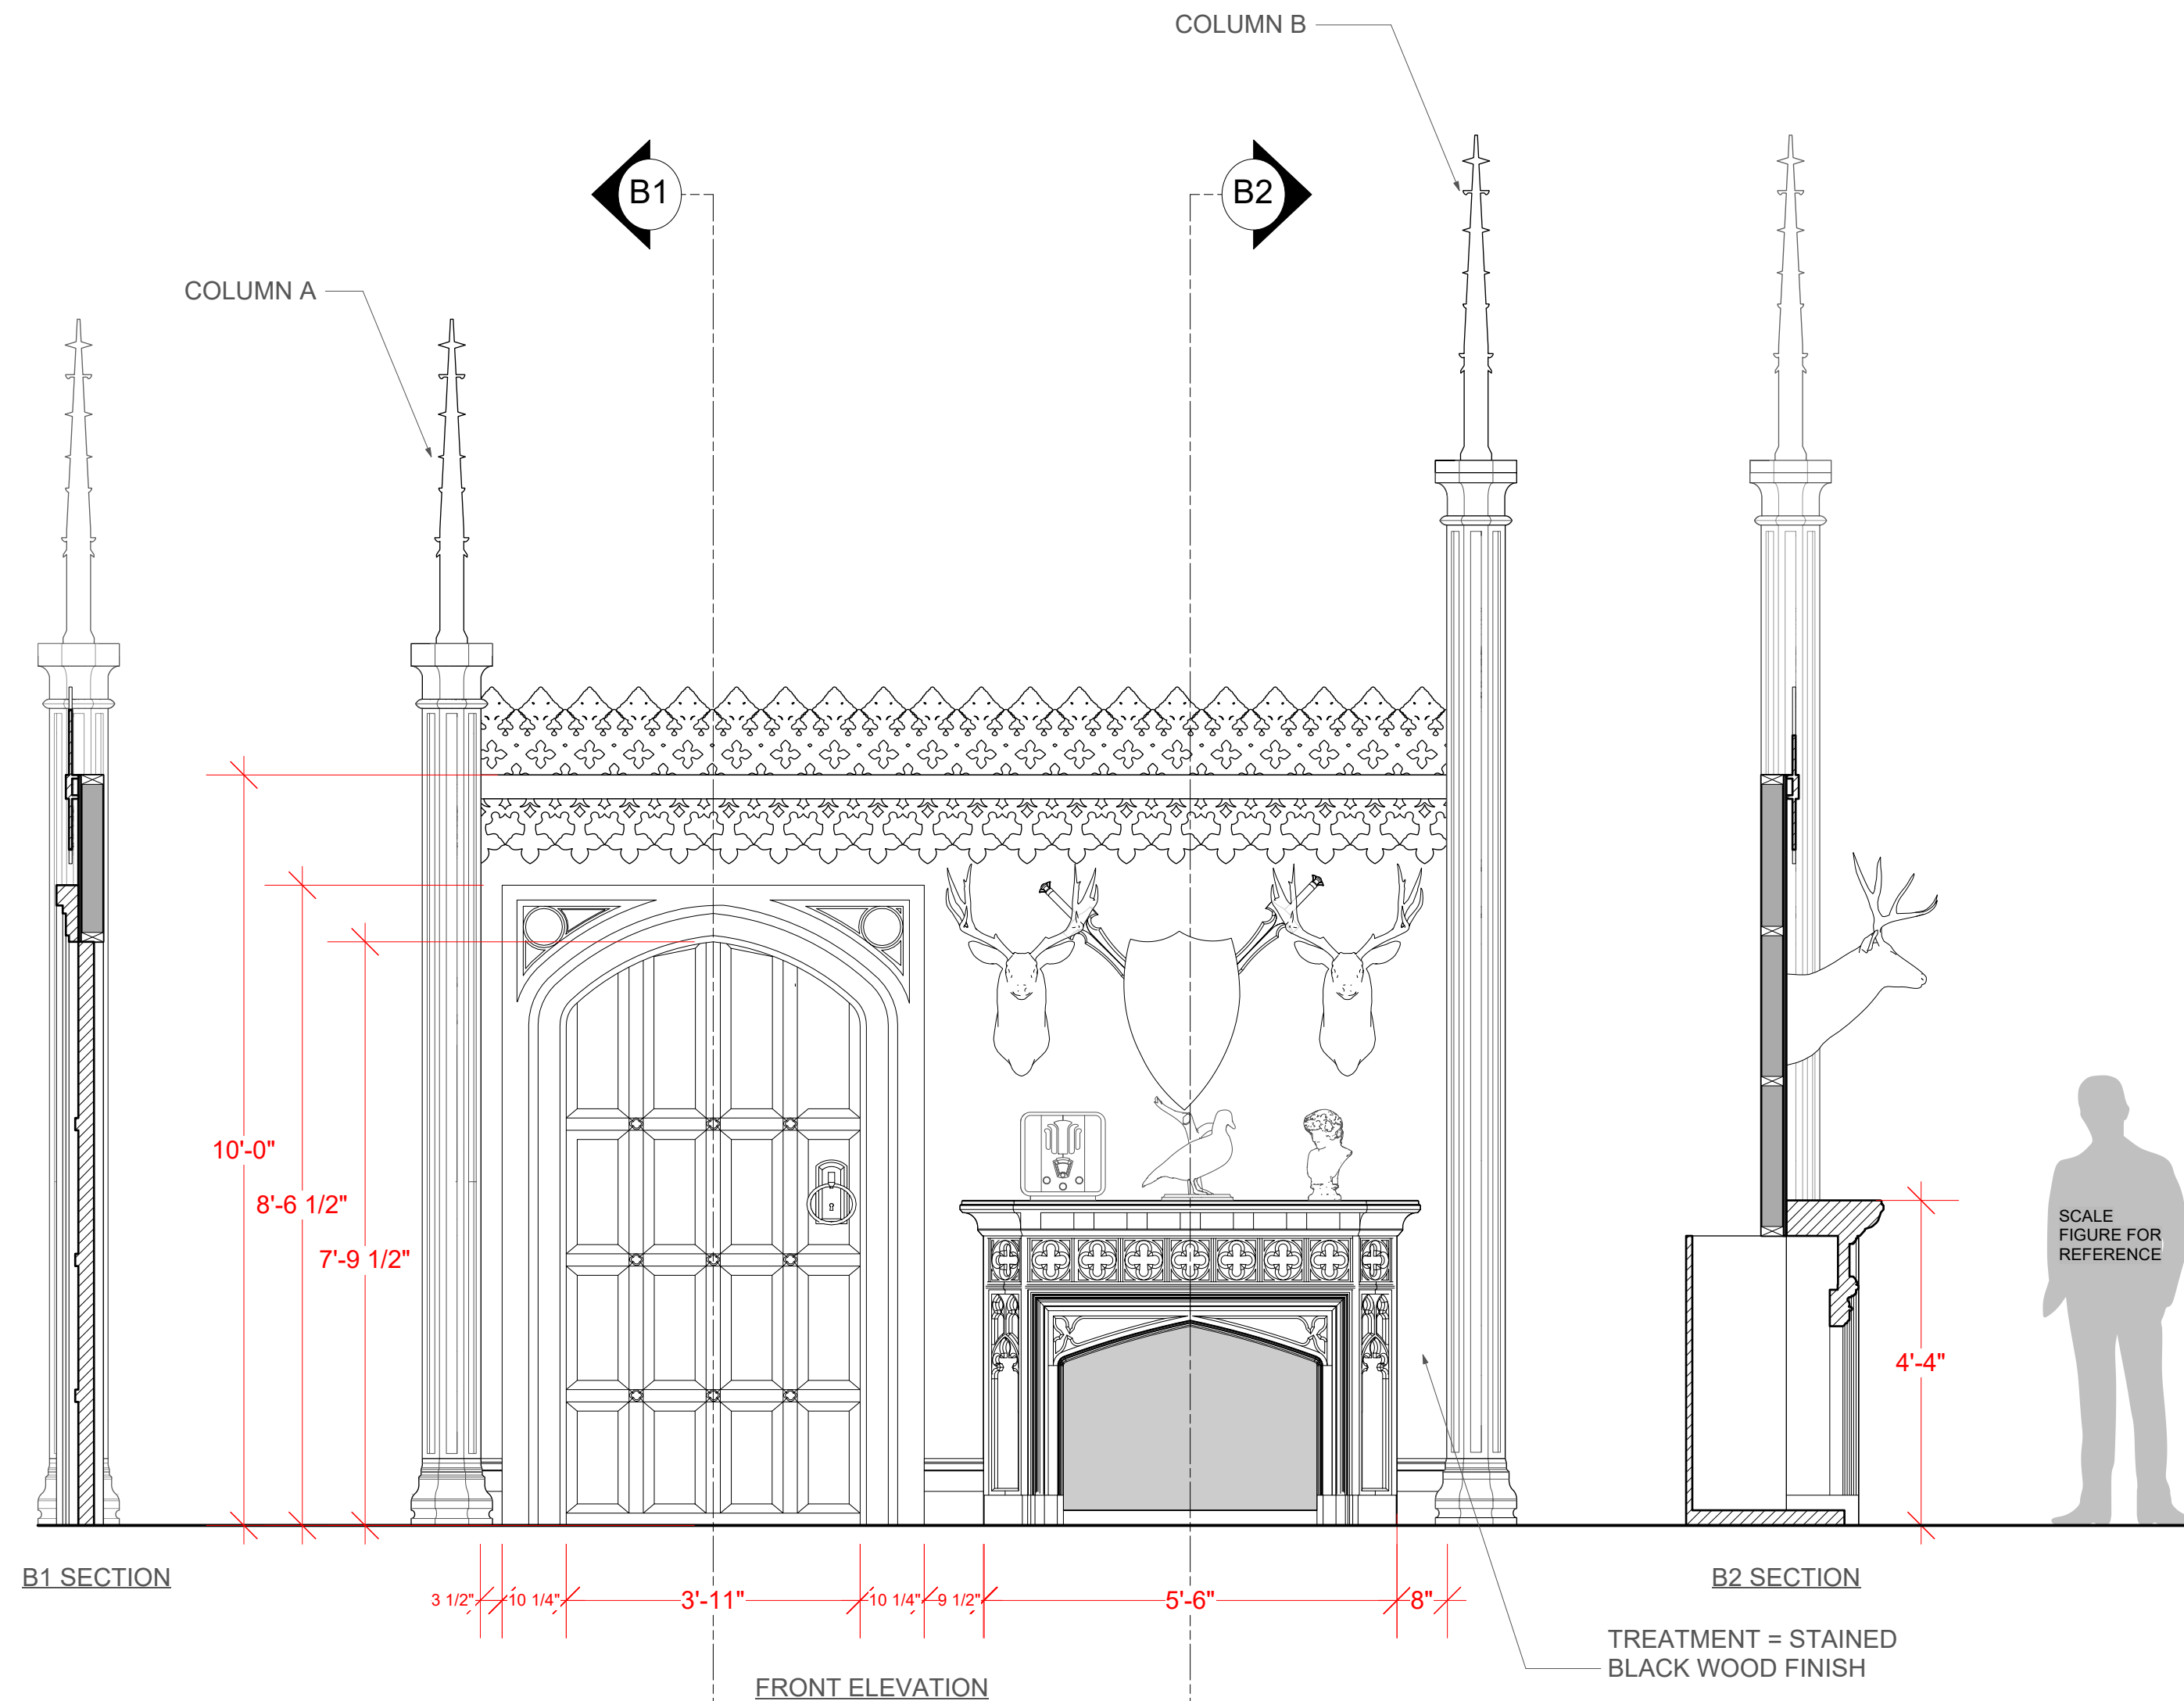


FRONT ELEVATION


PLAN

2 WALL B ELEVATION
Scale: 1/2" = 1'-0"

BUILD x5 [C, D, H, L, M]

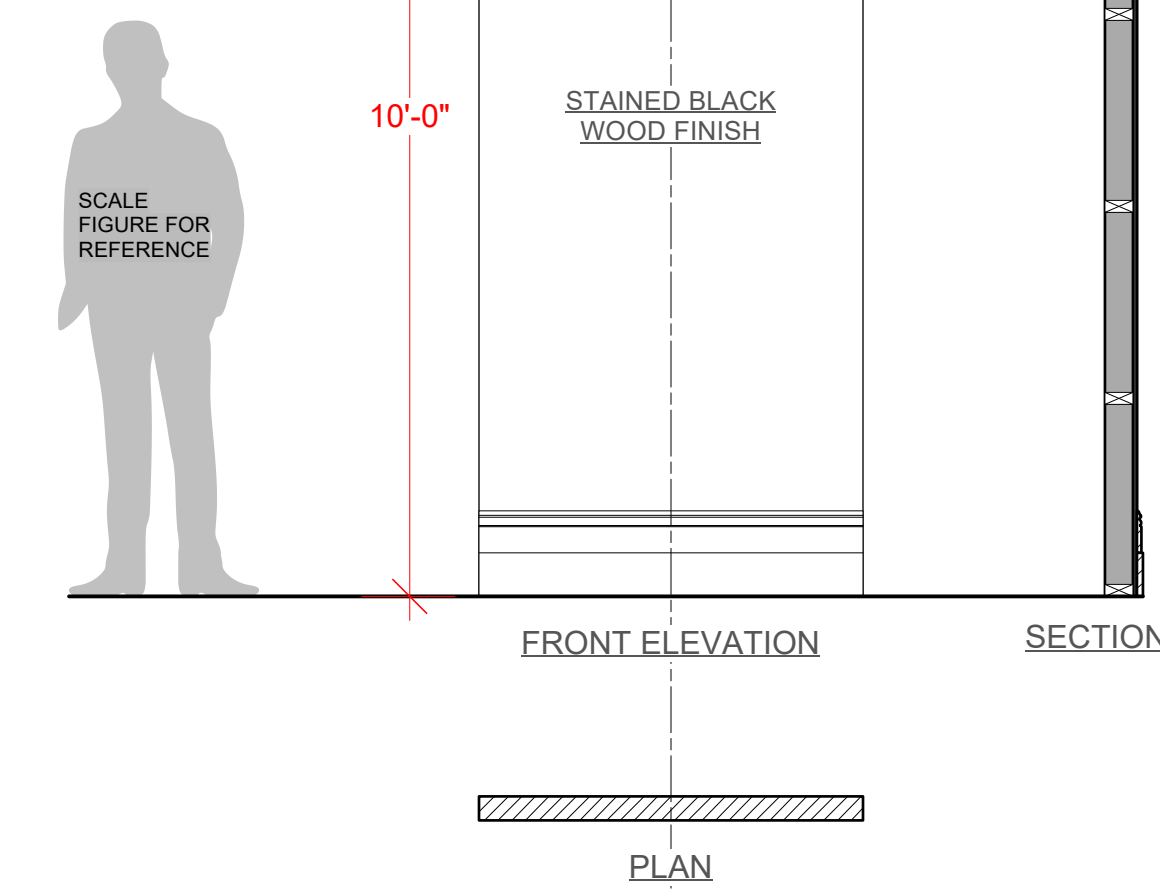

3 WALL C, D, H, L, M ELEVATION
Scale: 1/2" = 1'-0"

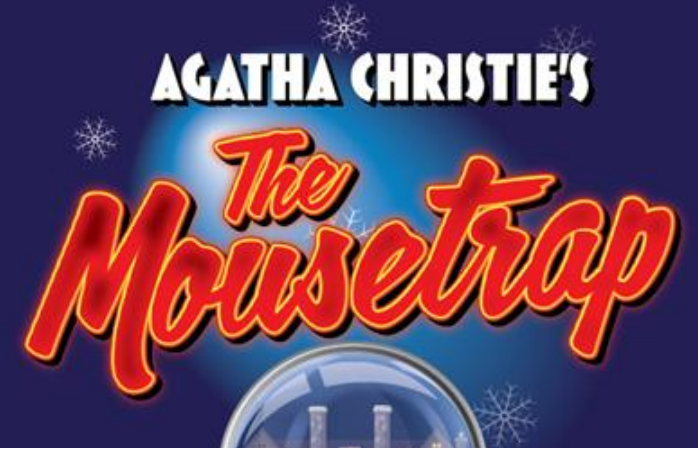

BRYCE CUTLER
SCENIC & MEDIA DESIGN
BRYCE.C.CUTLER@GMAIL.COM
561.389.3266
WWW.BRYCECUTLER.COM

BERKSHIRE THEATER GROUP PRESENTS...

THE MOUSETRAP

BY AGATHA CHRISTIE
DIRECTED BY GERRY MCINTYRE

PRODUCTION TEAM

ARTISTIC DIRECTOR
KATE MAGUIRE
DIRECTOR OF PRODUCTION
PETER DURGIN
SCENIC & MEDIA DESIGNER
BRYCE CUTLER
SCENIC ASSISTANT
JONAS HARRISON
PROJECTIONS ASSISTANT
-
LIGHTING DESIGNER
SAM RUSHEN
COSTUME DESIGNER
DUSTIN CROSS
SOUND DESIGNER
-
PRODUCTION MANAGER
-
TECHNICAL DIRECTOR
SETH CAVENAUGH
PROPS COORDINATOR
RANDY PARSONS

The designer is responsible for the visual aspects of the production only, and the specification of the designer's designs relate solely to the appearance of the design and not to matters of safety. The designer agrees to make prompt correcting alterations to any specifications found to be incompatible with proper safety precautions.

THE COLONIAL THEATRE

11 South St., Pittsfield MA 01201

DATE: 05-04-2025

SCALE: 1/2" = 1'-0"


REVISION NO: -

DRAWN BY: JH

WALL ELEVATIONS 1

PLATE NO.

3

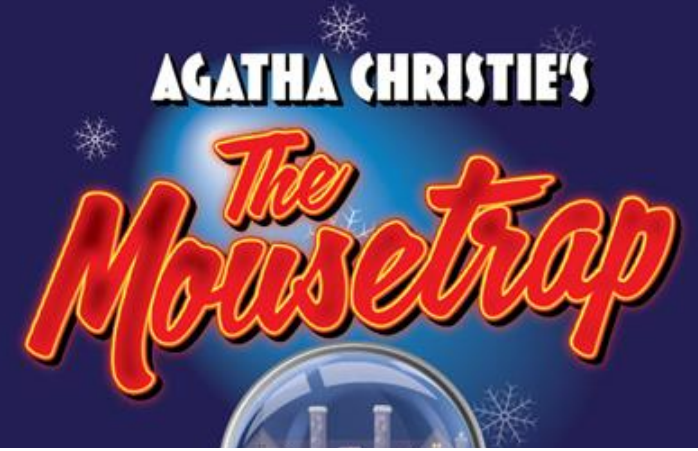

BRYCE CUTLER
SCENIC & MEDIA DESIGN
BRYCE.C.CUTLER@GMAIL.COM
561.389.3266
WWW.BRYCECUTLER.COM

BERKSHIRE THEATER GROUP PRESENTS...

THE MOUSETRAP

BY AGATHA CHRISTIE
DIRECTED BY
GERRY MCINTYRE

PRODUCTION TEAM

ARTISTIC DIRECTOR
KATE MAGUIRE
DIRECTOR OF PRODUCTION
PETER DURGIN
SCENIC & MEDIA DESIGNER
BRYCE CUTLER
SCENIC ASSISTANT
JONAS HARRISON
PROJECTIONS ASSISTANT
-
LIGHTING DESIGNER
SAM RUSHEN
COSTUME DESIGNER
DUSTIN CROSS
SOUND DESIGNER
-
PRODUCTION MANAGER
-
TECHNICAL DIRECTOR
SETH CAVENAUGH
PROPS COORDINATOR
RANDY PARSONS

The designer is responsible for the visual aspects of the production only, and the specification of the designer's designs relate solely to the appearance of the design and not to matters of safety. The designer agrees to make prompt correcting alterations to any specifications found to be incompatible with proper safety precautions.

THE COLONIAL THEATRE

11 South St., Pittsfield MA 01201

DATE: 05-04-2025

SCALE: VARIES

REVISION NO: -


DRAWN BY: JH


WALL ELEVATIONS 2

PLATE NO.

4

OF 8

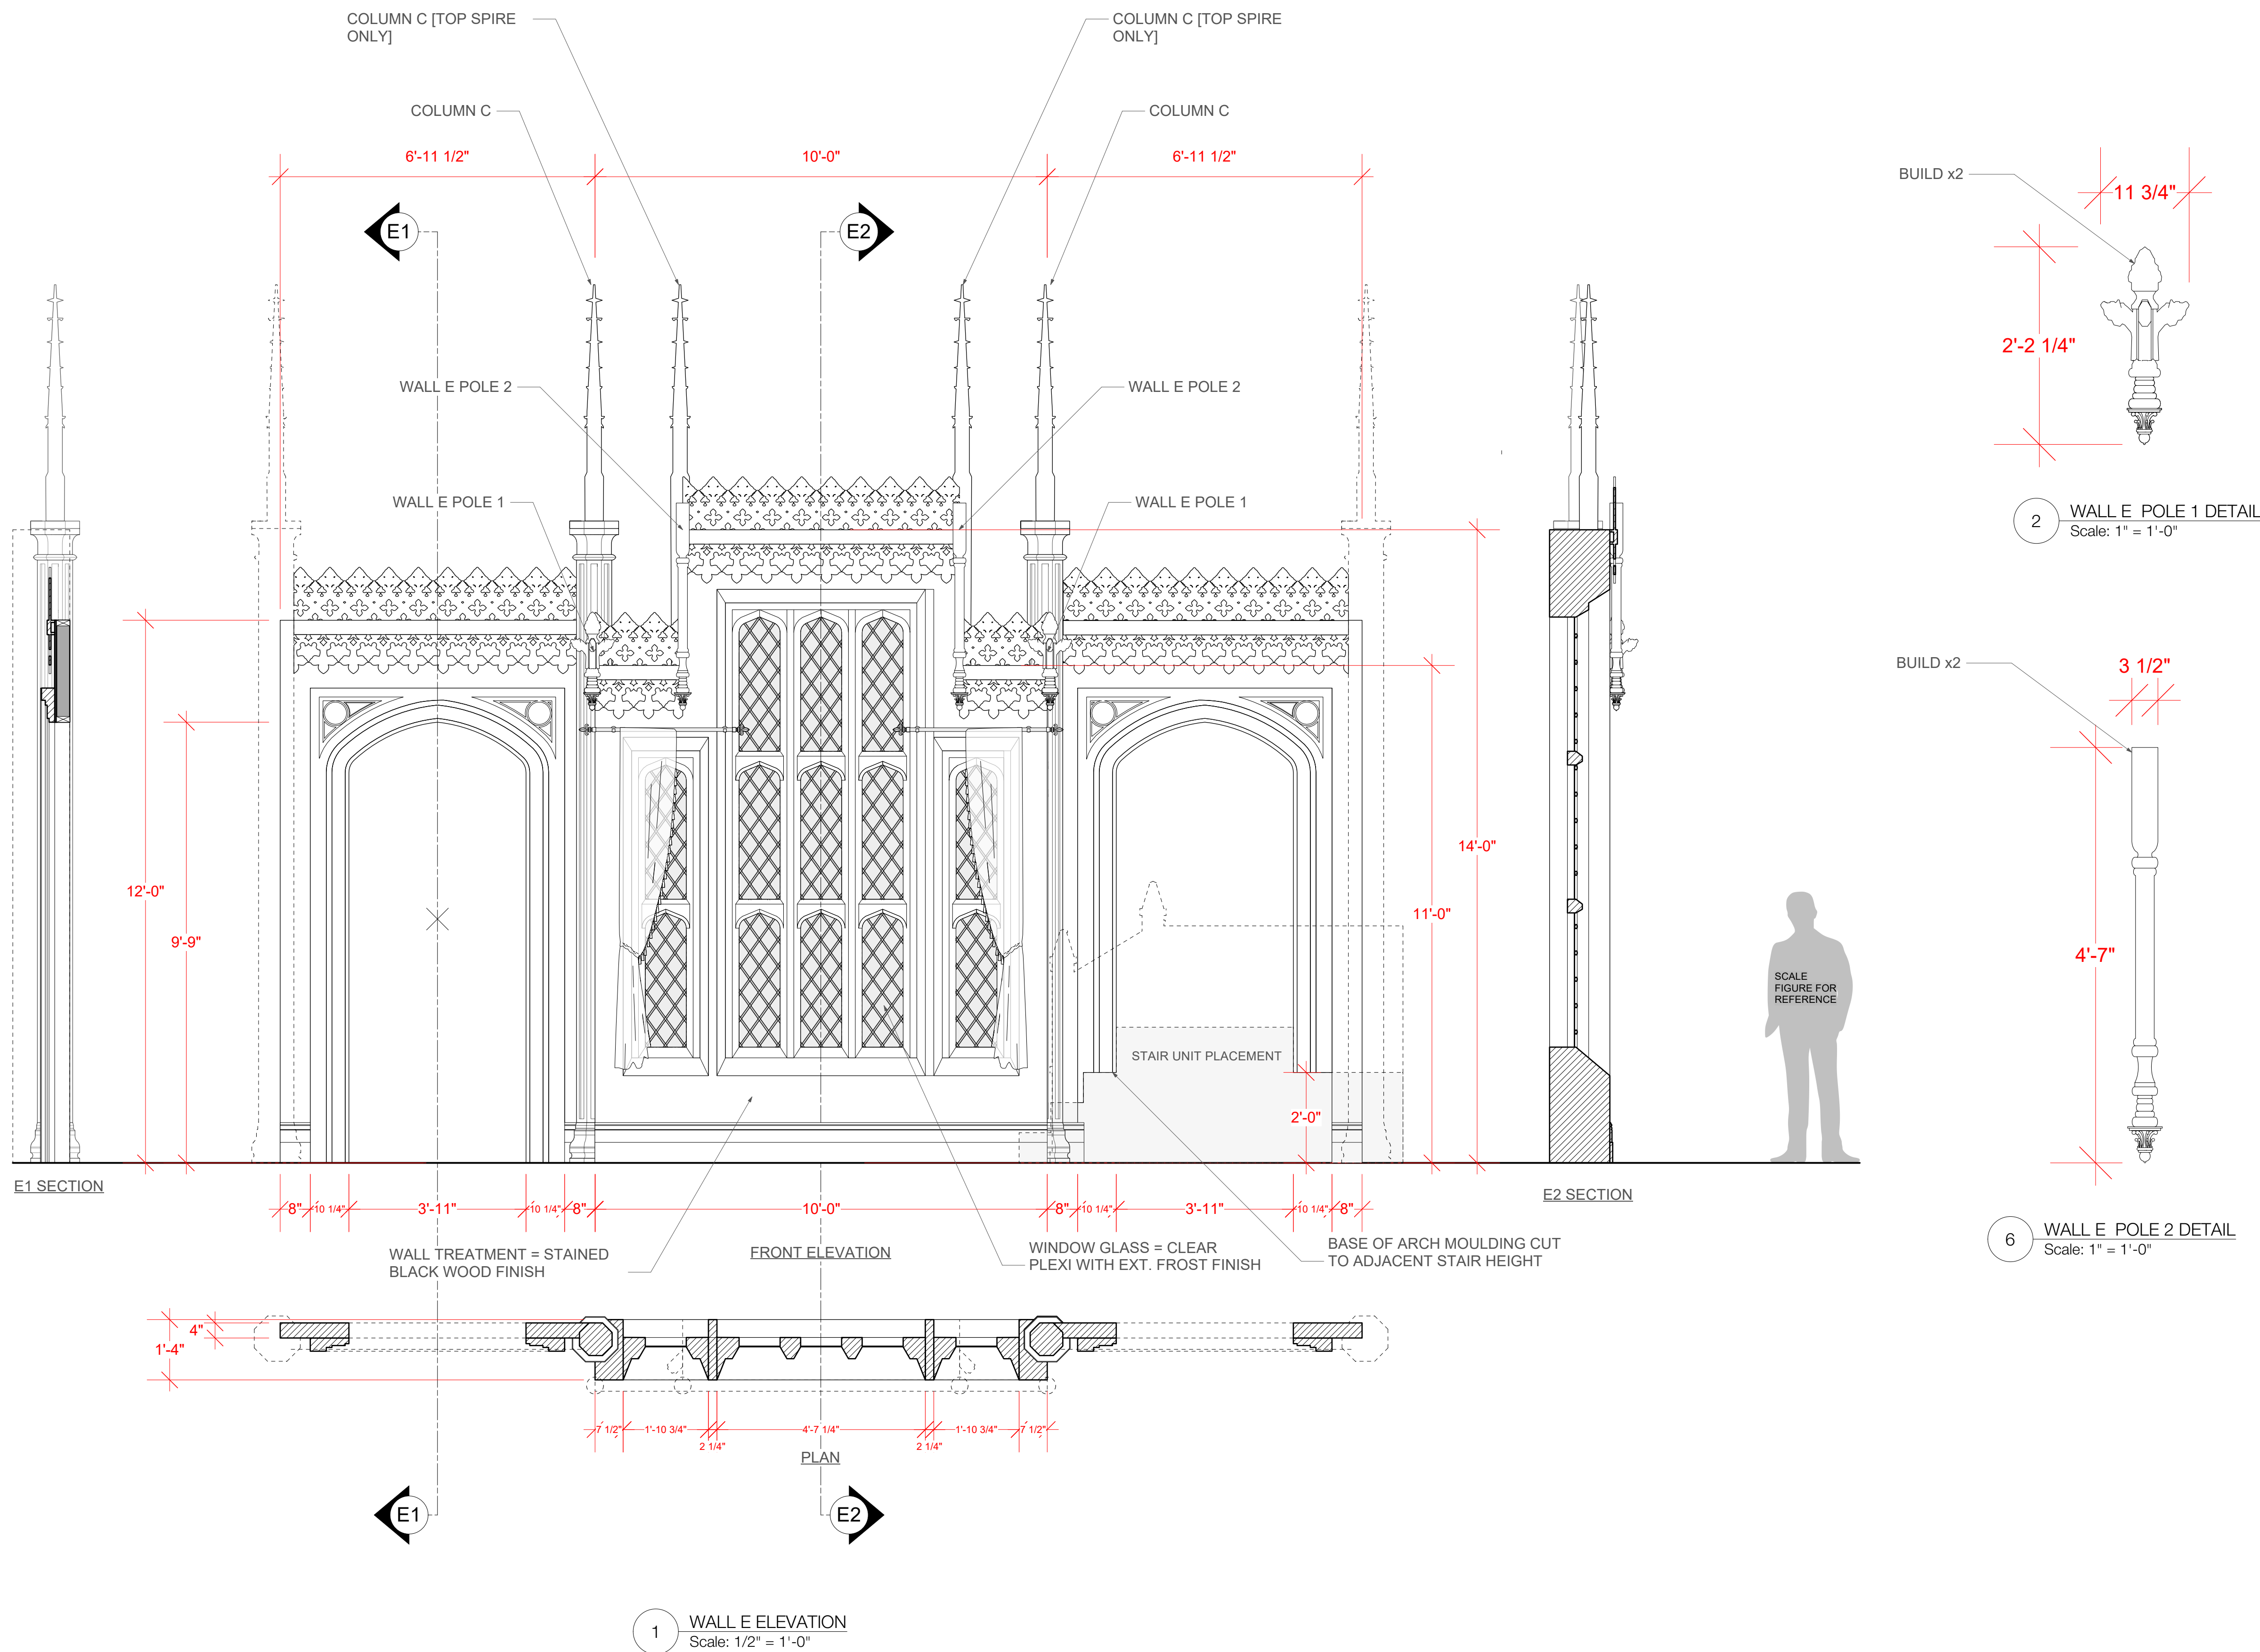

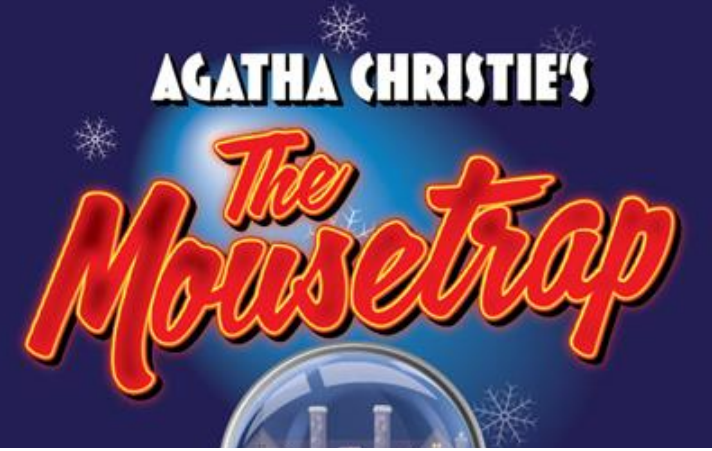

BRYCE CUTLER
SCENIC & MEDIA DESIGN
BRYCE.C.CUTLER@GMAIL.COM
561.389.3266
WWW.BRYCECUTLER.COM

BERKSHIRE THEATER GROUP PRESENTS...
**THE
MOUSETRAP**

BY AGATHA CHRISTIE
DIRECTED BY
GERRY MCINTYRE

PRODUCTION TEAM

ARTISTIC DIRECTOR
KATE MAGUIRE
DIRECTOR OF PRODUCTION
PETER DURGIN
SCENIC & MEDIA DESIGNER
BRYCE CUTLER
SCENIC ASSISTANT
JONAS HARRISON
PROJECTIONS ASSISTANT
-
LIGHTING DESIGNER
SAM RUSHEN
COSTUME DESIGNER
DUSTIN CROSS
SOUND DESIGNER
-
PRODUCTION MANAGER
-
TECHNICAL DIRECTOR
SETH CAVENAUGH
PROPS COORDINATOR
RANDY PARSONS

The designer is responsible for the visual aspects of the production only, and the specification of the designer's designs relate solely to the appearance of the design and not to matters of safety. The designer agrees to make prompt correcting alterations to any specifications found to be incompatible with proper safety precautions.

THE COLONIAL THEATRE

11 South St., Pittsfield MA 01201

DATE: 05-04-2025

SCALE: 1/2" = 1'-0"

REVISION NO: -



DRAWN BY: JH


WALL ELEVATIONS

PLATE NO.

5

OF 8

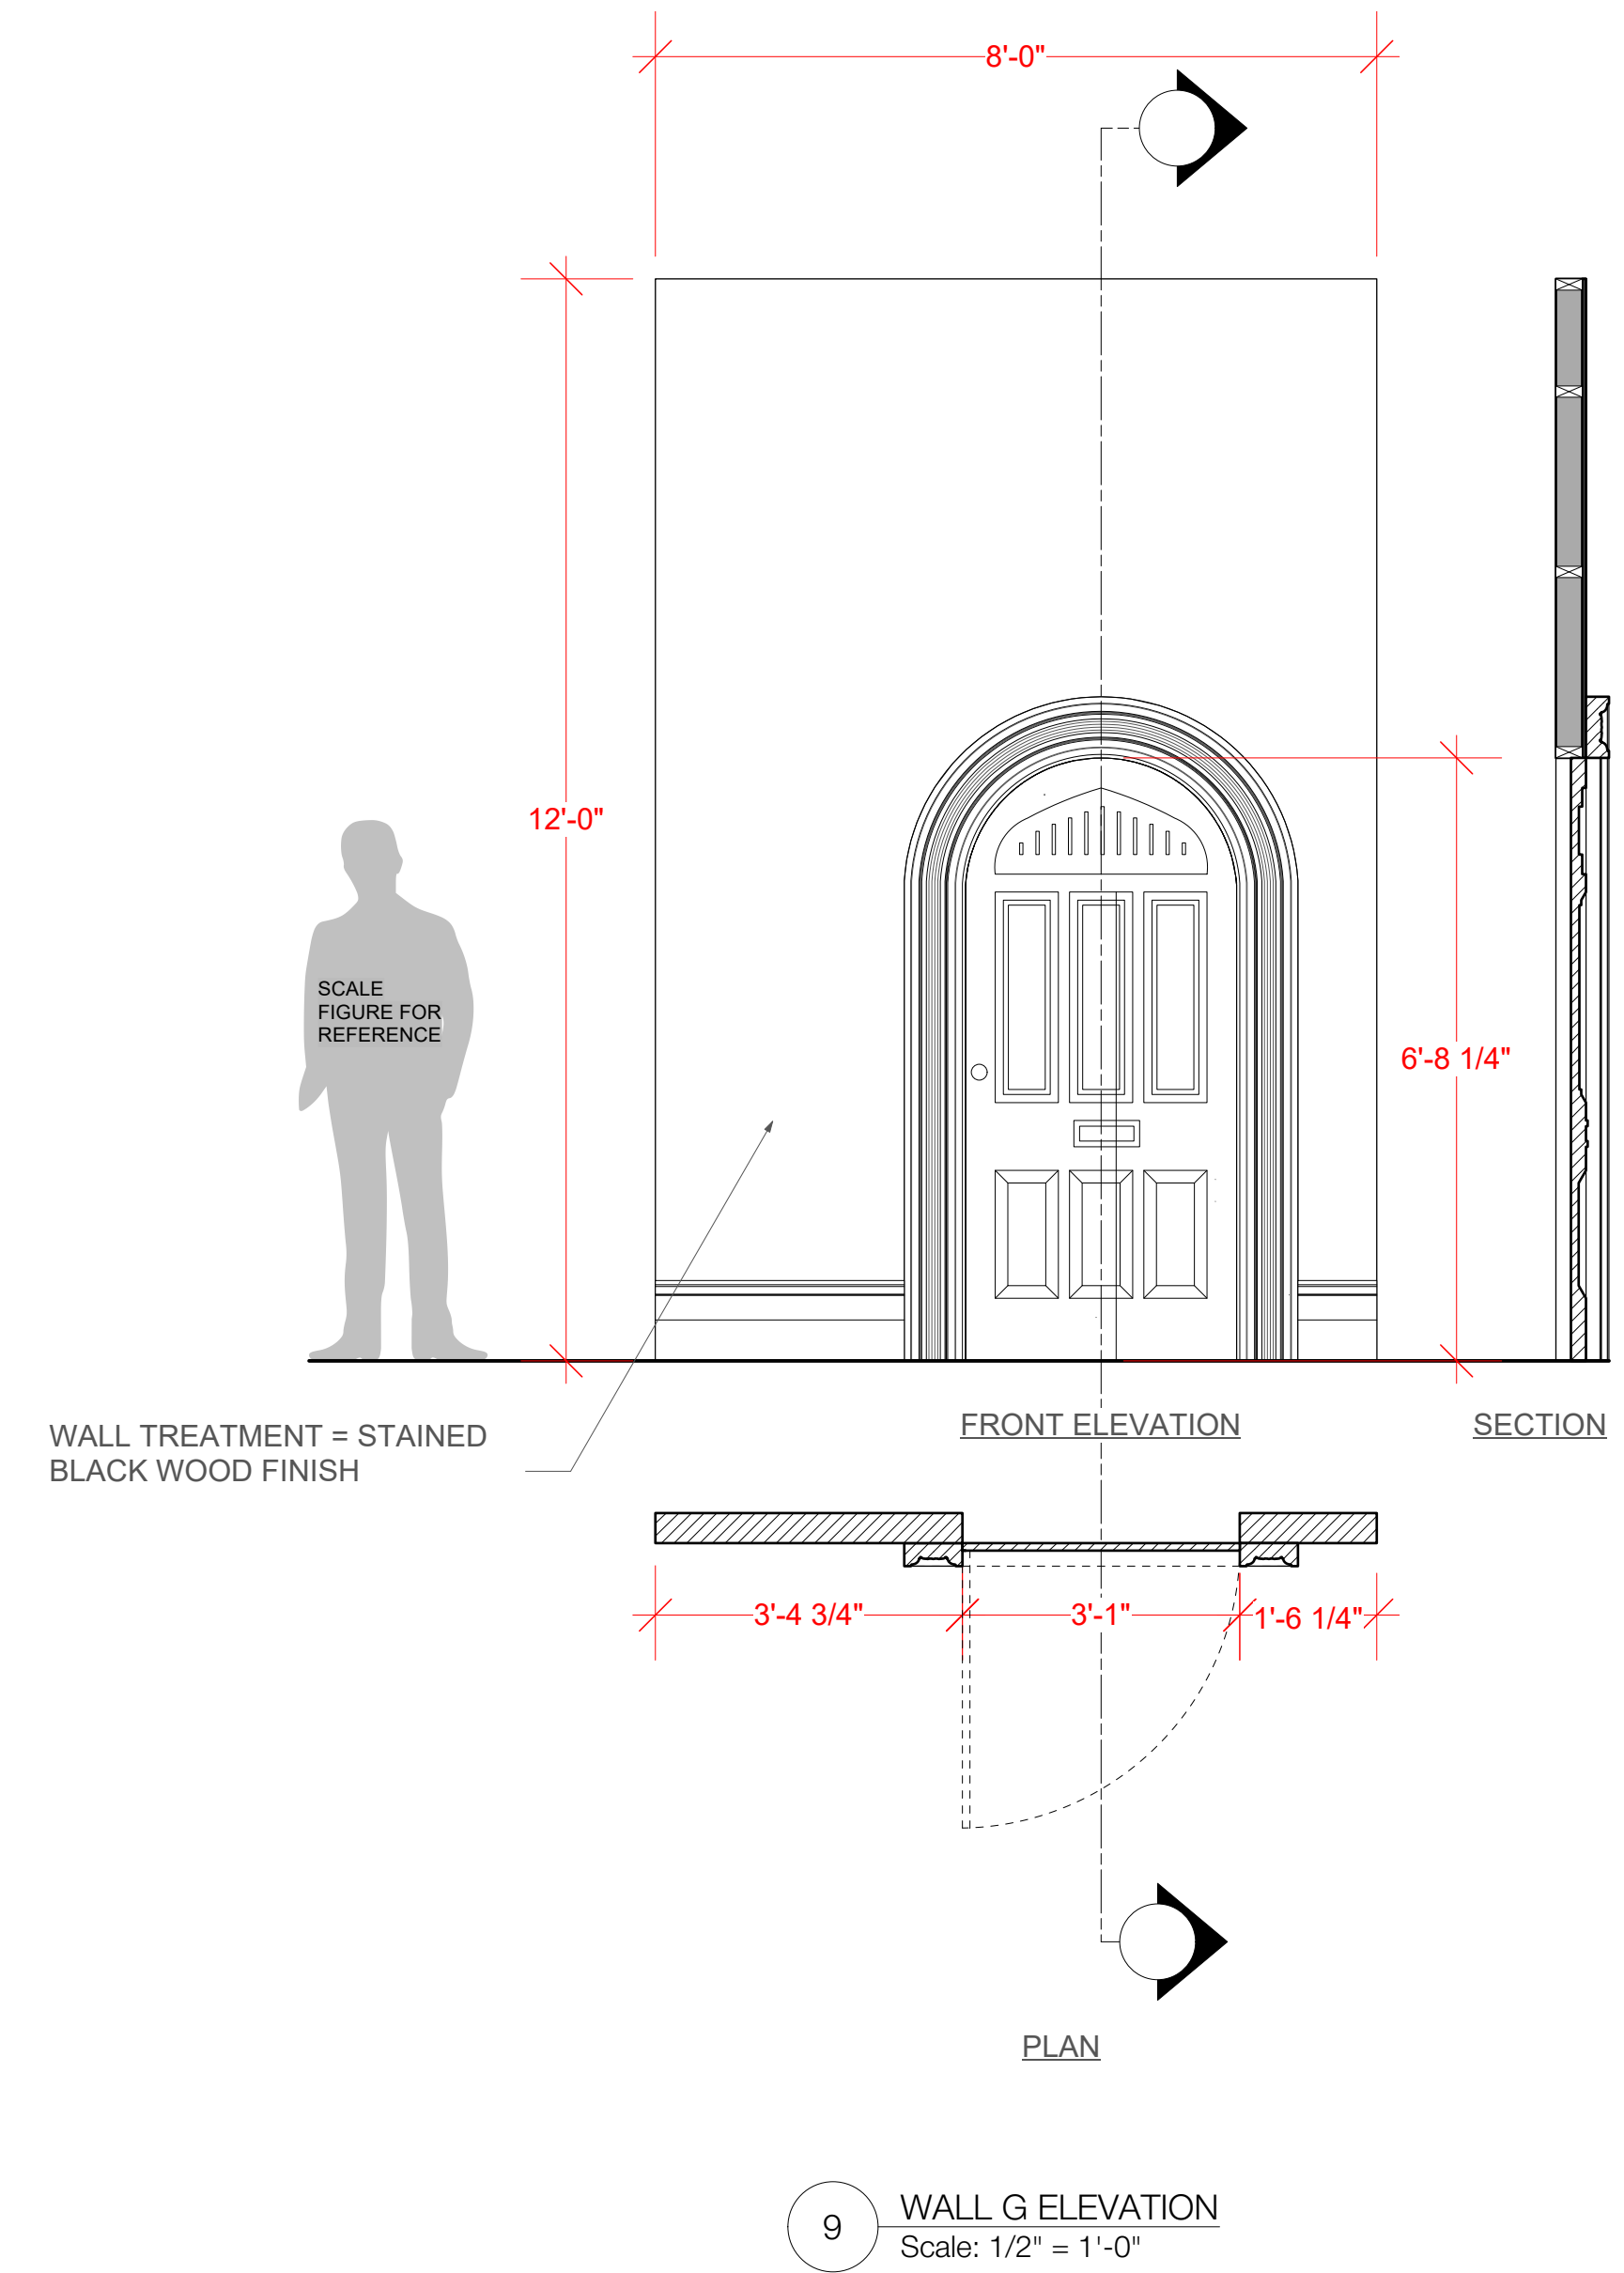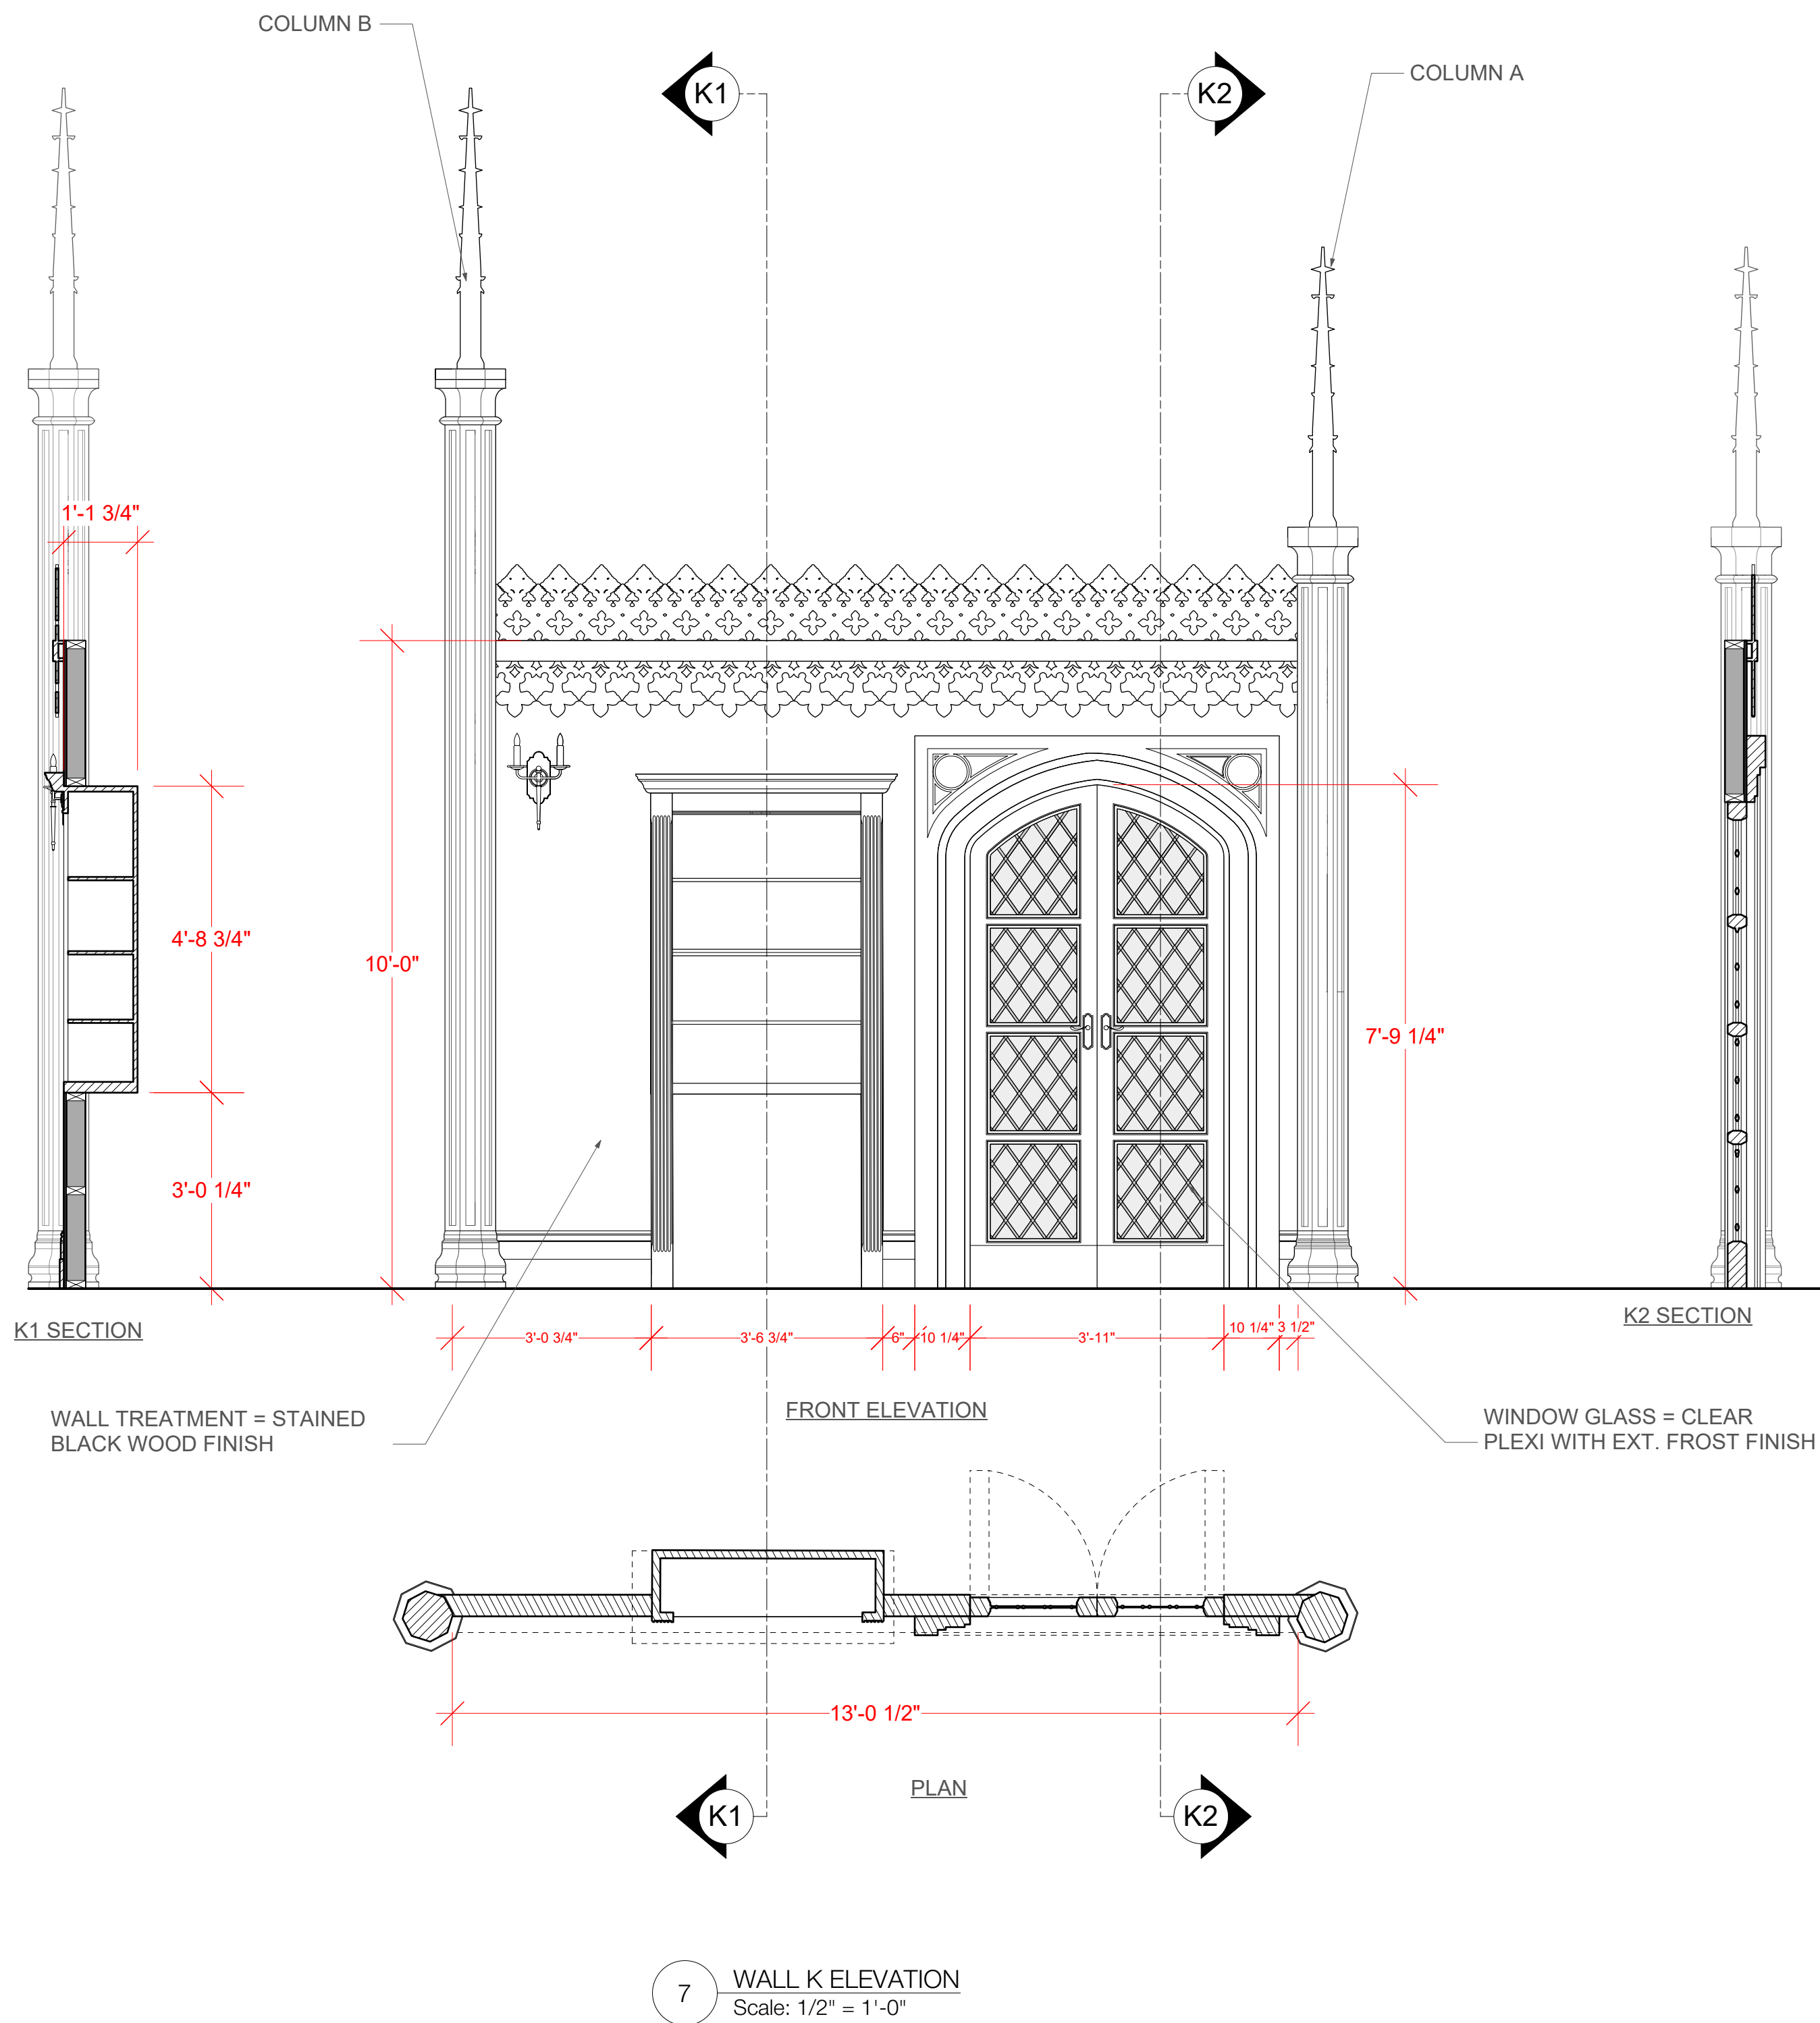

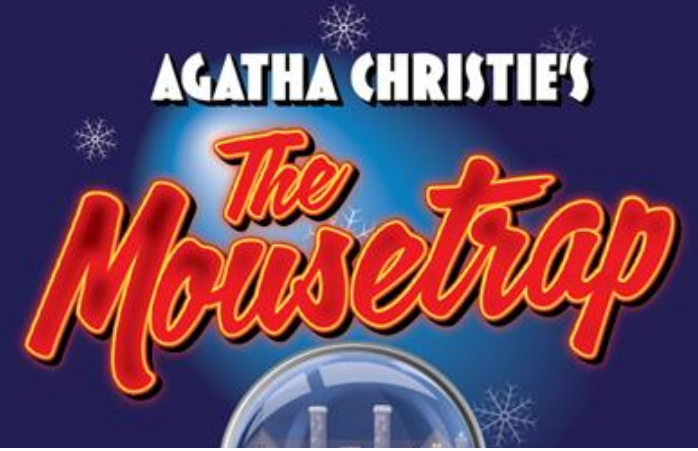

BRYCE CUTLER
SCENIC & MEDIA DESIGN
BRYCE.C.CUTLER@GMAIL.COM
561.389.3266
WWW.BRYCECUTLER.COM

BERKSHIRE THEATER GROUP PRESENTS...

THE MOUSETRAP

BY AGATHA CHRISTIE
DIRECTED BY
GERRY MCINTYRE

PRODUCTION TEAM

ARTISTIC DIRECTOR
KATE MAGUIRE
DIRECTOR OF PRODUCTION
PETER DURGIN
SCENIC & MEDIA DESIGNER
BRYCE CUTLER
SCENIC ASSISTANT
JONAS HARRISON
PROJECTIONS ASSISTANT
-
LIGHTING DESIGNER
SAM RUSHEN
COSTUME DESIGNER
DUSTIN CROSS
SOUND DESIGNER
-
PRODUCTION MANAGER
-
TECHNICAL DIRECTOR
SETH CAVENAUGH
PROPS COORDINATOR
RANDY PARSONS

The designer is responsible for the visual aspects of the production only, and the specification of the designer's designs relate solely to the appearance of the design and not to matters of safety. The designer agrees to make prompt correcting alterations to any specifications found to be incompatible with proper safety precautions.

THE COLONIAL THEATRE

11 South St., Pittsfield MA 01201

DATE: 05-04-2025

SCALE: VARIES

REVISION NO: -




DRAWN BY: JH

WALL + SCENIC ELEVATIONS

PLATE NO.

6

OF 8

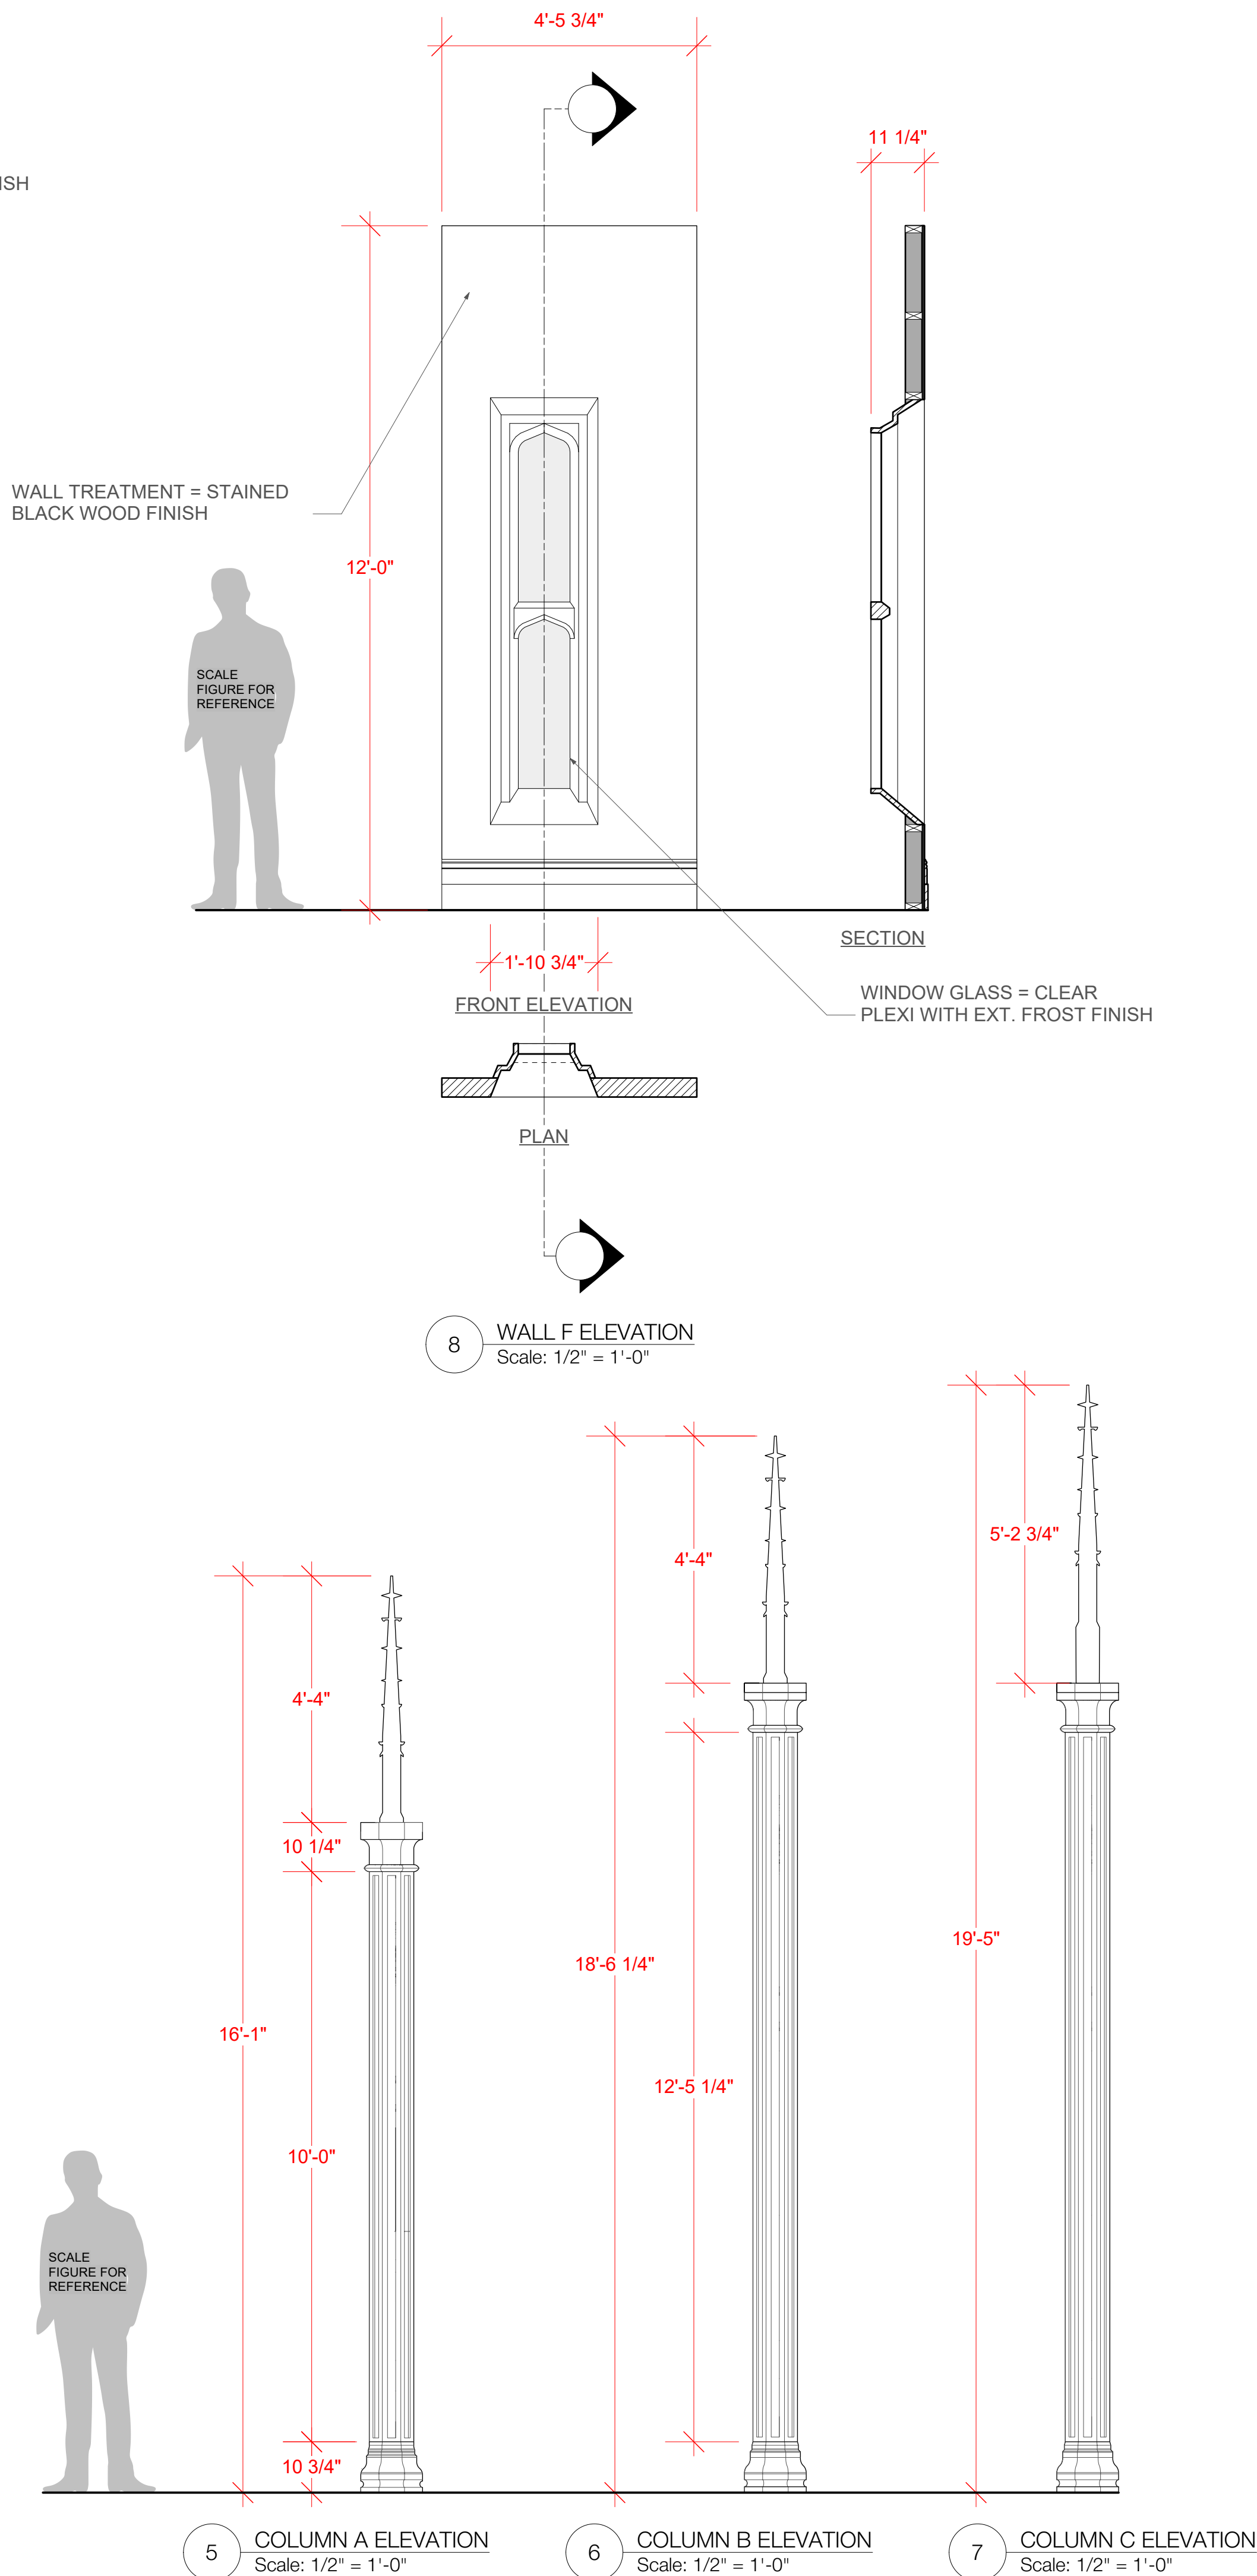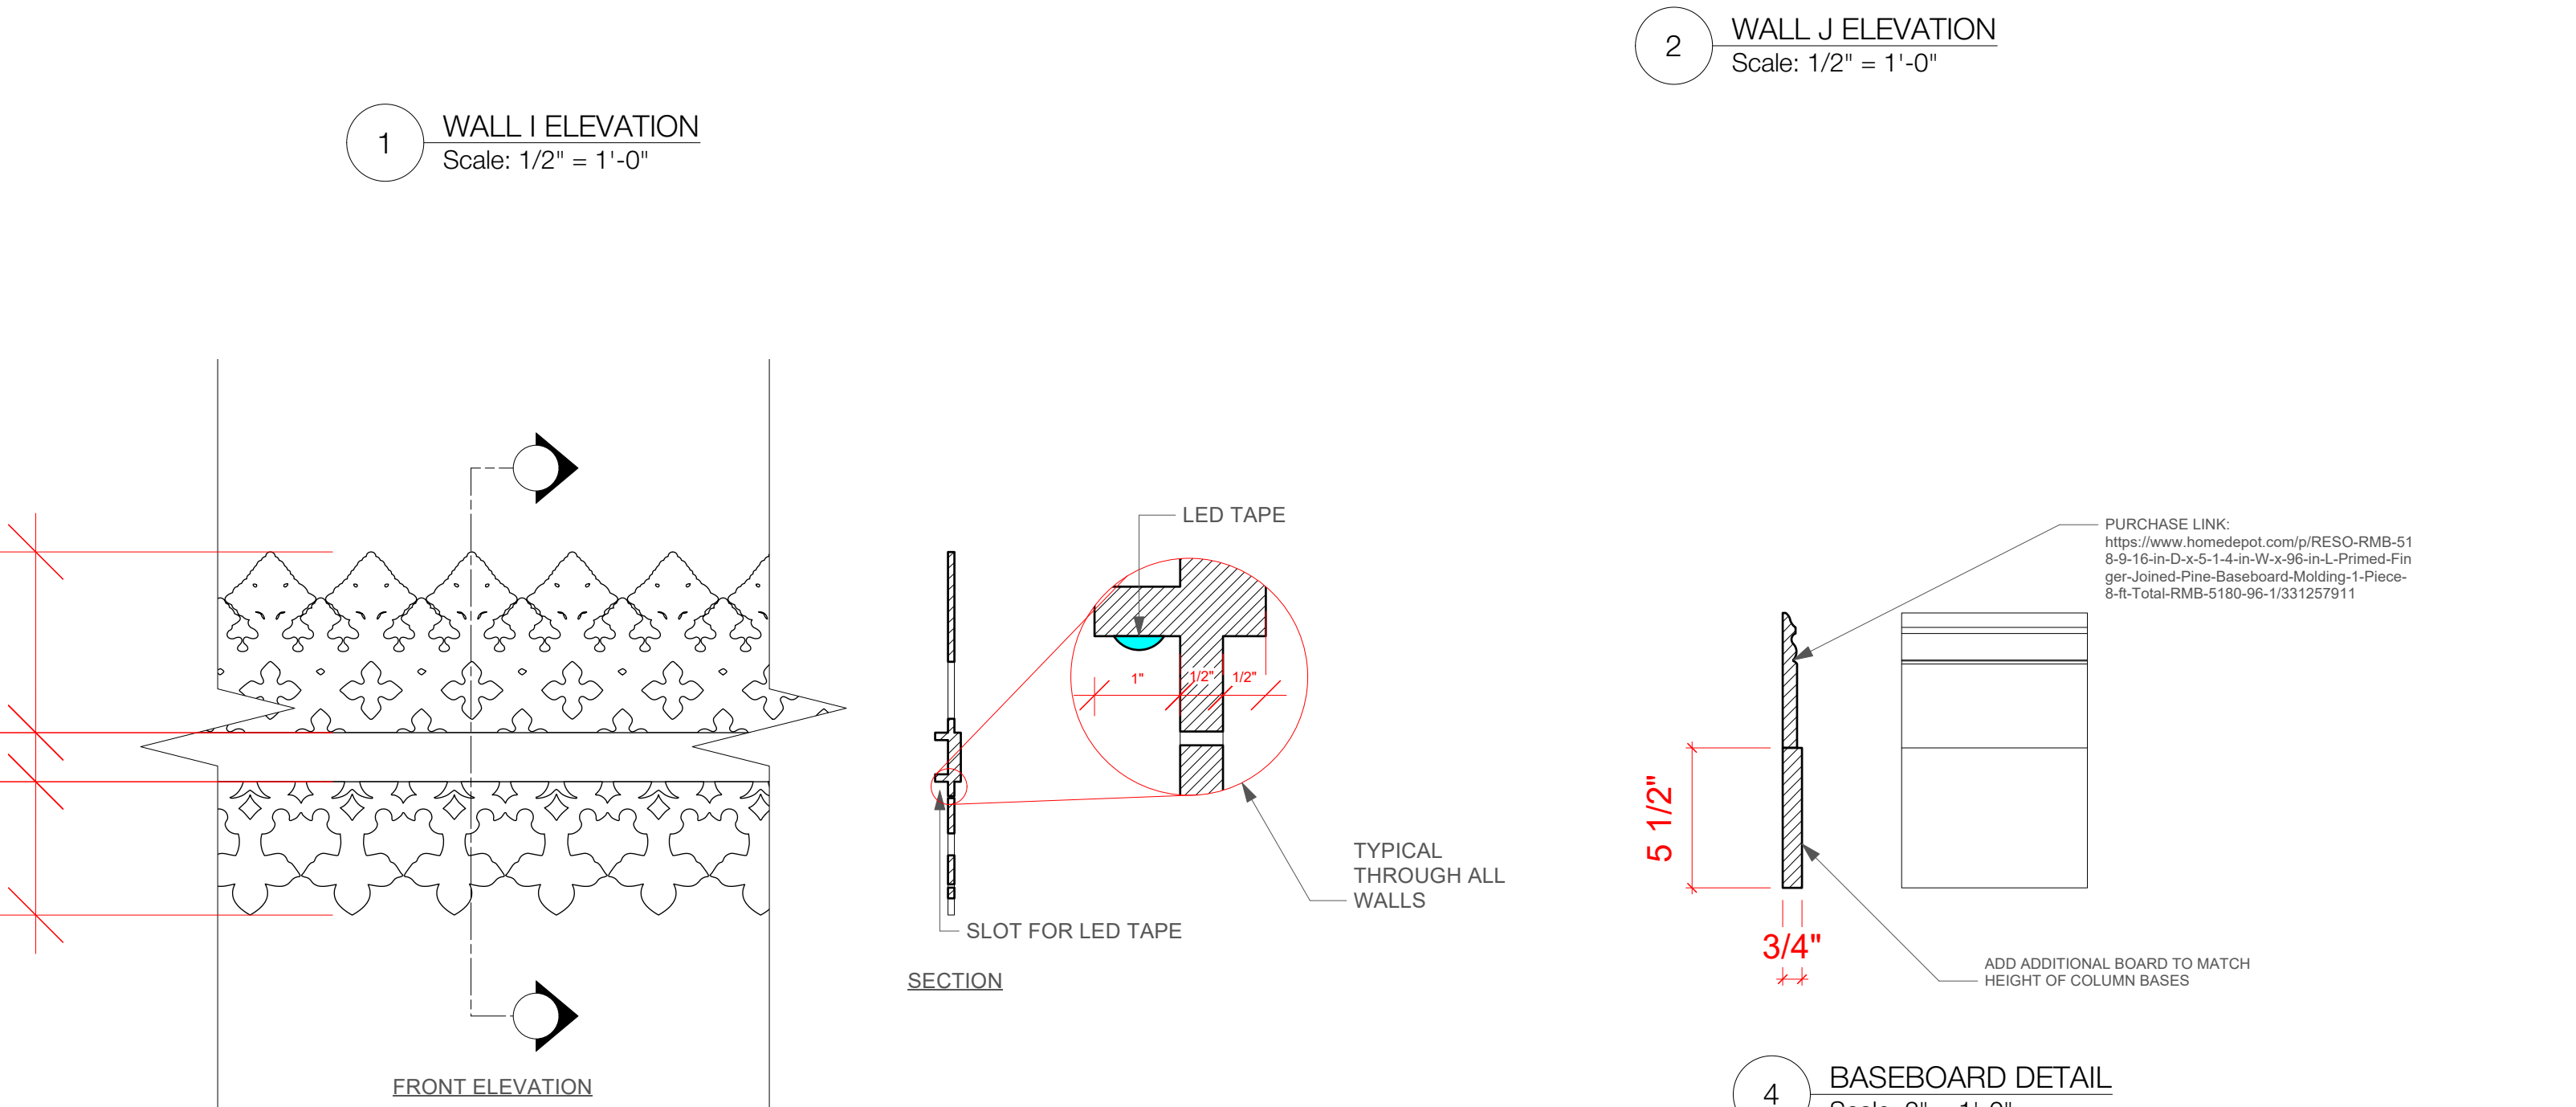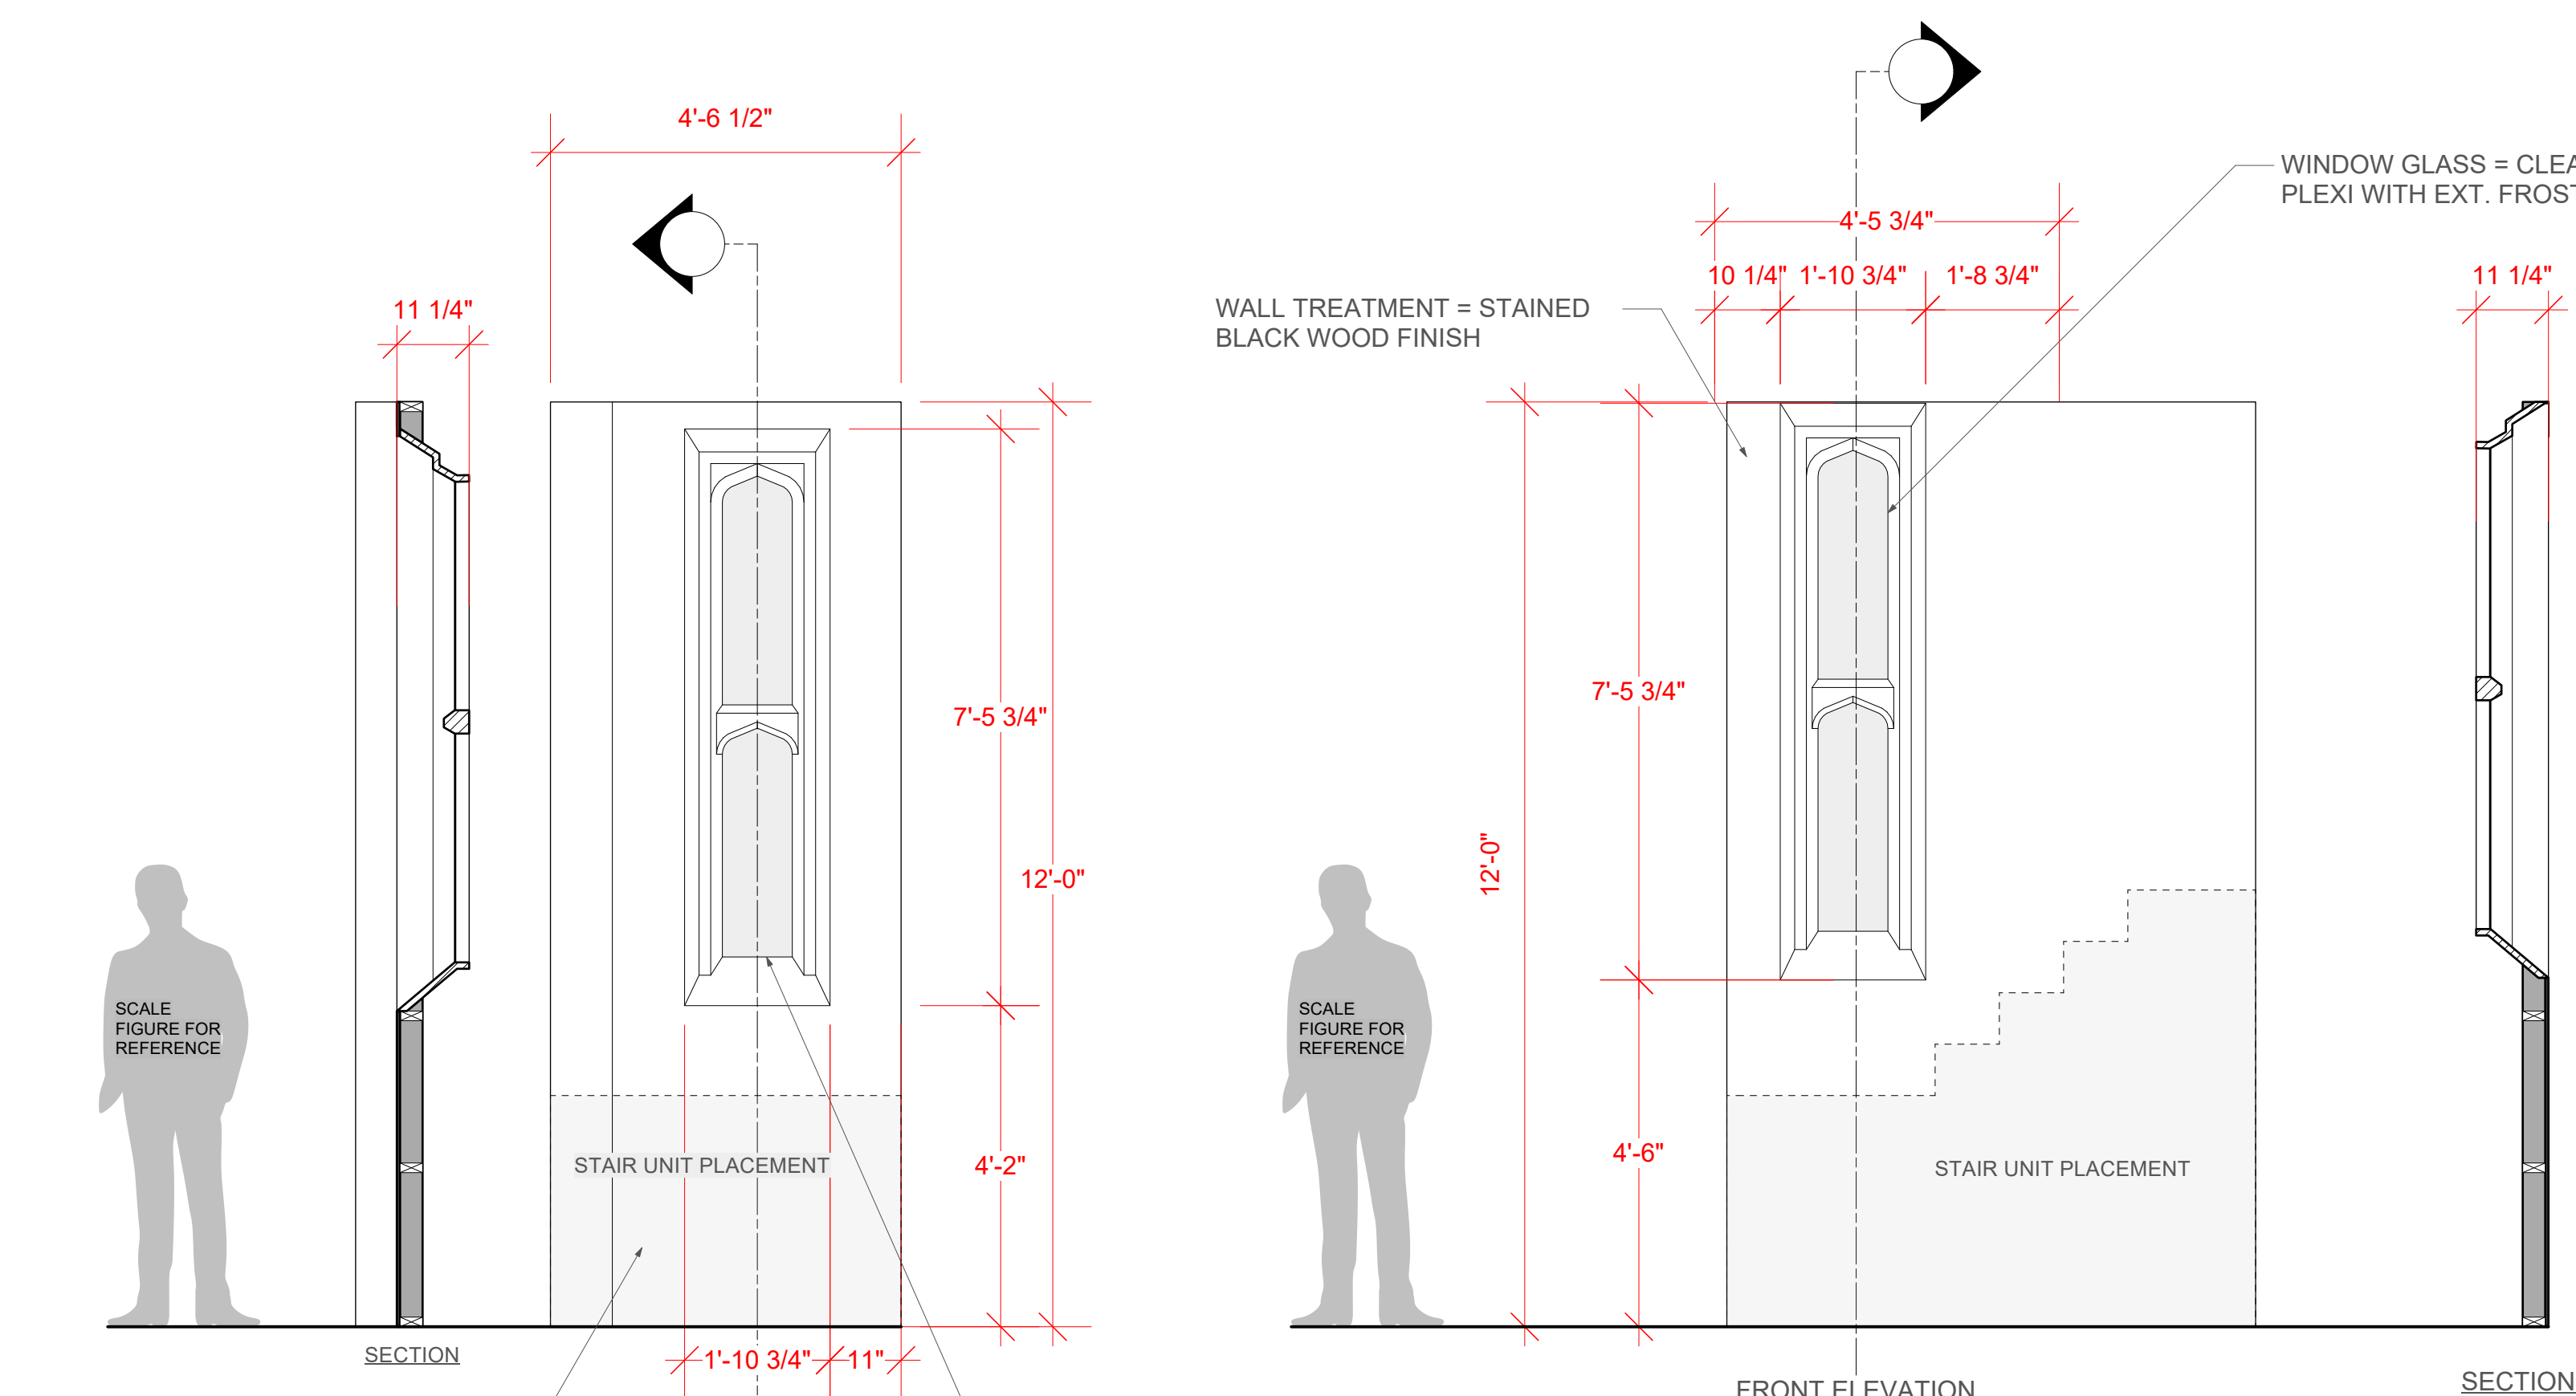



BERKSHIRE THEATER GROUP PRESENTS...

DIRECTED BY
GERRY MCINTYRE

ARTISTIC DIRECTOR
KATE MAGUIRE

DIRECTOR OF PRODUCTION
PETER DURGIN

SCENIC & MEDIA DESIGNER
BYRCE CUTLER

SCENIC ASSISTANT
JONAS HARRISON

PROJECTIONS ASSISTANT
-

LIGHTING DESIGNER
SAM RUSHEN

COSTUME DESIGNER
DUSTIN CROSS

SOUND DESIGNER
-
-

PRODUCTION MANAGER

TECHNICAL DIRECTOR
SETH CAVENAUGH

PROPS COORDINATOR
RANDY PARSONS

The designer is responsible for the visual aspects of the production only, and the specification of the designer's designs relate solely to the appearance of the design and not to matters of safety. The designer agrees to make prompt correcting alterations to any specifications found to be incompatible with proper safety precautions.




11 South St., Pittsfield MA 01201

DRAWN BY: JH



PLATE NO.

7

  
DF 8

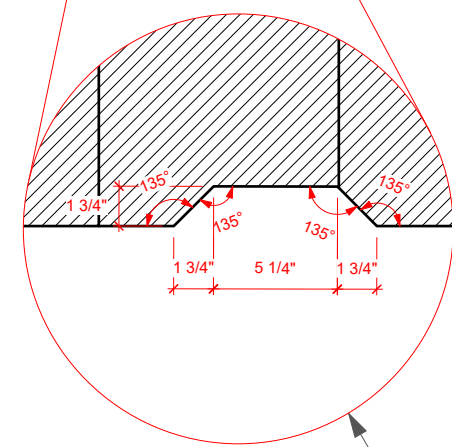

STAIRS CUT TO FIT AROUND
- COLUMN

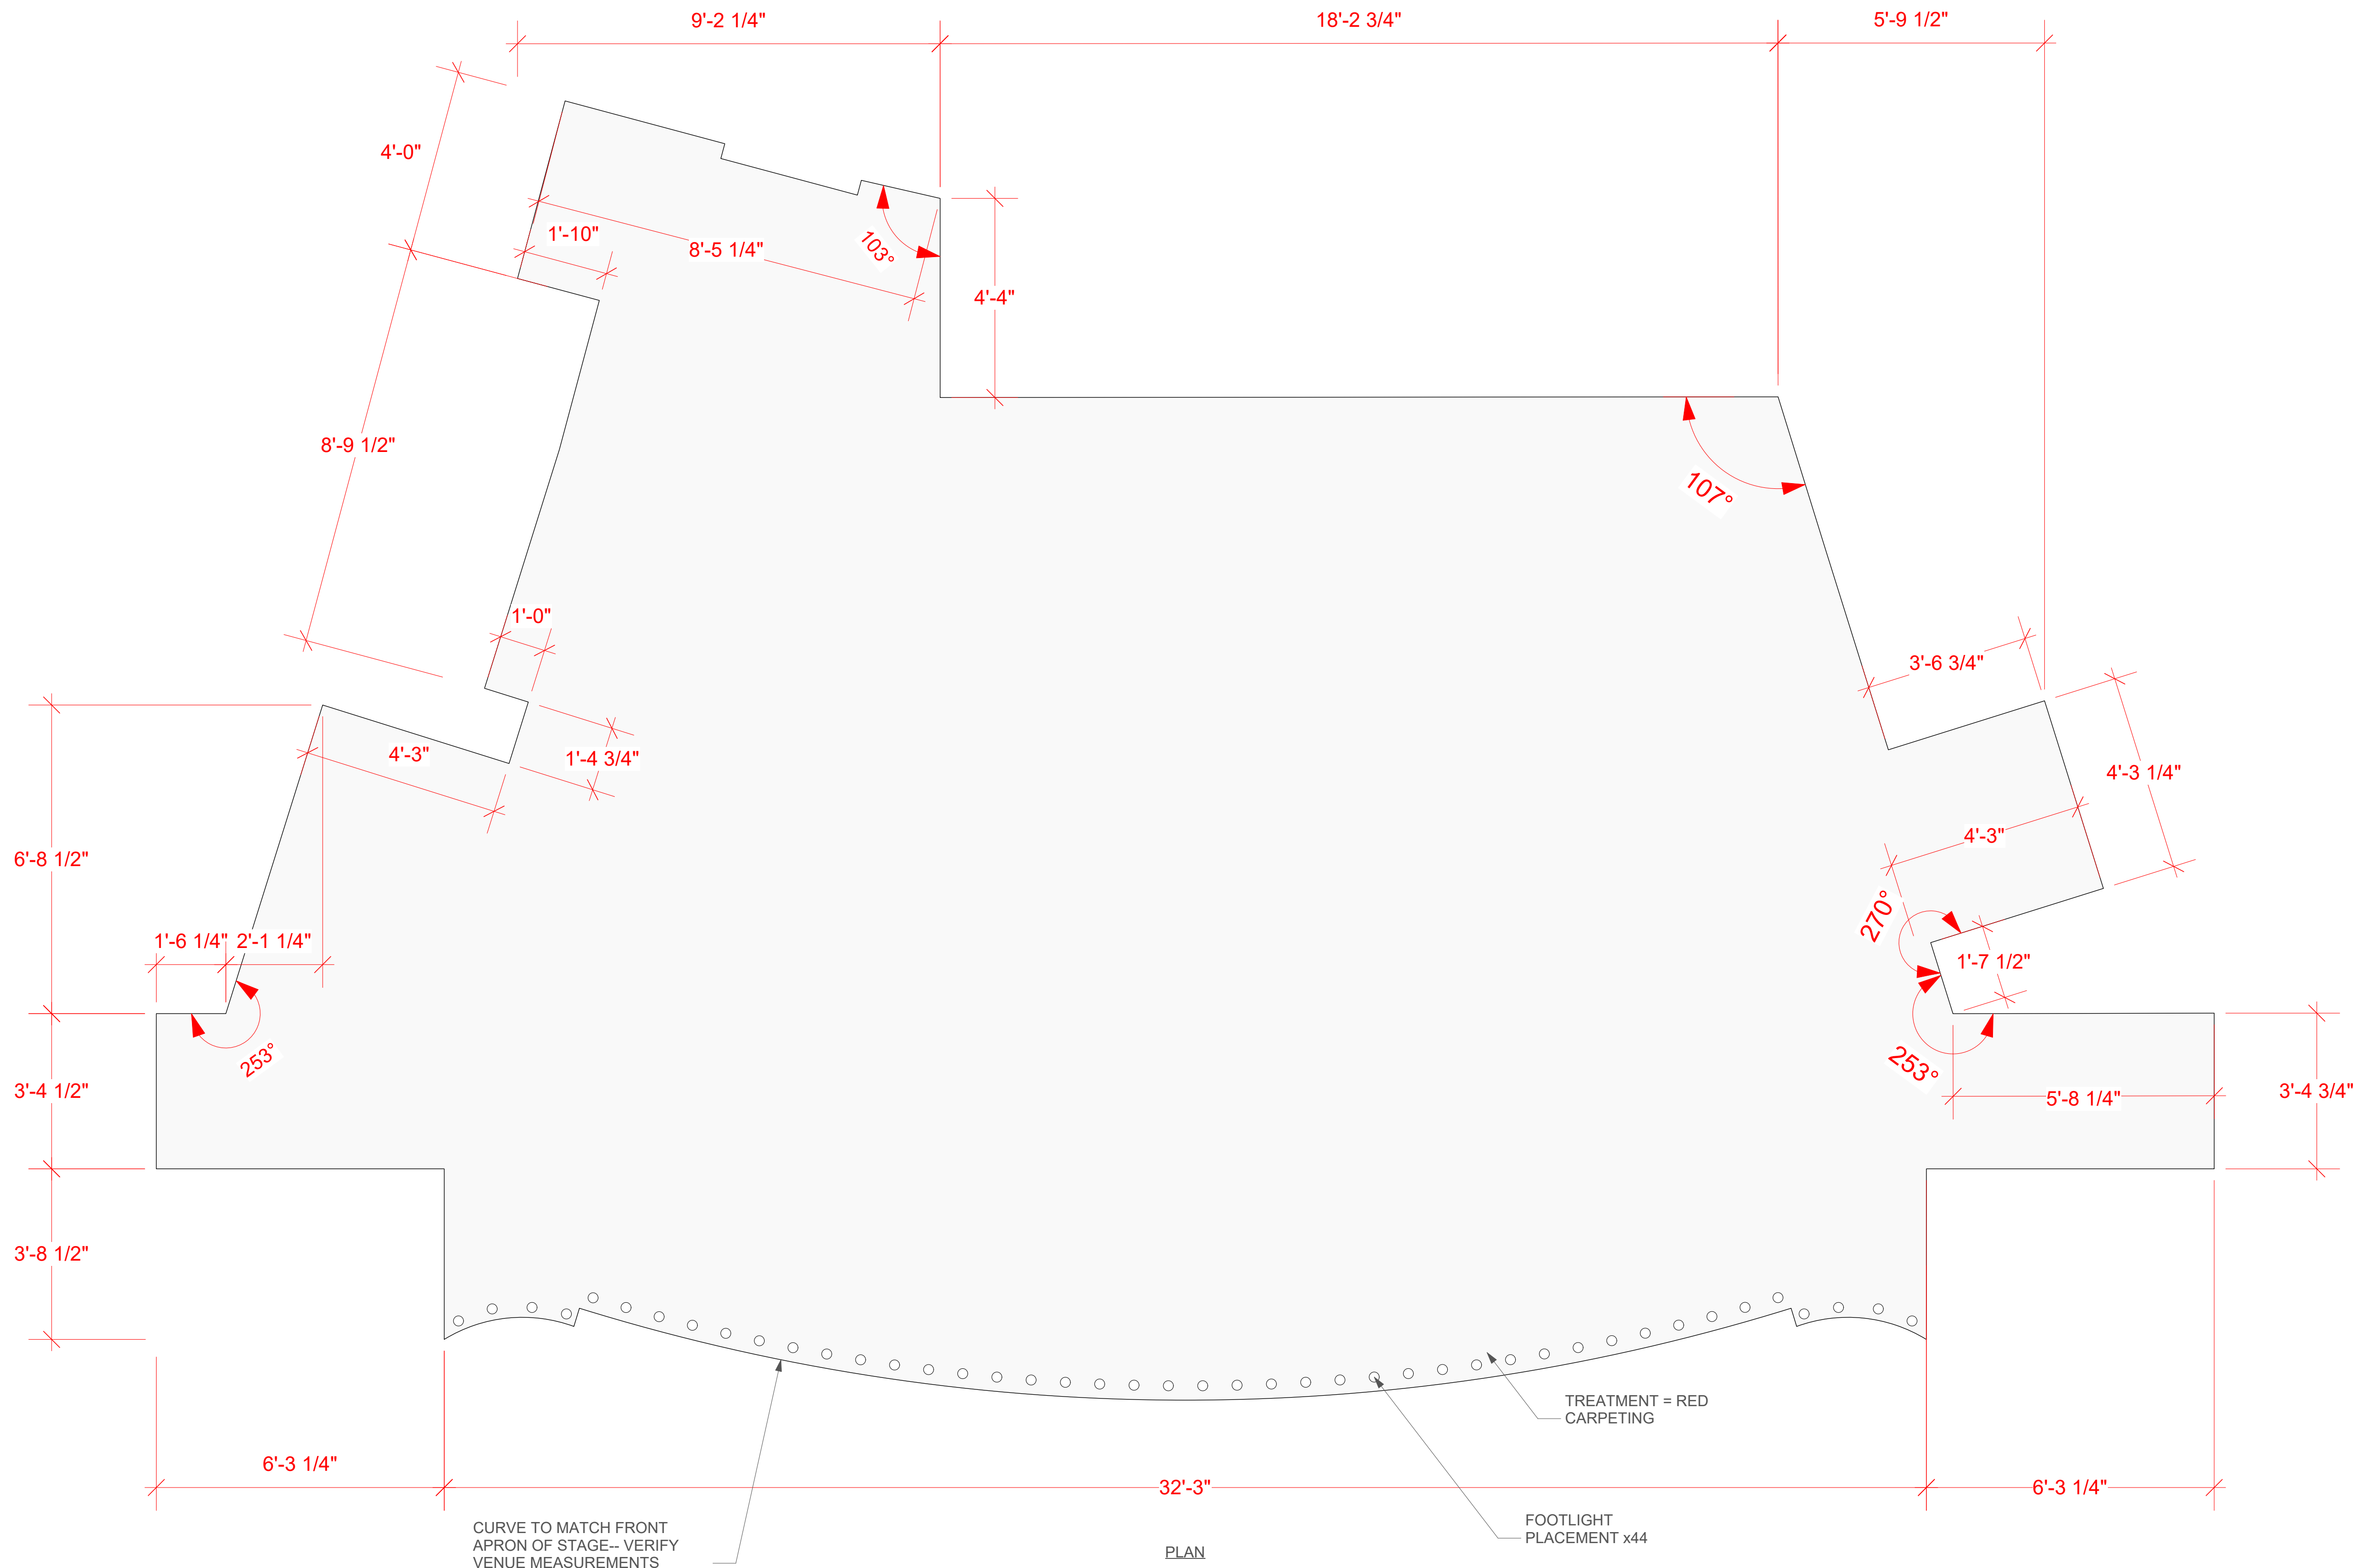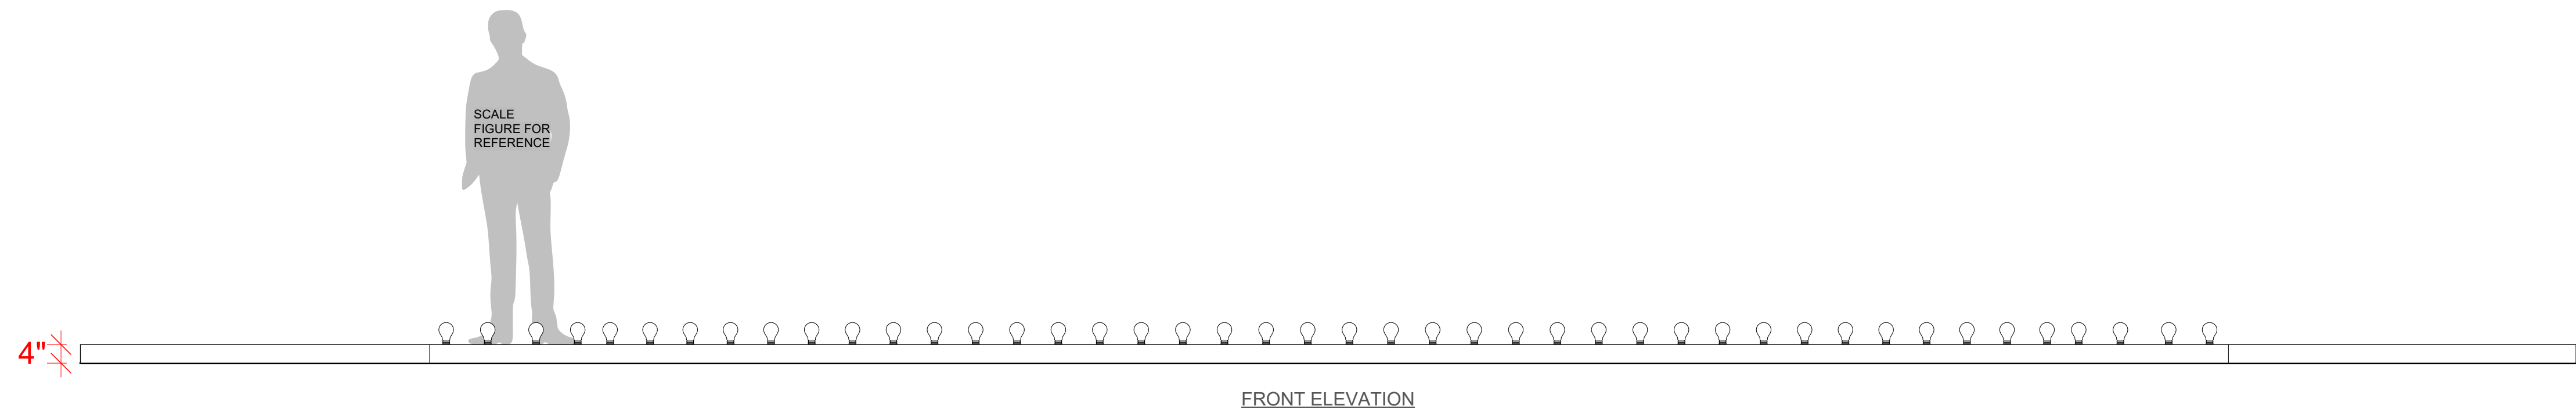

1 RAISED DECK ELEVATION
Scale: 1/2" = 1'-0"

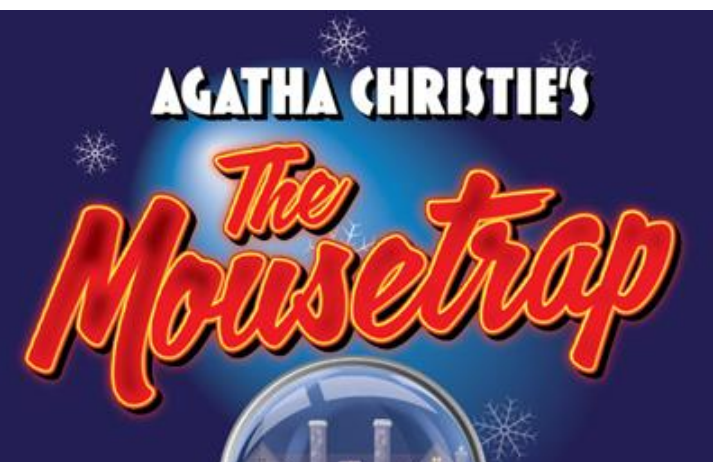

BRYCE CUTLER
SCENIC & MEDIA DESIGN
BRYCE.C.CUTLER@GMAIL.COM
561.389.3266
WWW.BRYCECUTLER.COM

BERKSHIRE THEATER GROUP PRESENTS...
**THE
MOUSETRAP**
BY AGATHA CHRISTIE
DIRECTED BY
GERRY MCINTYRE

PRODUCTION TEAM

ARTISTIC DIRECTOR
KATE MAGUIRE
DIRECTOR OF PRODUCTION
PETER DURGIN
SCENIC & MEDIA DESIGNER
BRYCE CUTLER
SCENIC ASSISTANT
JONAS HARRISON
PROJECTIONS ASSISTANT
-
LIGHTING DESIGNER
SAM RUSHEN
COSTUME DESIGNER
DUSTIN CROSS
SOUND DESIGNER
-
PRODUCTION MANAGER
-
TECHNICAL DIRECTOR
SETH CAVENAUGH
PROPS COORDINATOR
RANDY PARSONS

The designer is responsible for the visual aspects of the production only, and the specification of the designer's designs relate solely to the appearance of the design and not to matters of safety. The designer agrees to make prompt correcting alterations to any specifications found to be incompatible with proper safety precautions.

THE COLONIAL THEATRE

11 South St., Pittsfield MA 01201

DATE: 05-04-2025

SCALE: 1/2" = 1'-0"

REVISION NO: -

DRAWN BY: JH

RAISED DECK

PLATE NO.

8

OF 8