

51. WIND DROP	51
50	50
49	49
48. WHITE BOUNCE	48
47	47
46	46
45. 5TH ELECTRIC	45
44. CYC	44
43. BLACK SCRIM	43
42. LEGS	42
41. BORDER	41
40	40
39	39
38	38
37	37
36	36
35	35
34	34
33	33
32	32
31. TRAVELER	31
30	30
29. BLACKOUT CURTAIN	29
28	28
27	27
26. 3RD ELECTRIC	26
25	25
24. MYLAR RAIN CURTAIN	24
23. FLYING PROSC.	23
22	22
21	21
20	20
19. LEGS	19
18. BORDER (TRIM HT 16'-5")	18
17	17
16	16
15	15
14	14
13	13
12	12
11	11
10. LEGS	10
9. BORDER (TRIM HT 16'-3")	9
8	8
7	7
6	6
5	5
4	4
3. 1ST ELECTRIC	3
2	2
Orchestra Shell (1'-4" x 2'-5")	1

1 **1/4" GROUND PLAN**
Scale: 1/4" = 1'-0"

The Princeton Triangle Club
at the McCarter Theatre Presents
PAGEANT PENDING


Book, Music, and Lyrics
TRIANGLE WRITERS
WORKSHOP

Direction Sam Hayes
Choreography Taylor Gordon
Music Direction Pete Mills
Set Design Court Watson
Costume Design Stephanie Echevarria
Lighting Design Alex Slisher & Al Potter
Scenic Draughtsperson Jonas Harrison

GROUND PLAN
Scale: 1/4" = 1'-0" (PRINTED 18" X 24")
1/8" = 1'-0" (PRINTED 11" X 17")
Draft Date: 10.7.24
Plate No.

1

of [13]

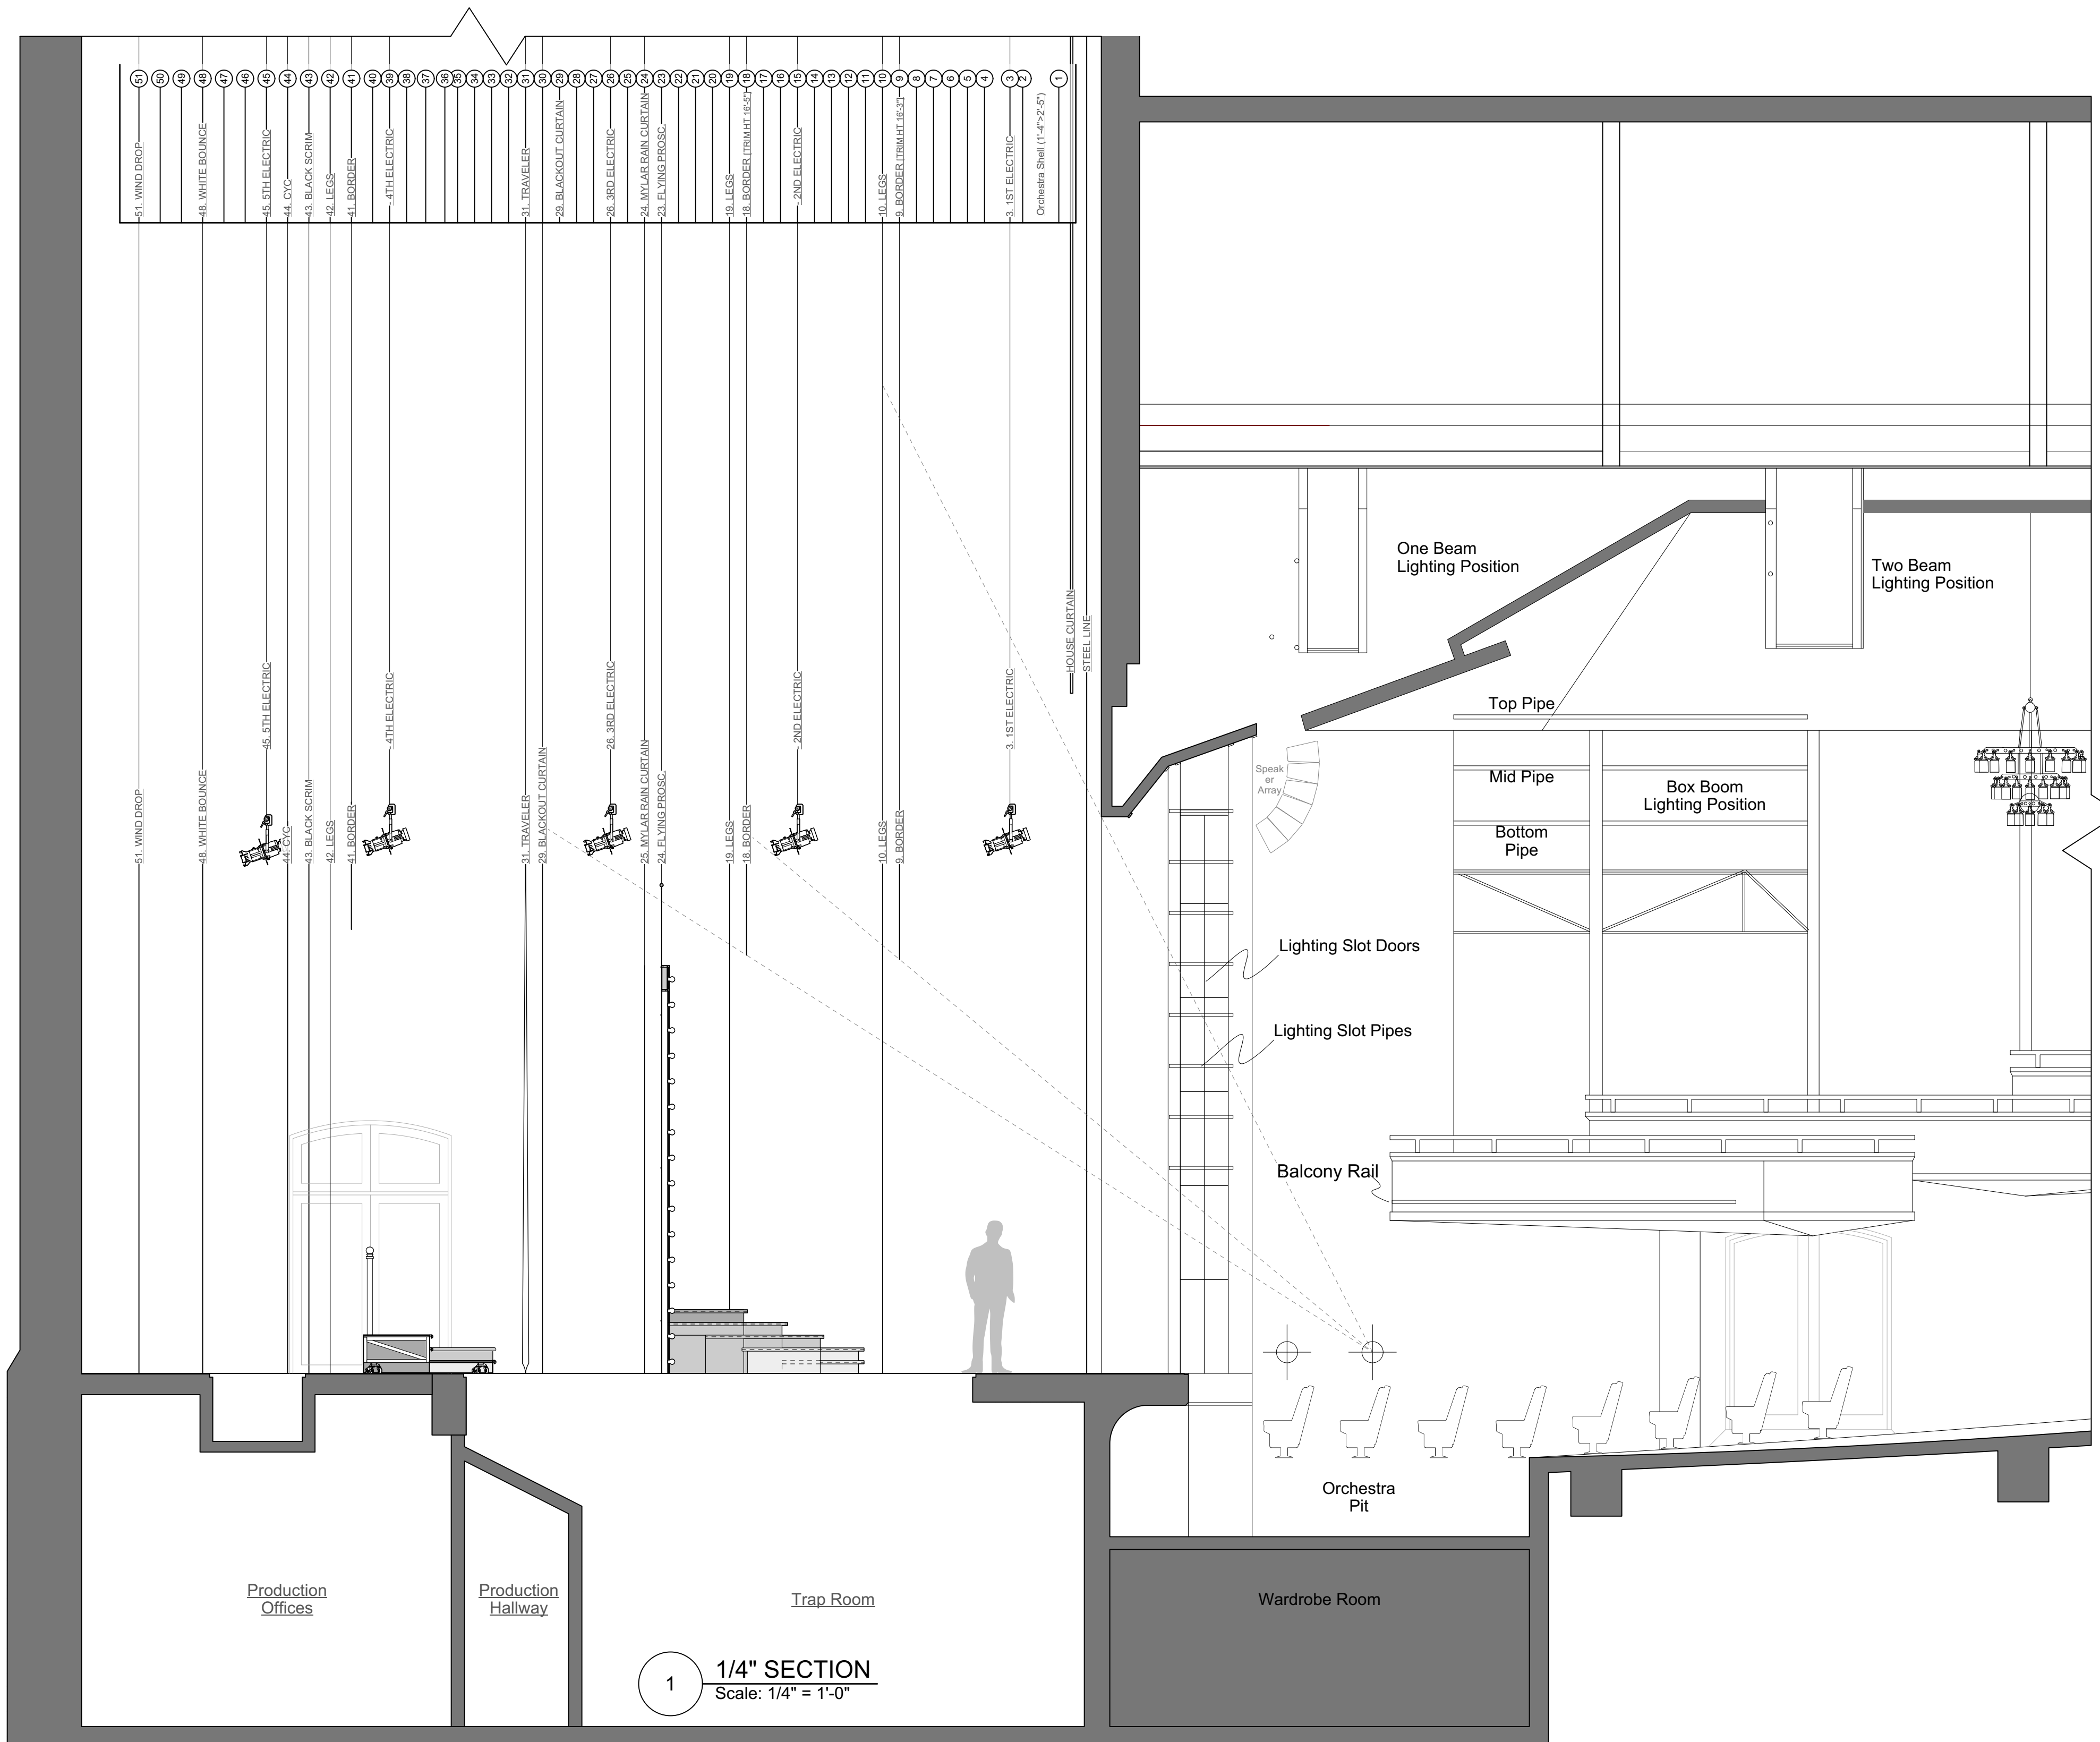

1 1/4" SECTION
Scale: 1/4" = 1'-0"

The Princeton Triangle Club
at the McCarter Theatre Presents
PAGEANT PENDING


Book, Music, and Lyrics
TRIANGLE WRITERS
WORKSHOP

Direction Sam Hayes
Choreography Taylor Gordon
Music Direction Pete Mills
Set Design Court Watson
Costume Design Stephanie Echevarria
Lighting Design Alex Slisher & Al Potter
Scenic Draughtsperson Jonas Harrison

SECTION
Scale: 1/4" = 1'-0" (PRINTED 18" X 24")
1/8" = 1'-0" (PRINTED 11" X 17")
Draft Date: 10.7.24
Plate No.

2


of [13]

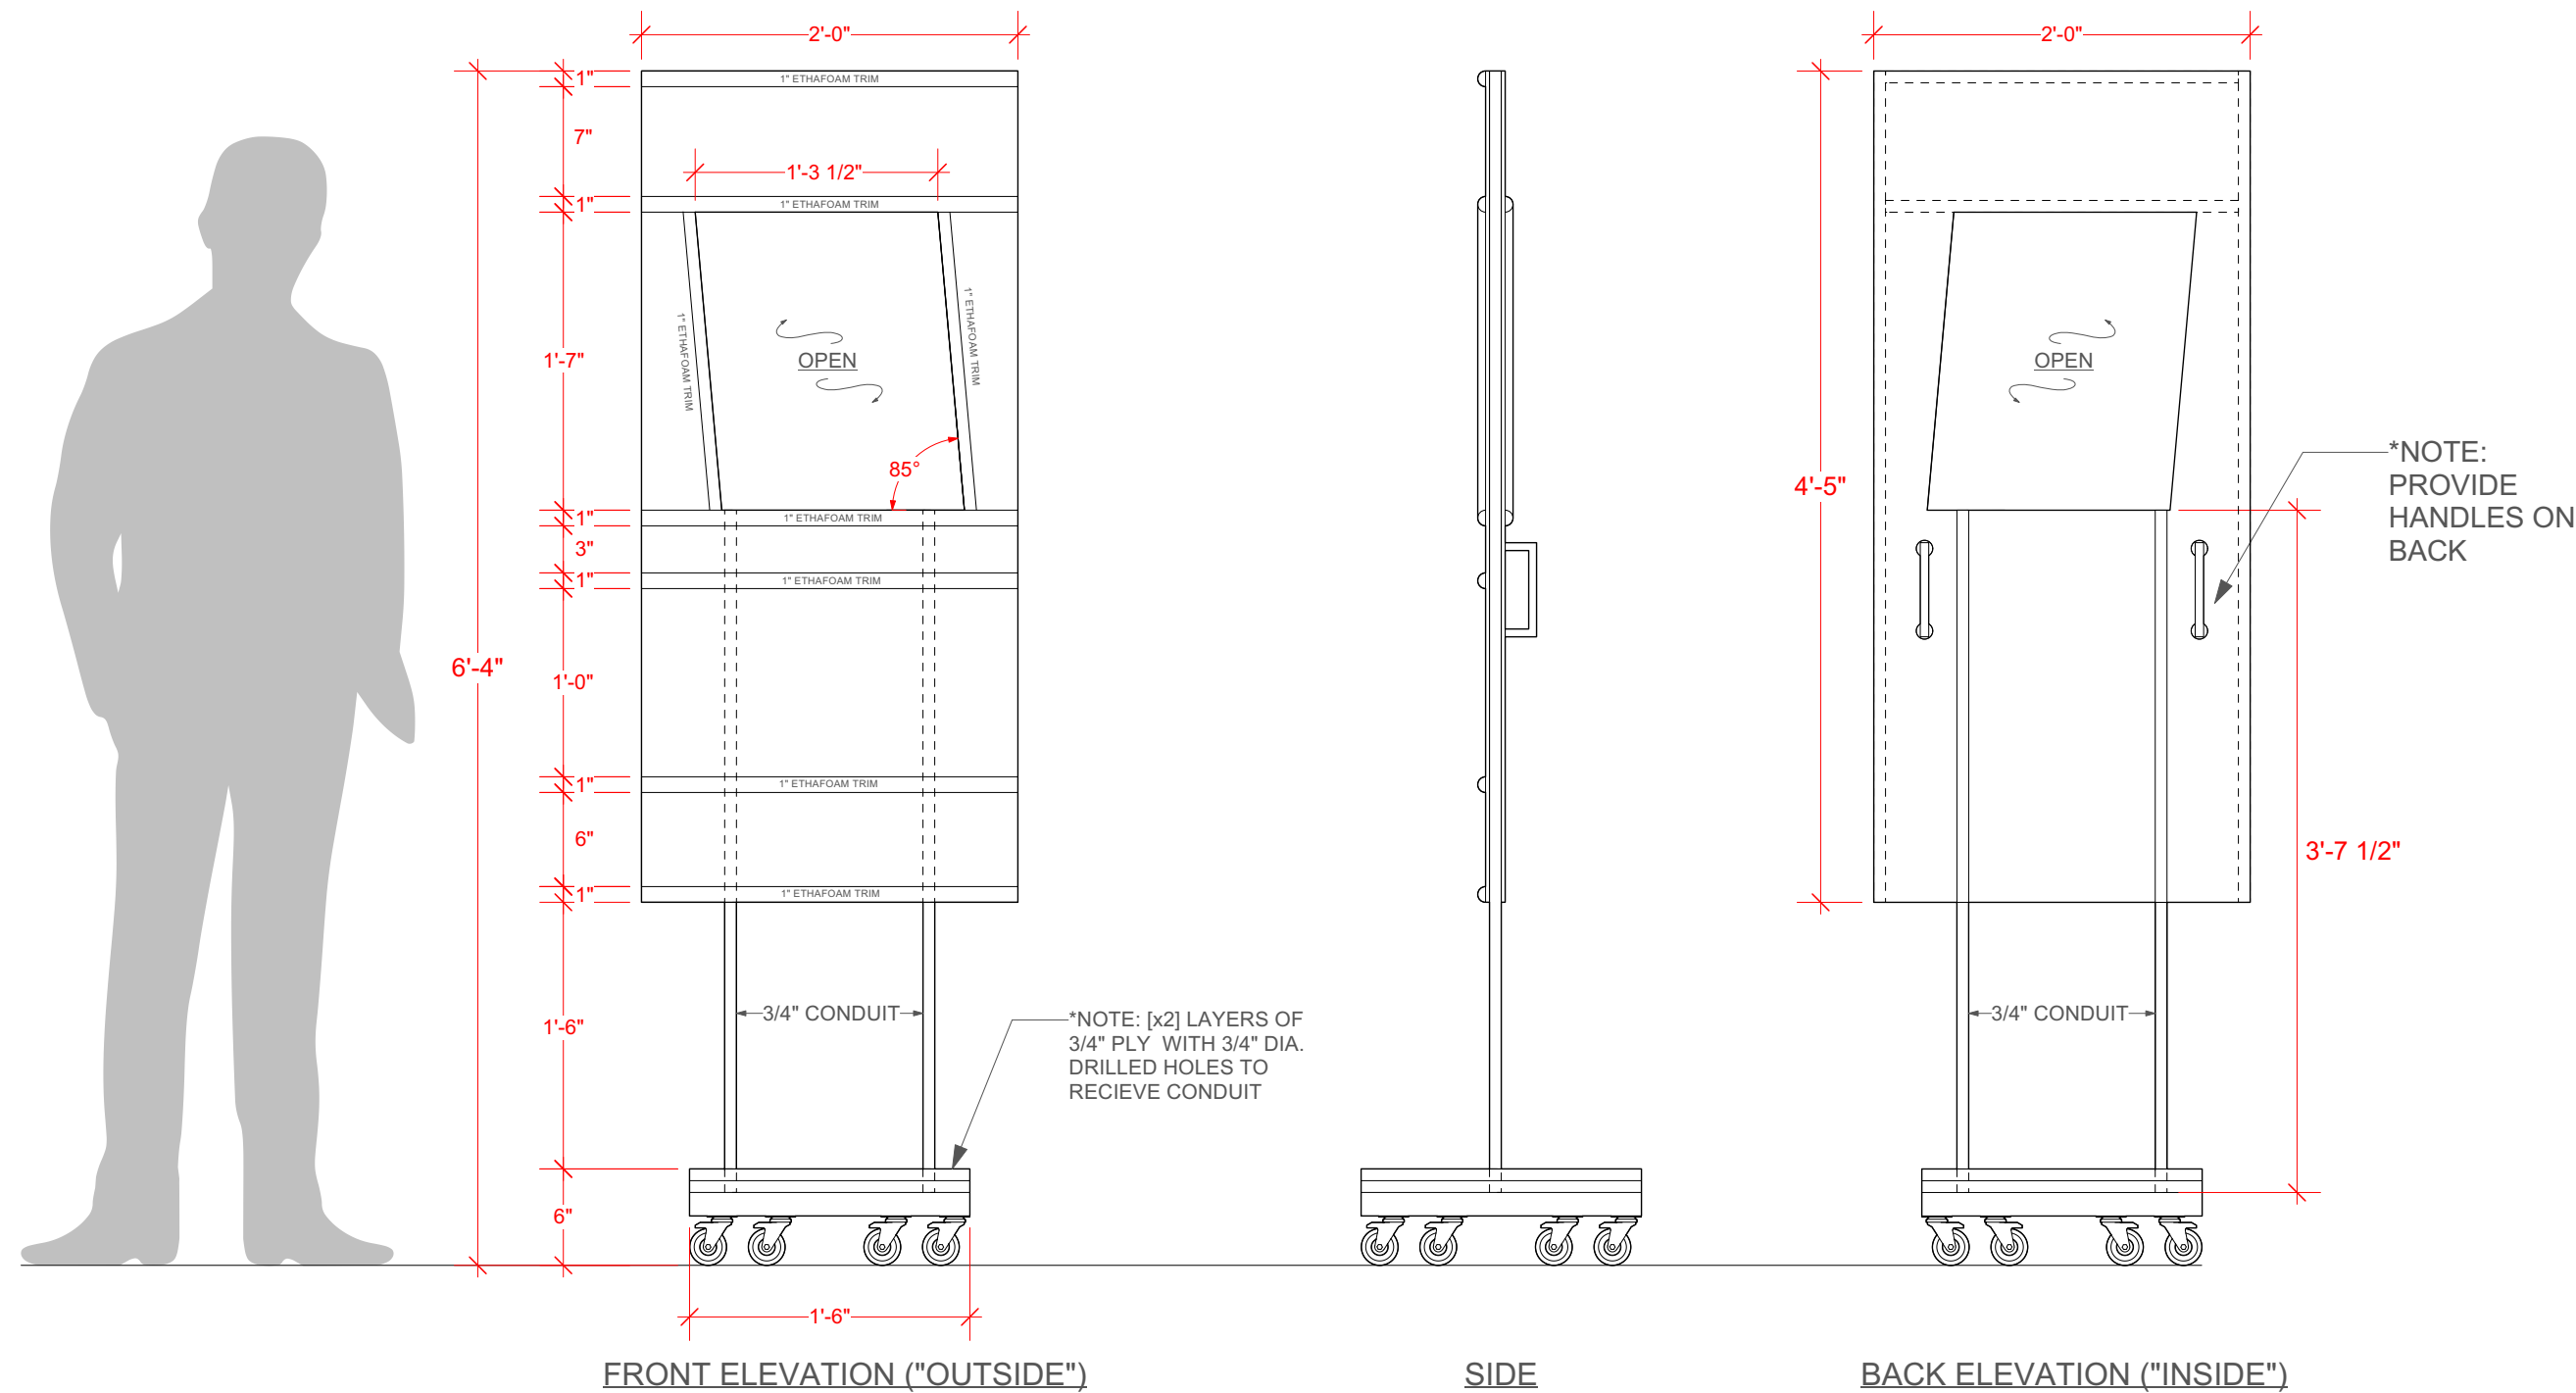

FRONT ELEVATION ("OUTSIDE")

SIDE


BACK ELEVATION ("INSIDE")

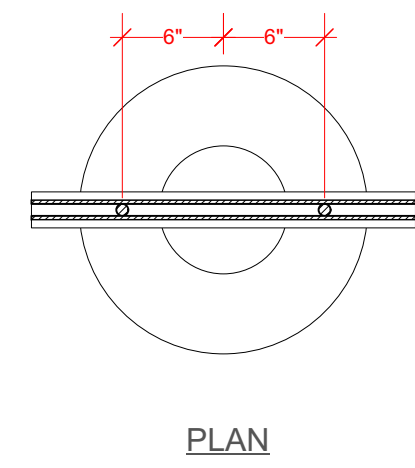

PLAN

1 BUS UNIT ELEVATION
Scale: 1" = 1'-0"


- NOTES:
1. CONDUIT TO BE HOME DEPOT. 3/4" METAL TUBING. SKU 203114
 2. RIG TWO 3/4" PLYWOOD DONUTS 18" DIA. WITH HOLES DRILLED TO RECIEVE CONDUIT
 3. MOUNT TO 7 EXISTING TRASHCAN DOLLIES. ORDER 5 ADDITIONAL FOR A TOTAL OF 12. ULINE. Model No. H-7928
 4. MOUNT 1/4" PLY TO FRONT AND BACK OF CONDUIT ARMATURE, SUPPORT WITH 1x1 FRAMING (SEE DRAWING 3).
 5. PROVIDE HANDLES ON INSIDE. HANDLES TO BE MCMASTER 4 3/4" ZINC-PLATED STEEL SKU 1646A18
 6. TRIM W/ 1" ETHAFOAM
 7. NOTE THAT ONLY FOUR UNITS TO HAVE WHEELWELL CUTOUTS [x2] FRONT AND [x2] REAR
 8. BUILD 12 UNITS.
 9. BUILD ONE MOCK-UP BEFORE BUILDING REST TO ENSURE CHOREOGRAPHIC NEEDS
 10. OUTSIDE TO BE PAINTED METALLIC SILVER W/ PAGEANT LOGO APPLIED VINYL LETTERS.
 11. INSIDE TO BE STENCILED WITH WALLPAPER PATTERN

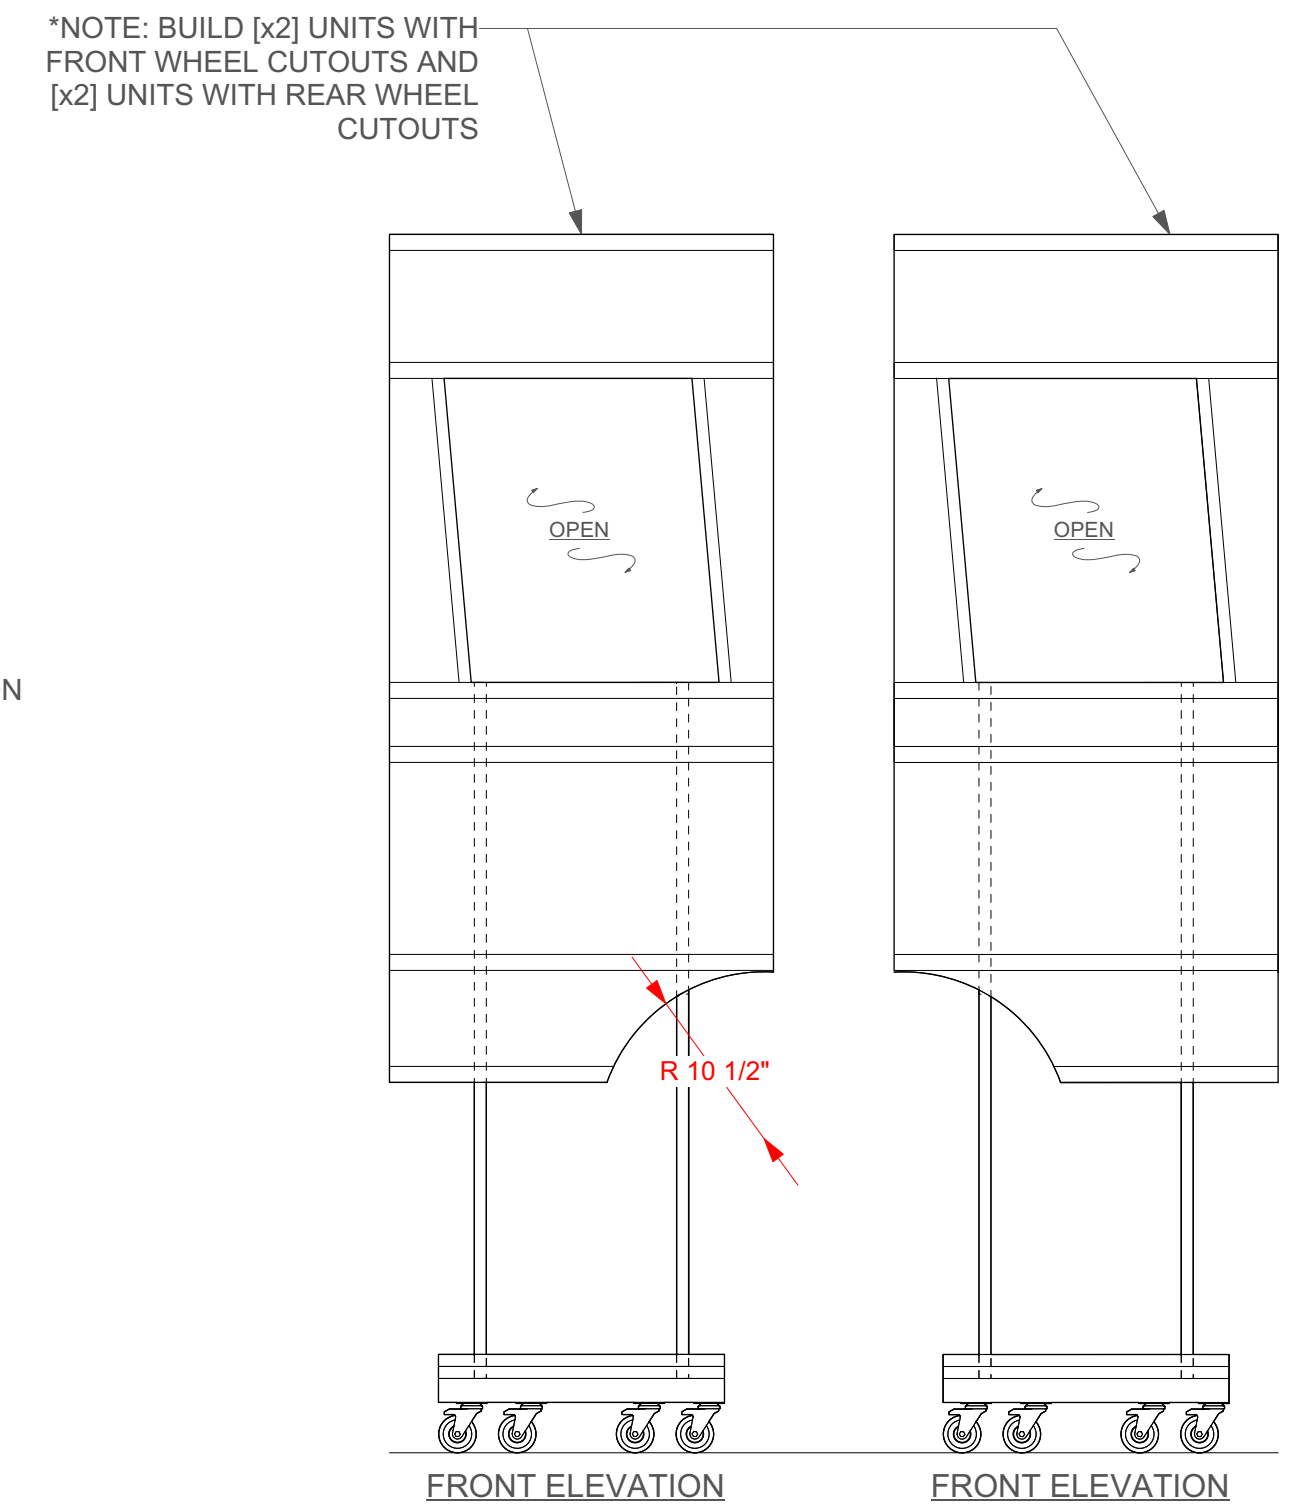

FRONT ELEVATION

FRONT ELEVATION

2 BUS WHEEL WELL CUTOUT UNIT ELEVATIONS
Scale: 1" = 1'-0"

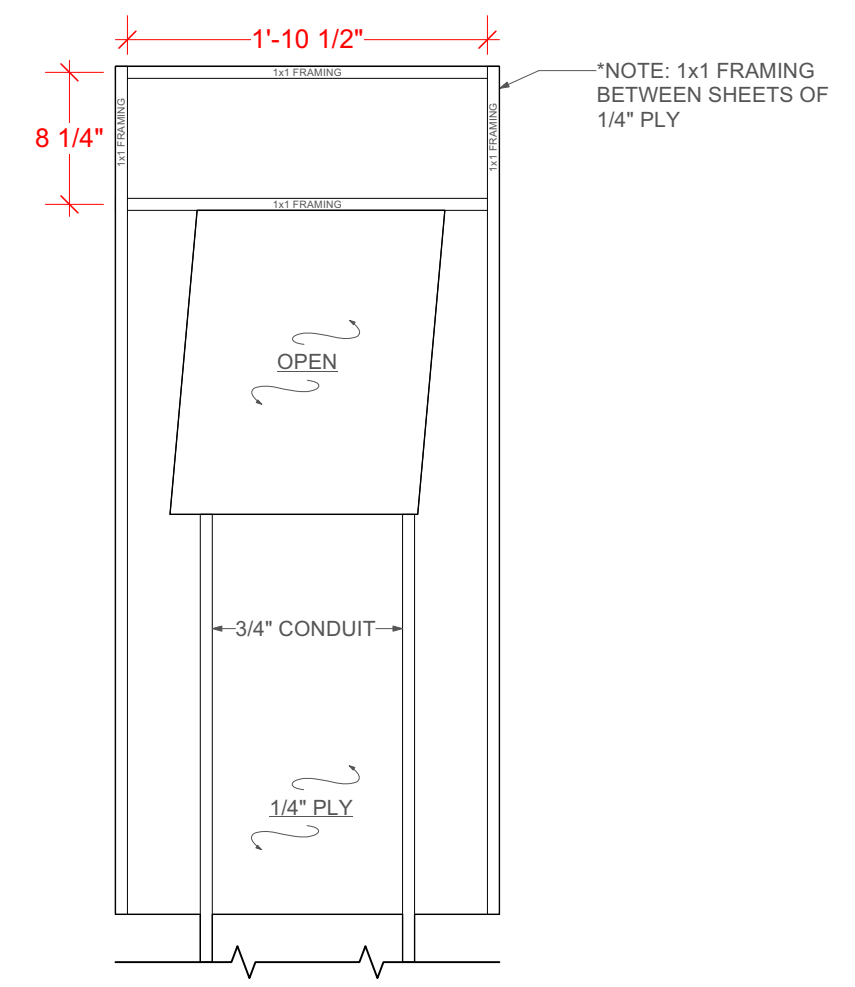

3 BUS UNIT INTERNAL STRUCTURE ELEVATION
Scale: 1" = 1'-0"

The Princeton Triangle Club
at the McCarter Theatre Presents
PAGEANT PENDING


Book, Music, and Lyrics
TRIANGLE WRITERS
WORKSHOP

Direction Sam Hayes
Choreography Taylor Gordon
Music Direction Pete Mills
Set Design Court Watson
Costume Design Stephanie Echevarria
Lighting Design Alex Slisher & Al Potter
Scenic Draughtsperson Jonas Harrison


BUS UNIT
Scale: 1" = 1'-0" (PRINTED 18" X 24")
1/2" = 1'-0" (PRINTED 11" X 17")
Draft Date: 10.7.24
Plate No.

3


of [13]

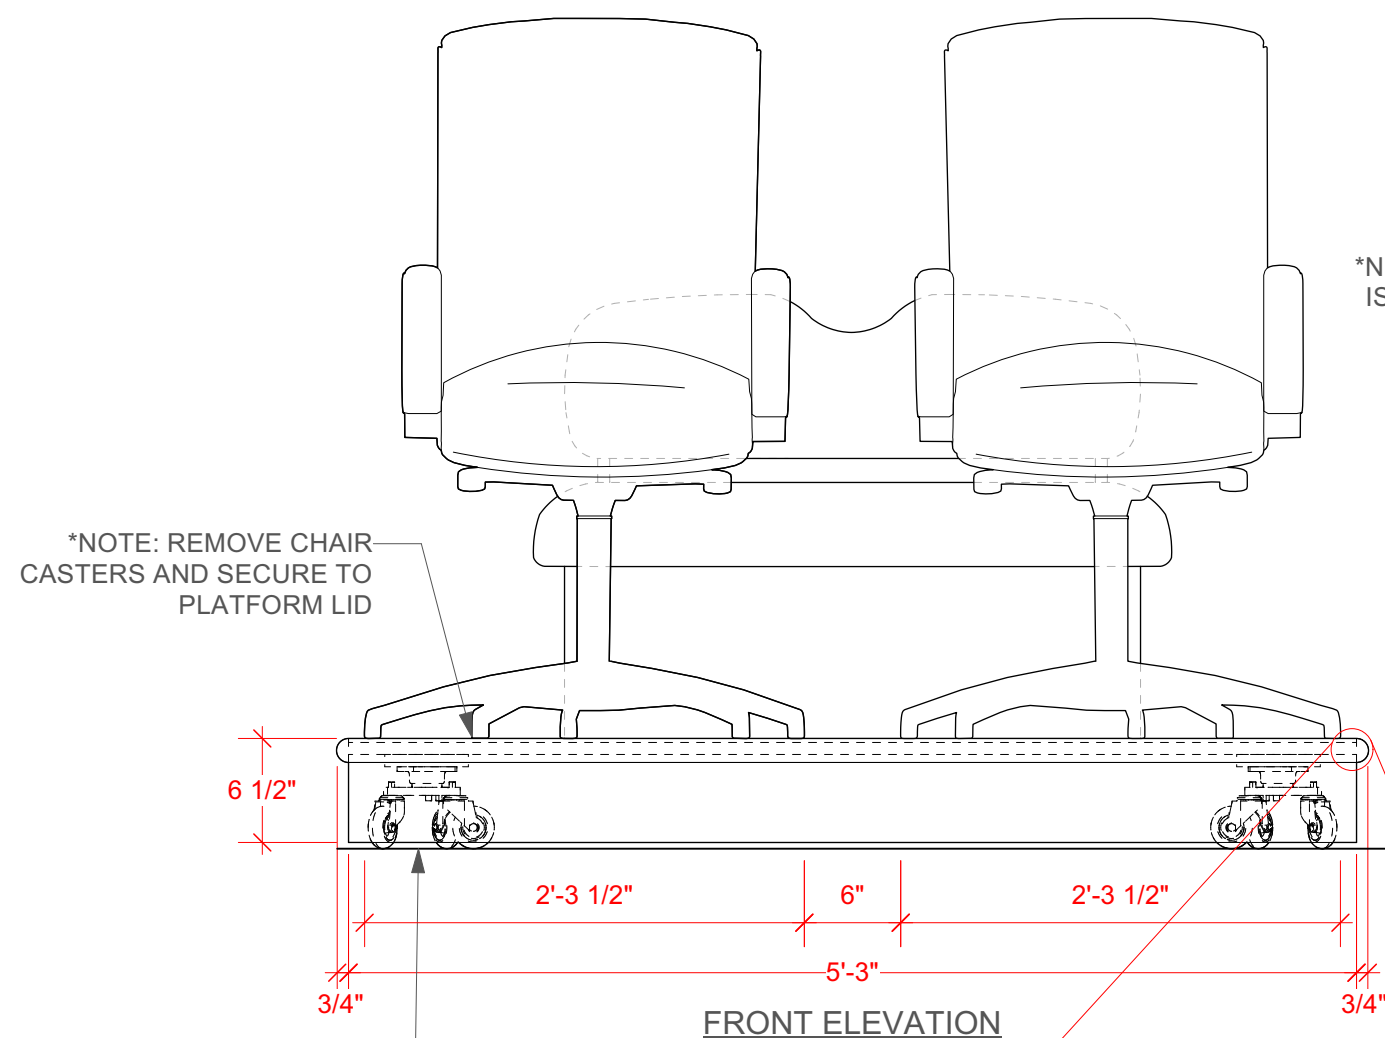

FRONT ELEVATION

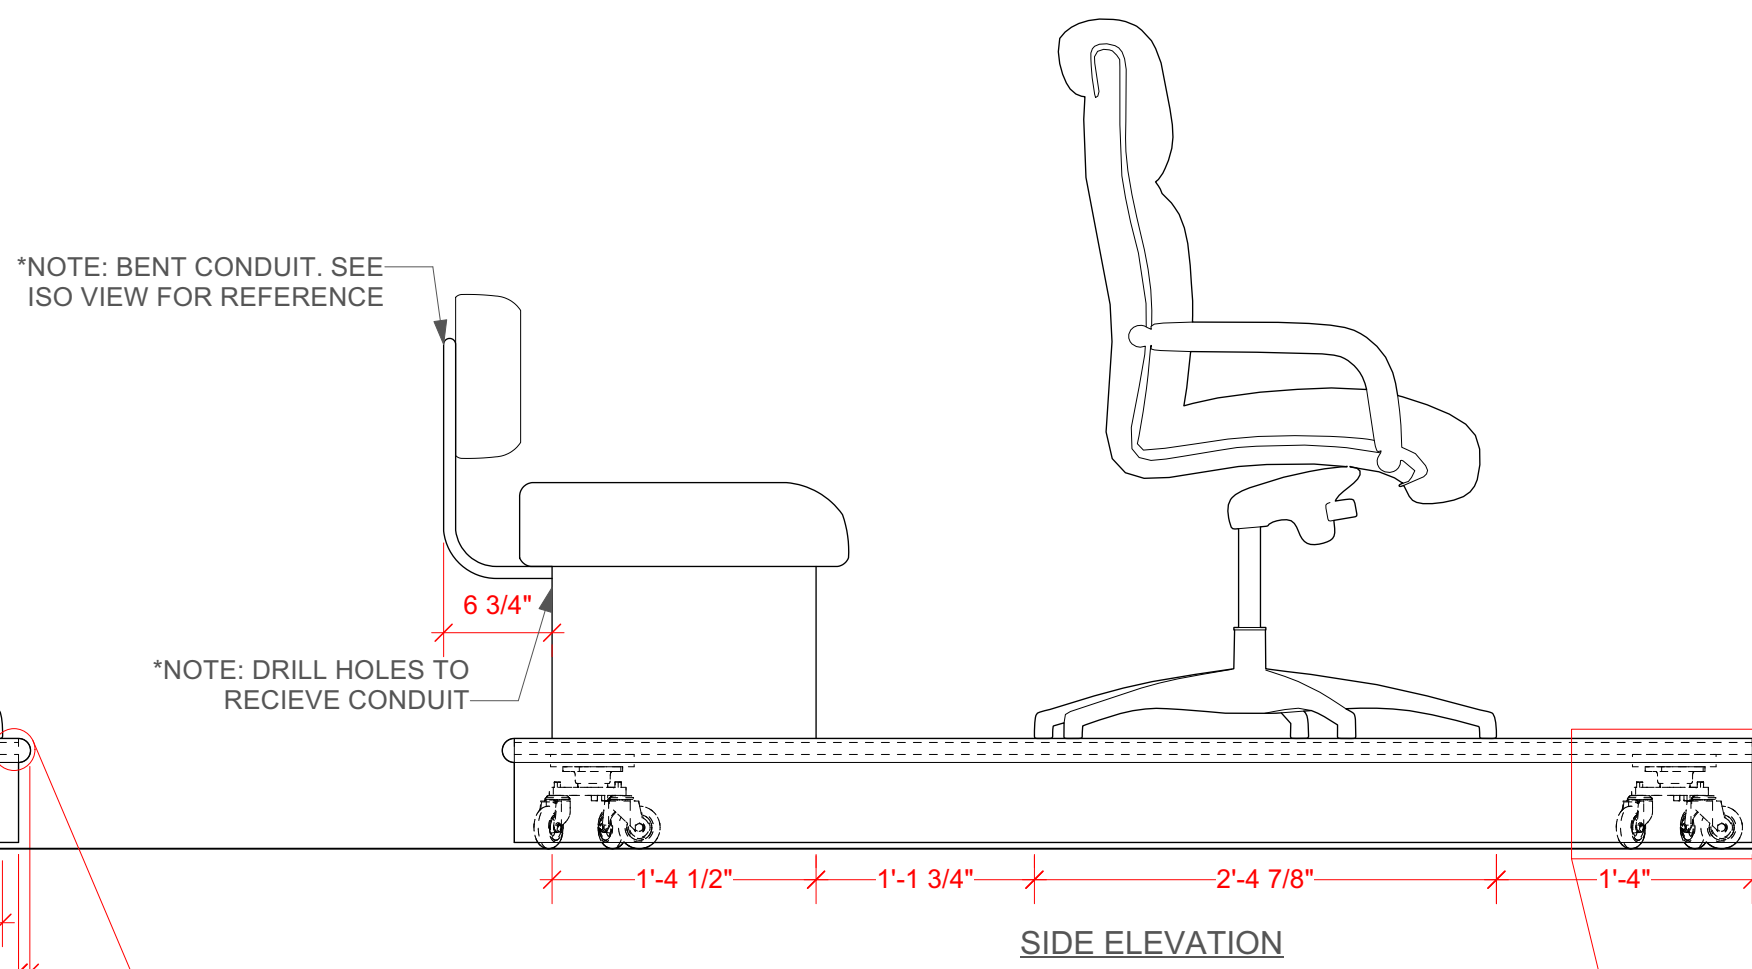


SIDE ELEVATION

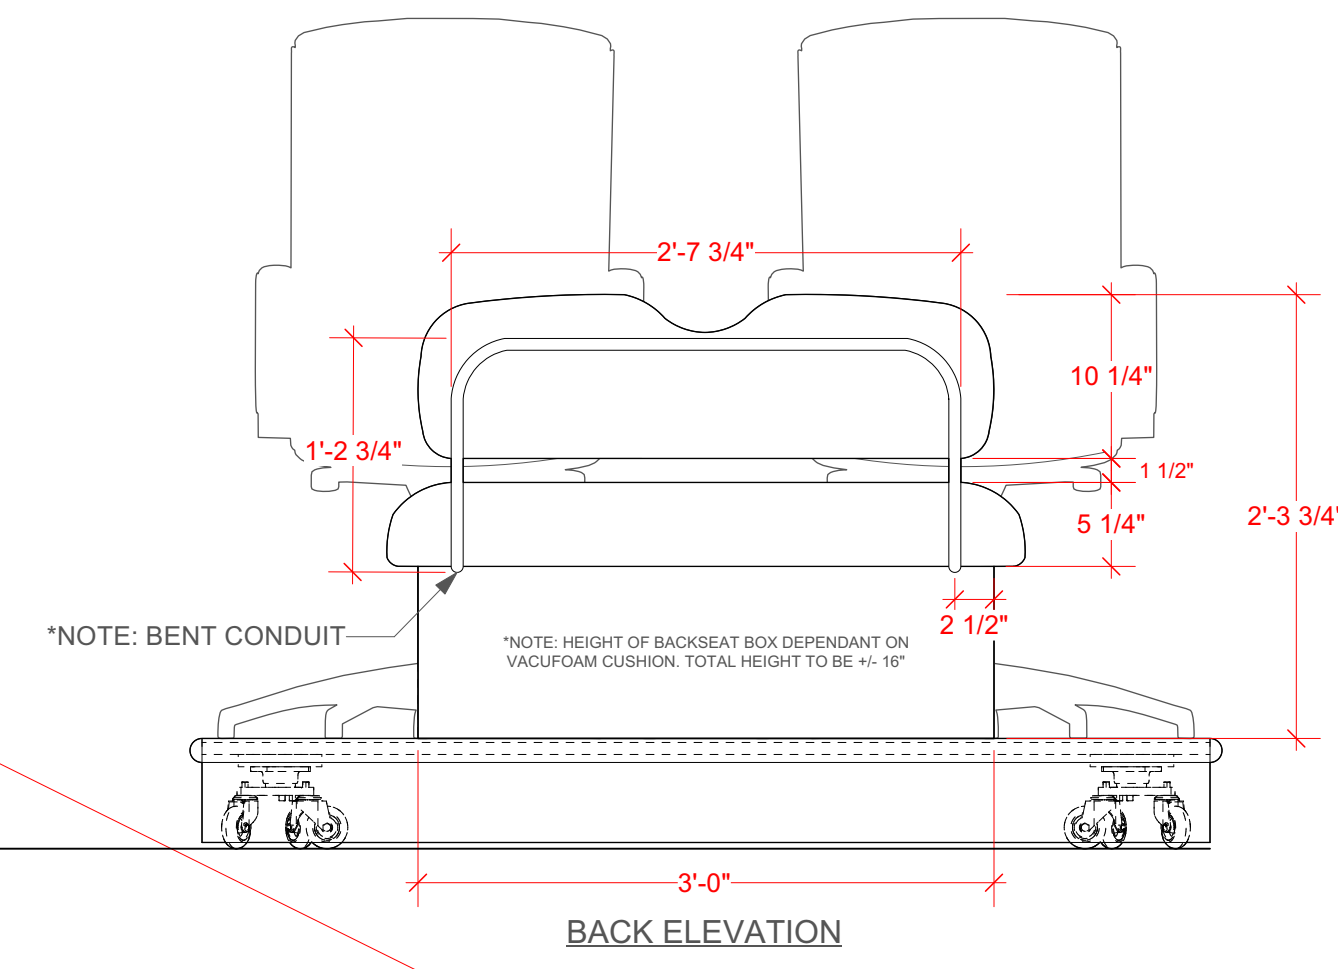


BACK ELEVATION


1 CAR UNIT ELEVATION
Scale: 1" = 1'-0"

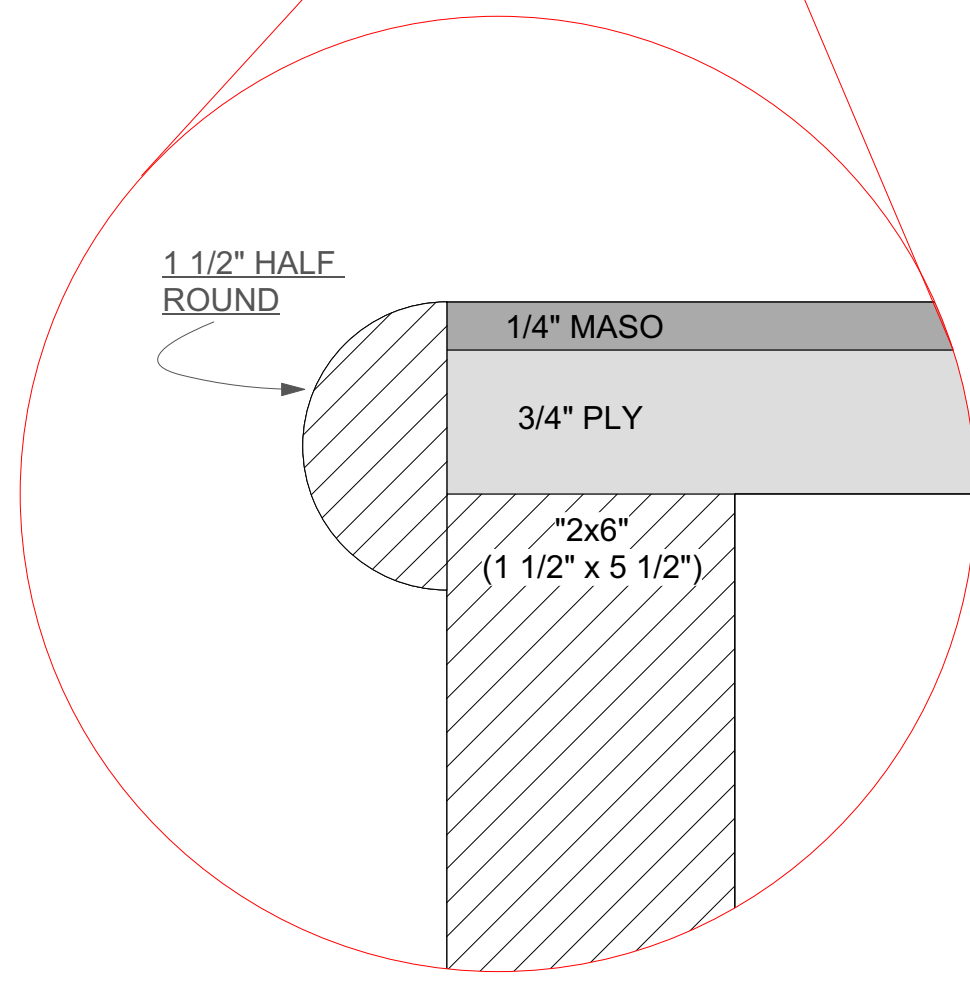


3 PLATFORM BUILD DETAIL
Scale: Actual Size

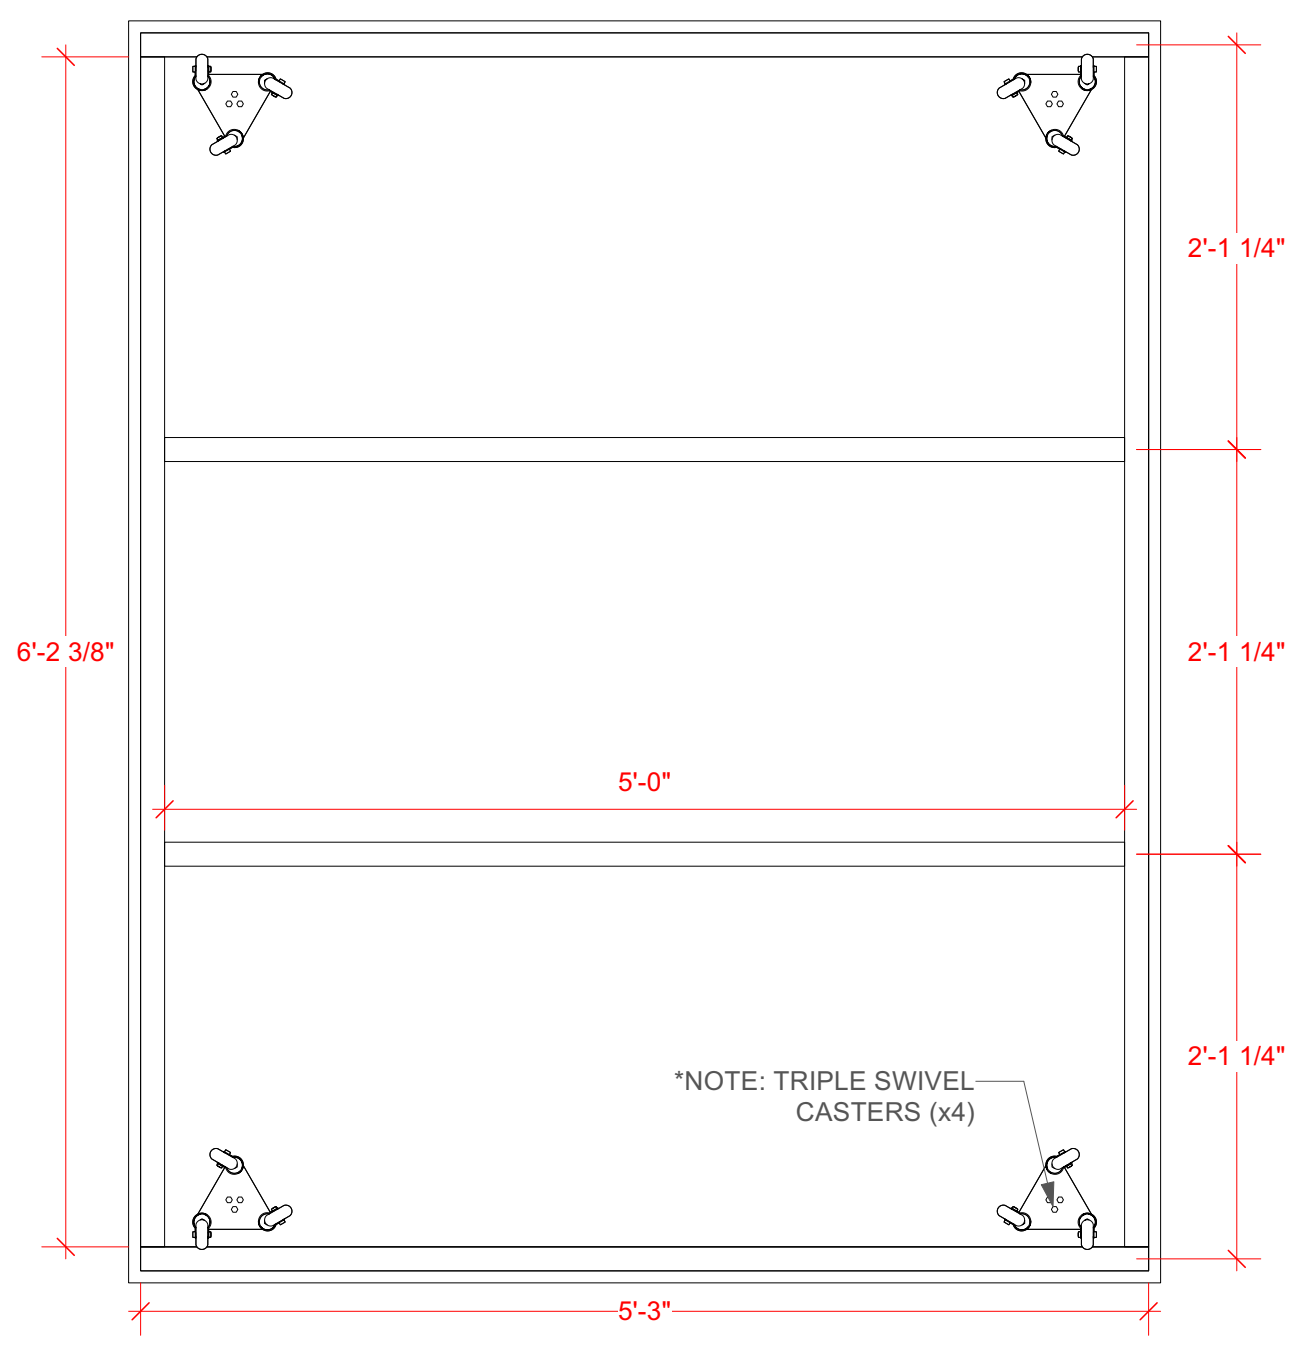

2 [CAR] PLATFORM UNDERSIDE ELEVATION
Scale: 1" = 1'-0"

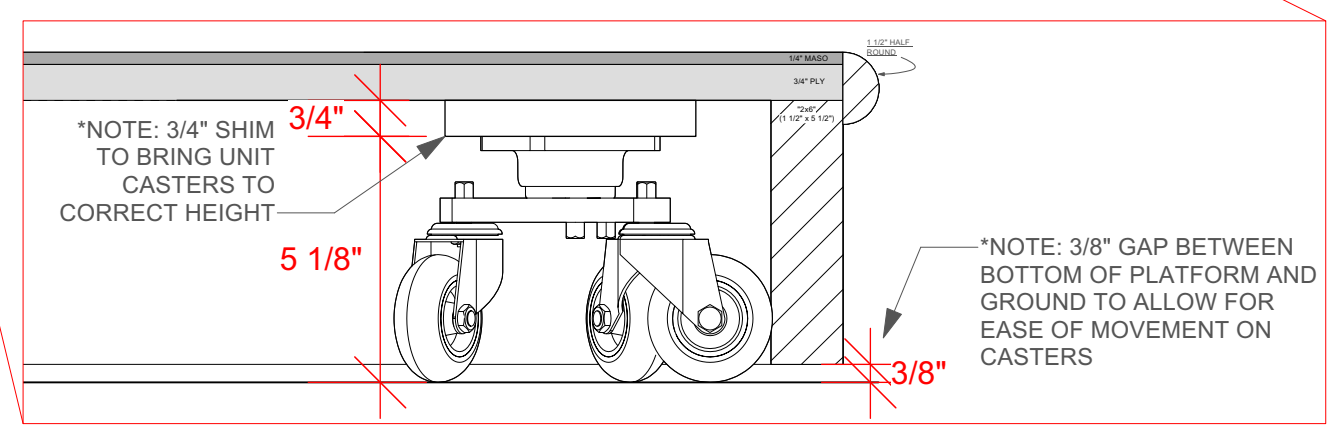

5 CASTER BUILD DETAIL
Scale: 3" = 1'-0"

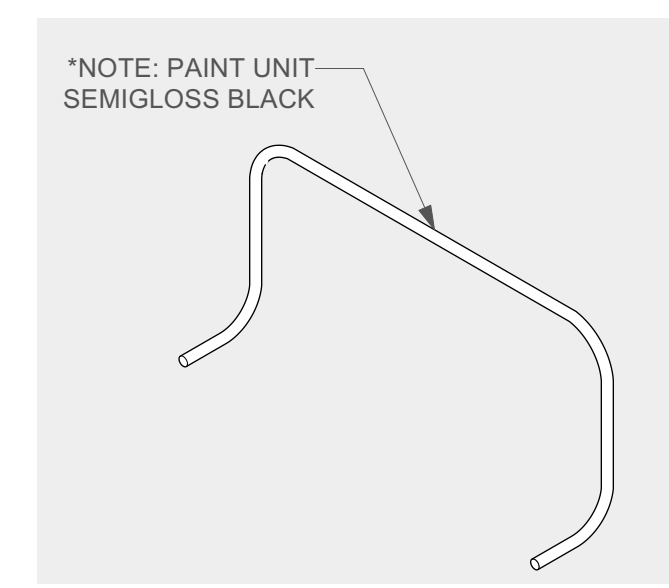

4 BENT CONDUIT ISO VIEW
Scale: 1" = 1'-0"

- NOTES:
1. BACK SEAT: GOLFCARTSEATS.COM BLACK EZGO TXT FRONT SEAT COMPLETE VAC-FORM SET
 2. FRONT SEATS: STAPLES.COM RECLINE BLACK KELBURNE LUXURA ERGONOMIC EXECUTIVE CHAIR. REMOVE CHAIR CASTERS.
 3. MOULDING: HOME DEPOT. 1-1/2" x 3/4" OAK SKU 1002502784
 4. ADD BENT CONDUIT FOR BACK SEAT.
 5. PROVIDE FOUR TRIPLE-SWIVEL CASTERS. MCMMASTER.COM SKU 83485T17 AT \$186/EACH, BUDGET PERMITTING

The Princeton Triangle Club
at the McCarter Theatre Presents
PAGEANT PENDING


Book, Music, and Lyrics TRIANGLE WRITERS WORKSHOP

Direction Sam Hayes
Choreography Taylor Gordon
Music Direction Pete Mills
Set Design Court Watson
Costume Design Stephanie Echevarria
Lighting Design Alex Slisher & Al Potter
Scenic Draughtsperson Jonas Harrison

CAR UNIT
Scale: 1" = 1'-0" (PRINTED 18" X 24")
1/2" = 1'-0" (PRINTED 11" X 17")
Draft Date: 10.7.24
Plate No.


4

of [13]

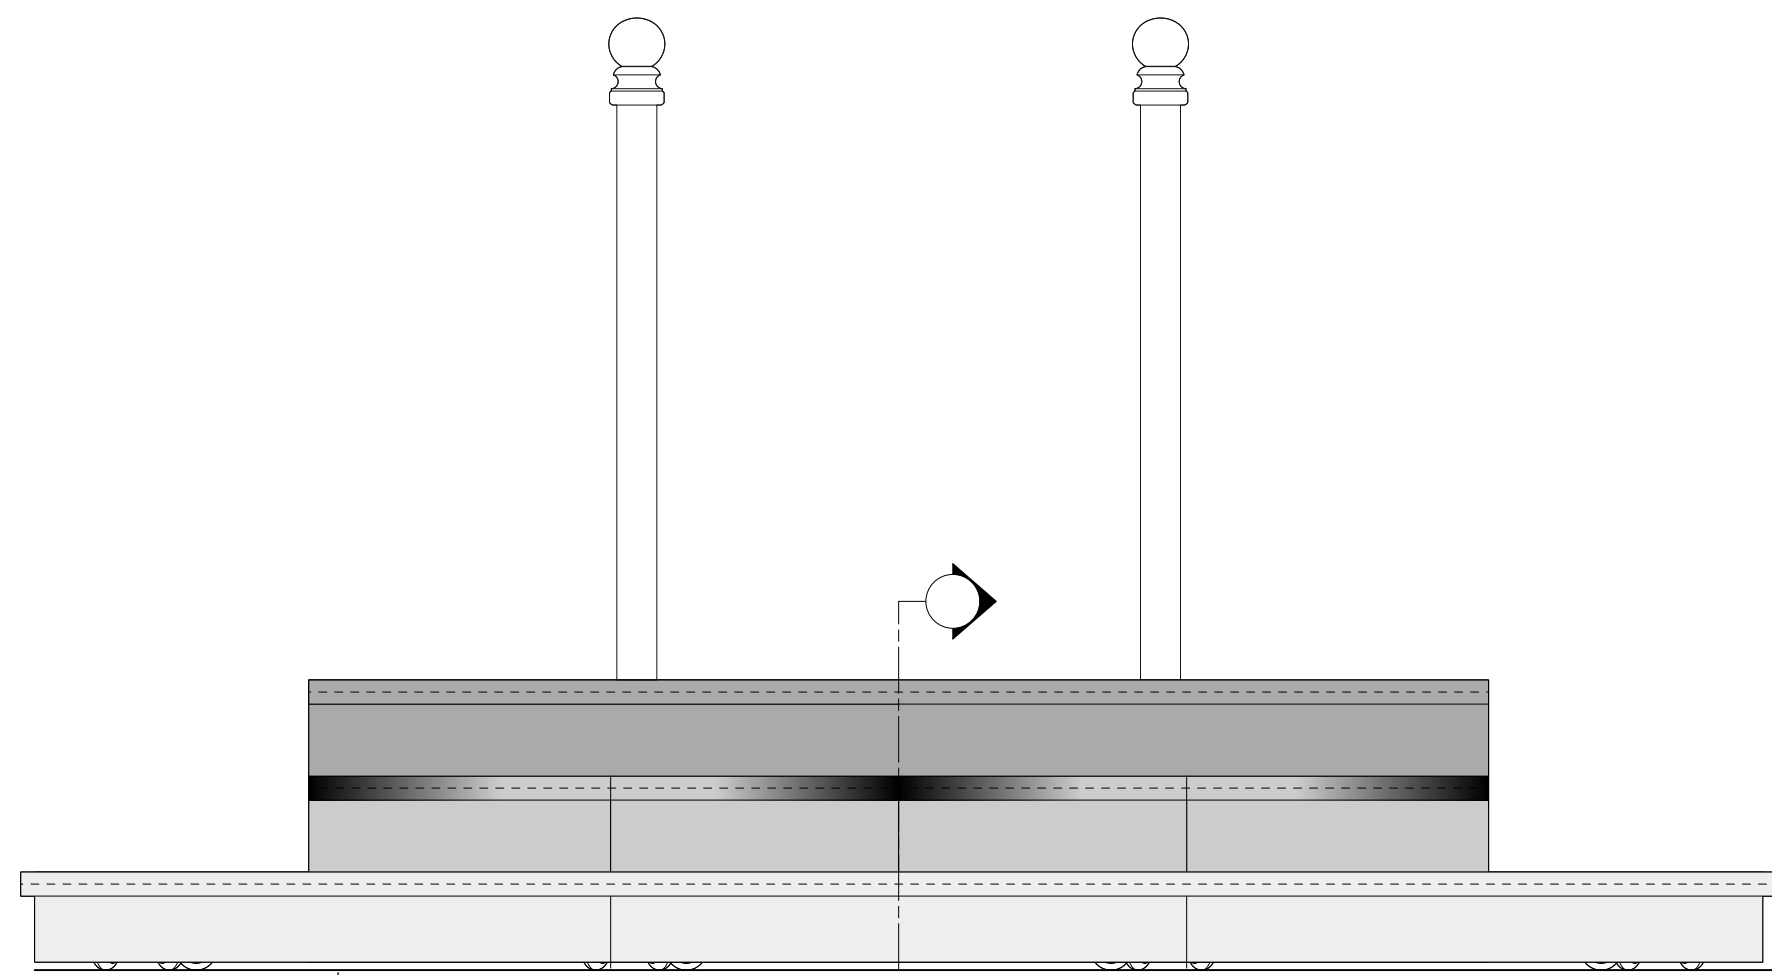


*NOTE: 3/8" GAP BETWEEN BOTTOM OF PLATFORM FACING AND GROUND TO ALLOW FOR EASE OF MOVEMENT ON CASTERS


FRONT ELEVATION

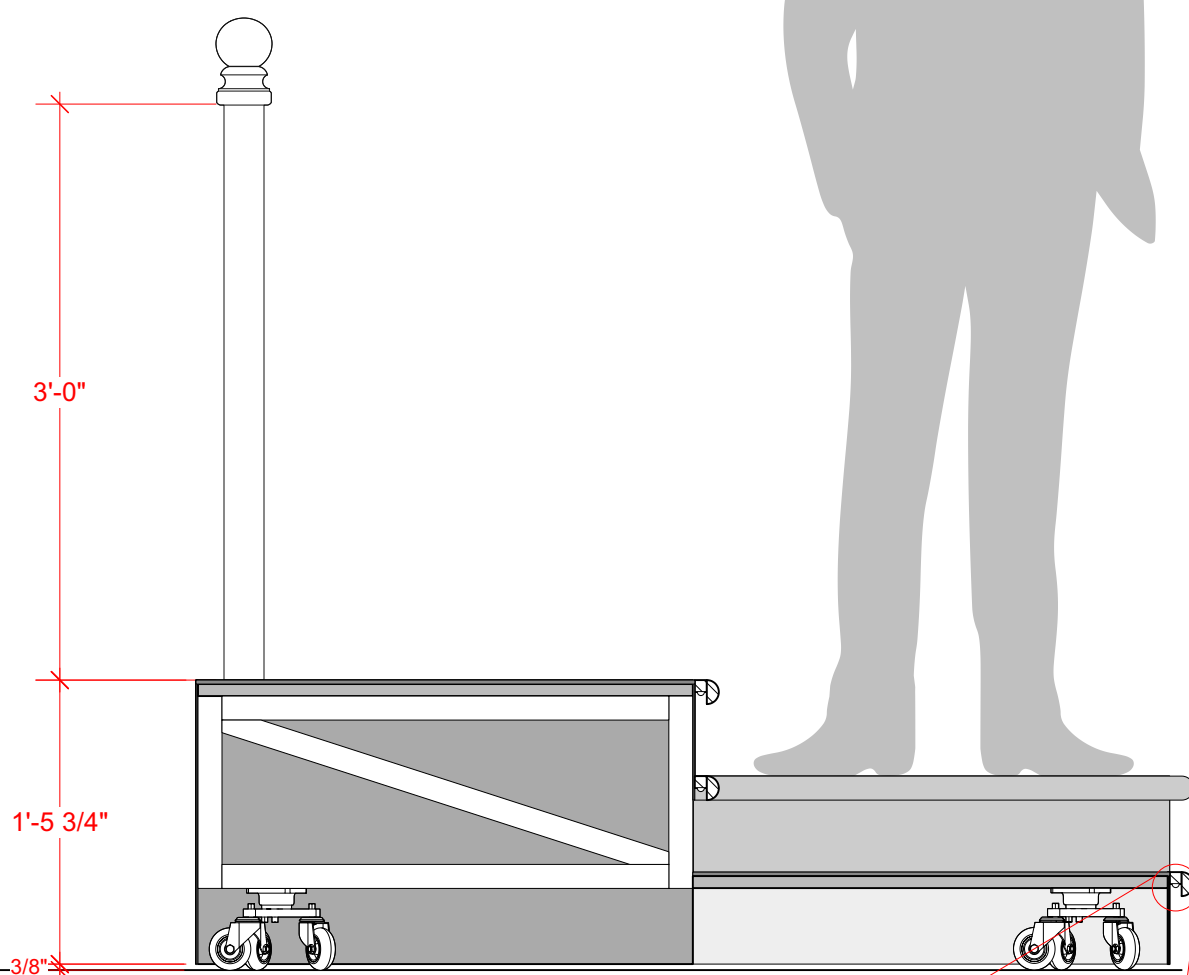

SECTION

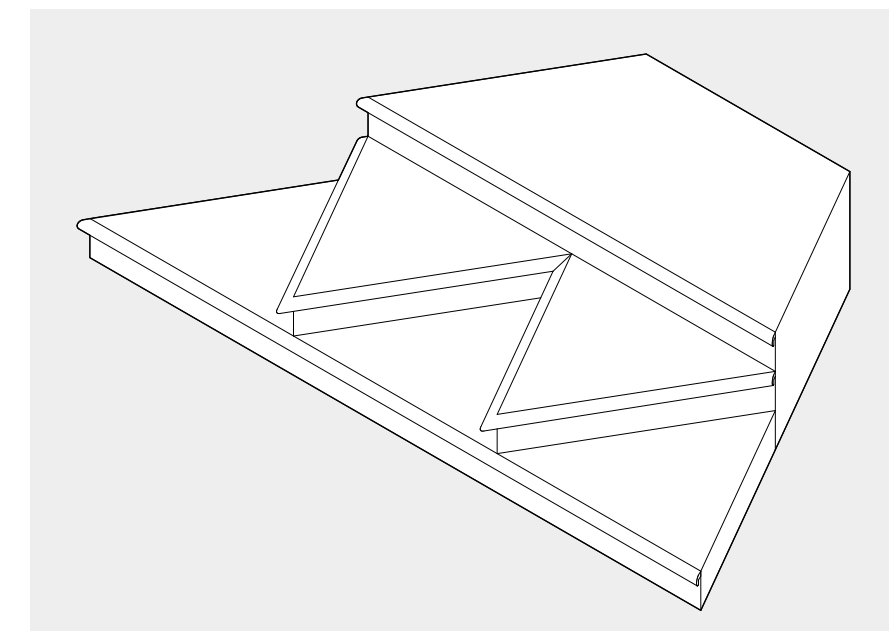


2 CENTER PLATFORM ISO VIEW
Scale: 1/2" = 1'-0"

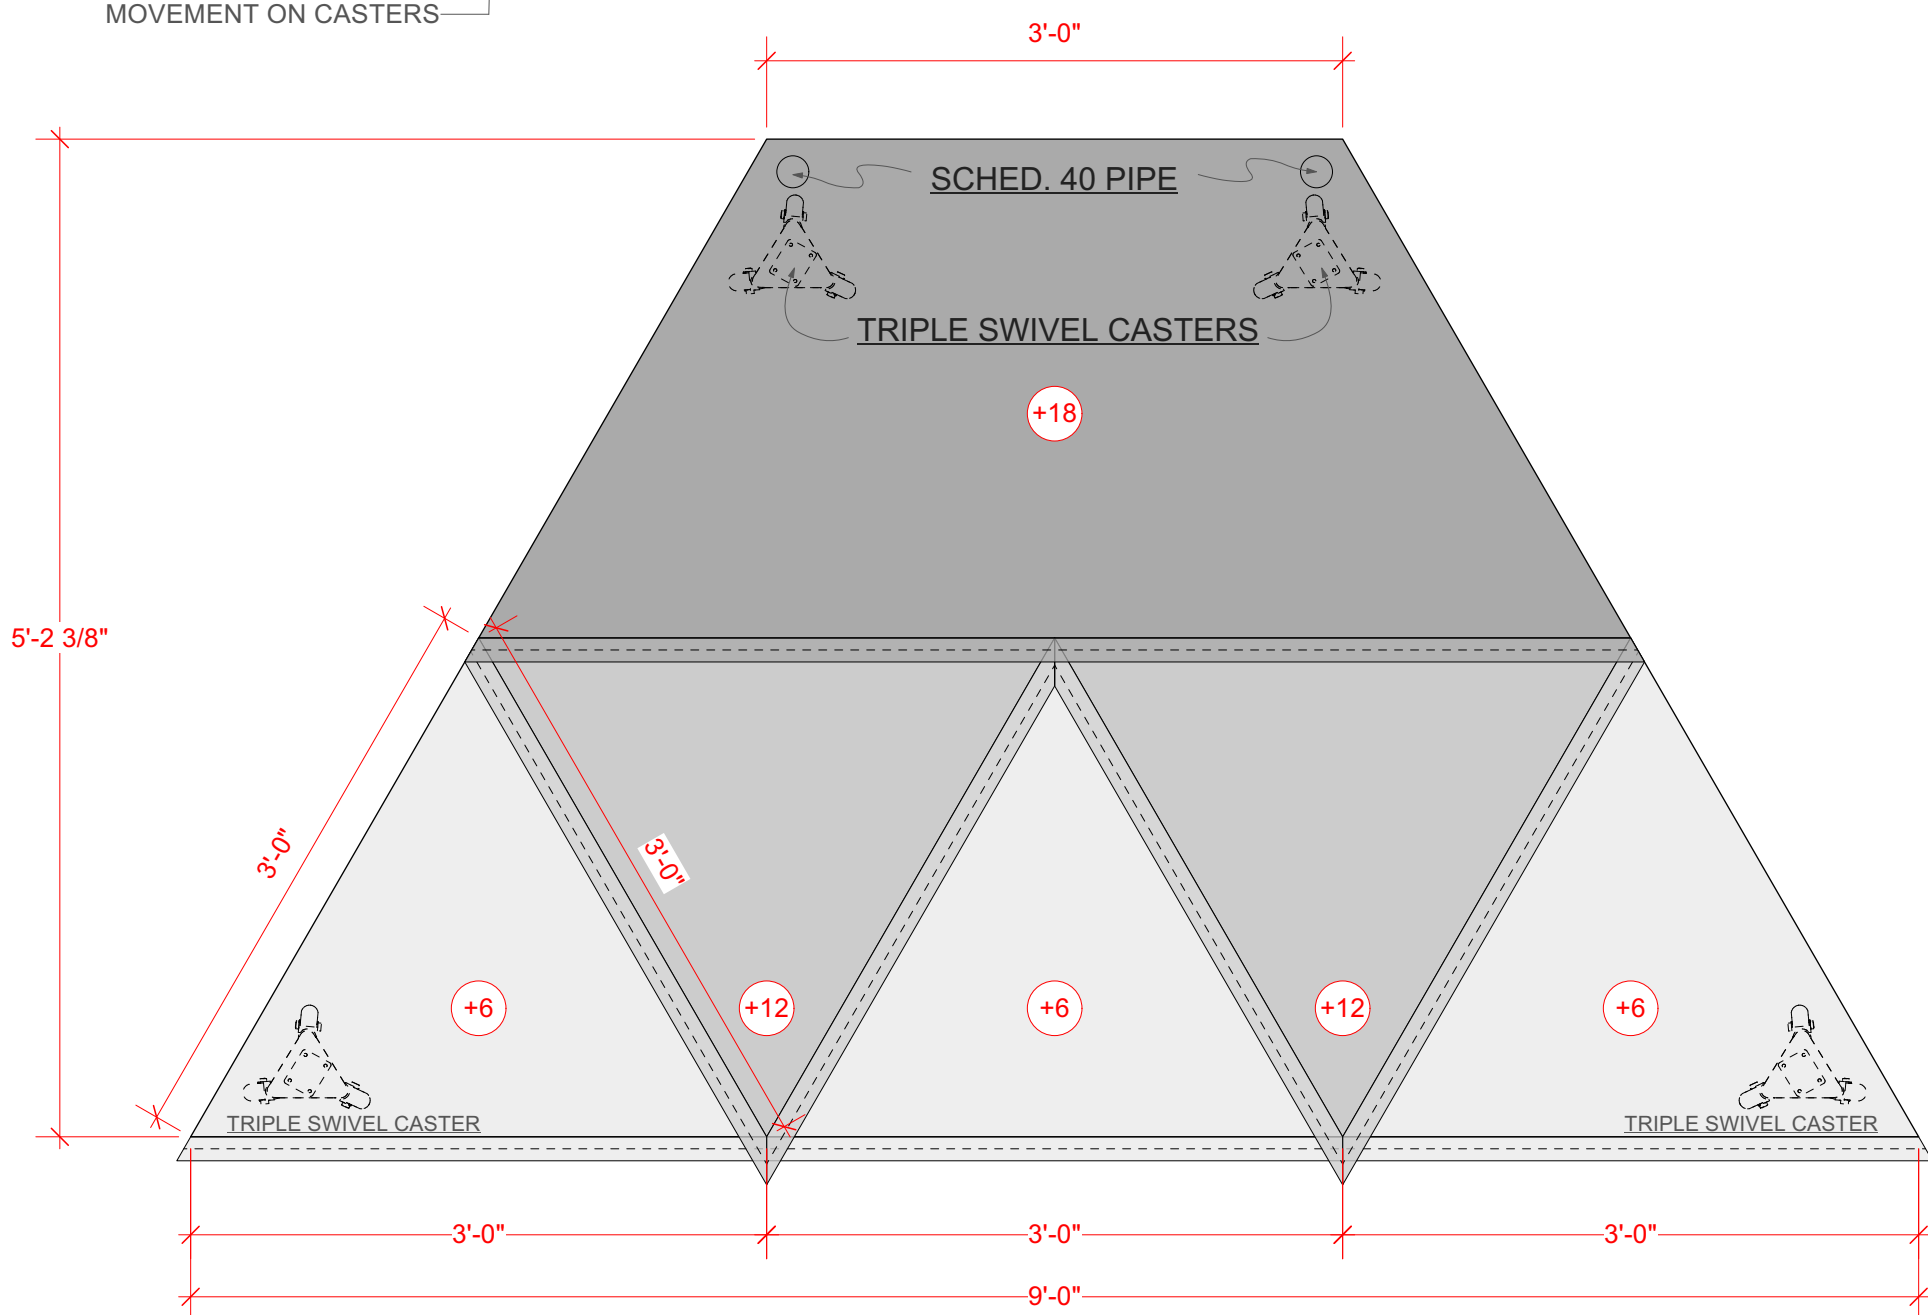

PLAN

1 CENTER PLATFORM ELEVATION
Scale: 1" = 1'-0"

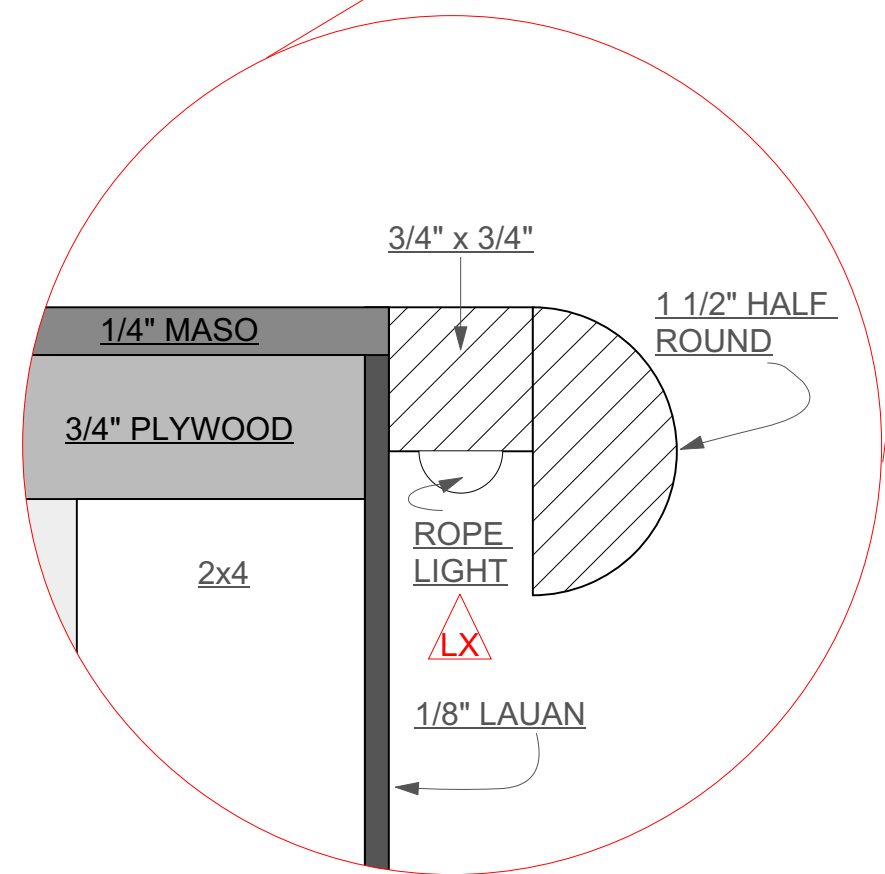

3 PLATFORM BUILD DETAIL
Scale: Actual Size

NOTES:


1. MOULDING: HOME DEPOT 1-1/2" x 3/4" OAK SKU 100250278
2. PROVIDE FOUR BRAKES ON SIDES
3. CIRCUIT EACH LEVEL AS PER UNIT BREAKLINES. EACH UNIT TO BE ONE CHANNEL. CONFIRM WITH LIGHTING DESIGNERS
4. POST CAPS TO BE HOMEDEPOT PROTECTYTE POST CAP FINIAL SKU 1004823855
5. PROVIDE FOUR TRIPLE-SWIVEL CASTERS. MCMASTER.COM SKU 83485T17 AT \$186/EACH, BUDGET PERMITTING

The Princeton Triangle Club
at the McCarter Theatre Presents
PAGEANT PENDING

Book, Music, and Lyrics
TRIANGLE WRITERS
WORKSHOP

Direction Sam Hayes
Choreography Taylor Gordon
Music Direction Pete Mills
Set Design Court Watson
Costume Design Stephanie Echevarria
Lighting Design Alex Slisher & Al Potter
Scenic Draughtsperson Jonas Harrison


CENTER PLATFORM
Scale: 1" = 1'-0" (PRINTED 18" X 24")
1/2" = 1'-0" (PRINTED 11" X 17")
Draft Date: 10.7.24
Plate No.

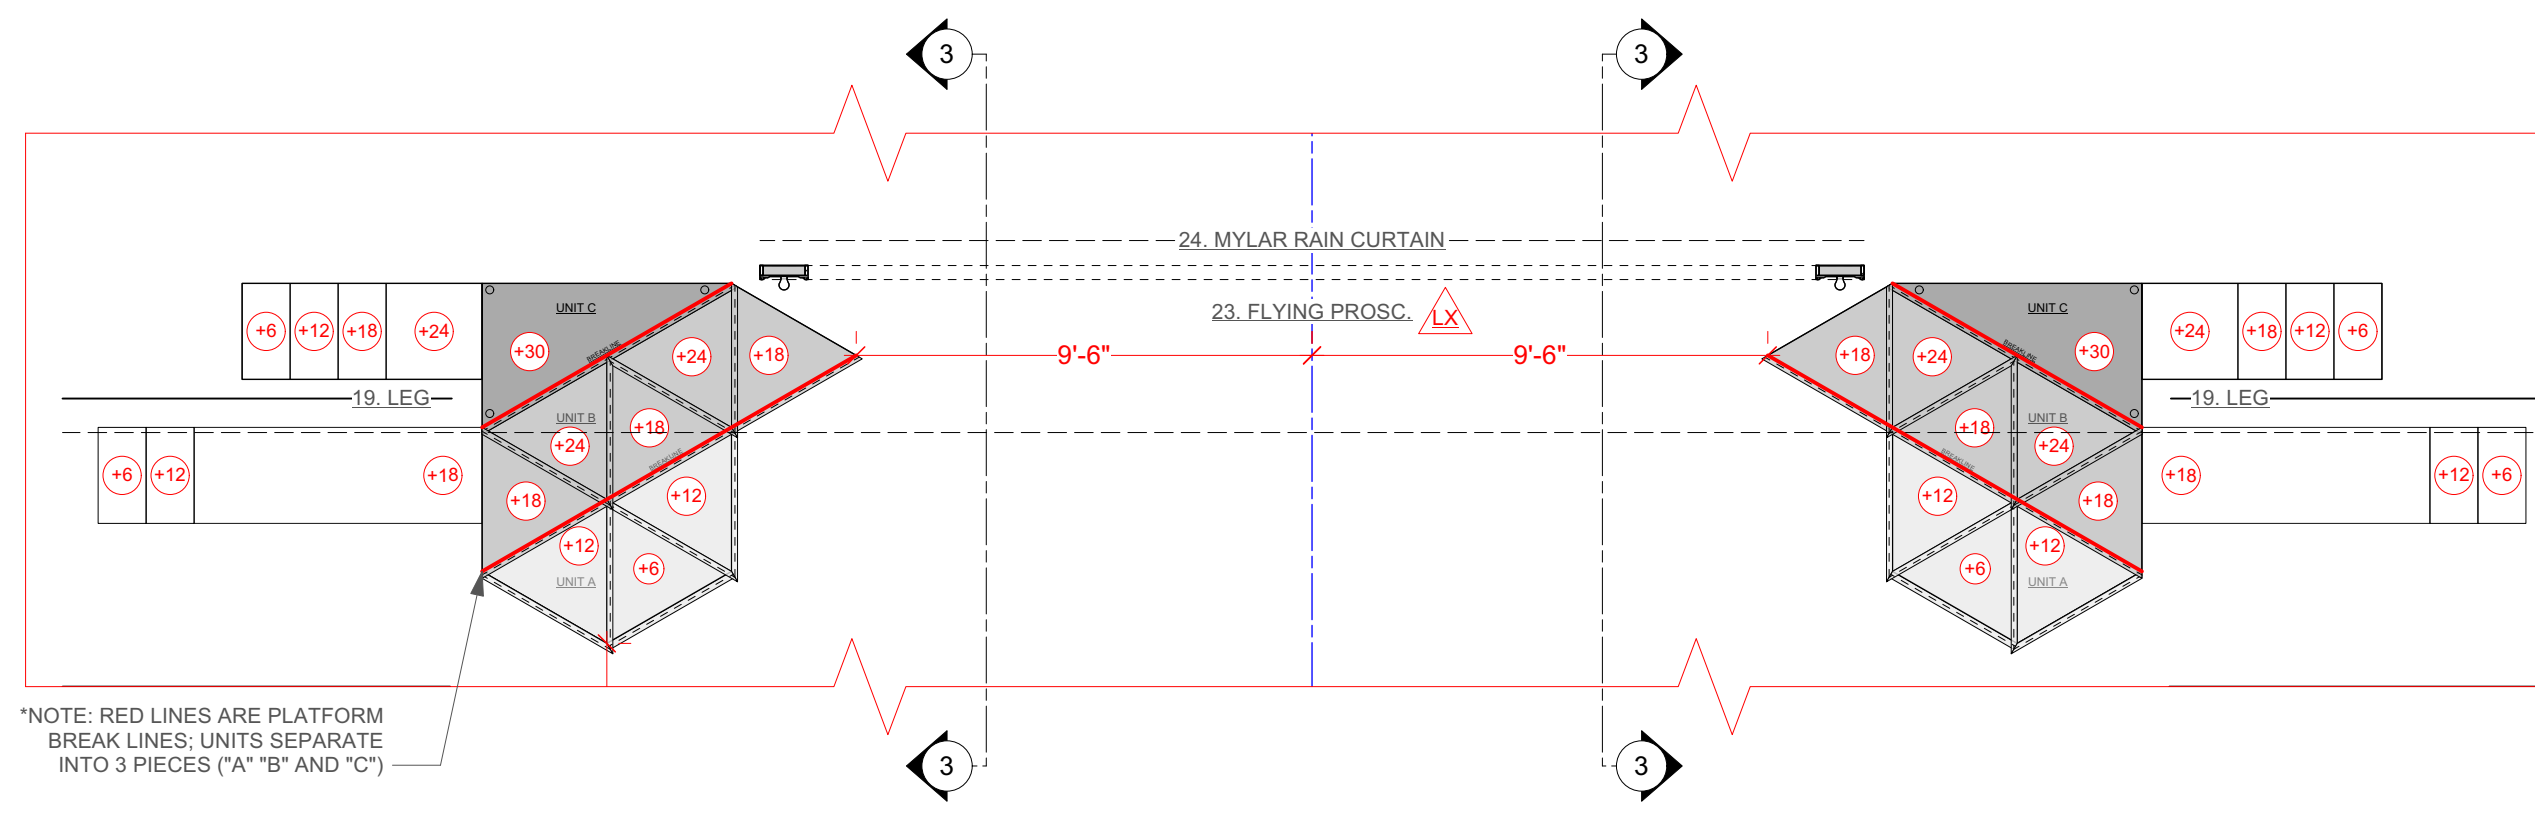


NOTES:

1. MOULDING: HOME DEPOT 1-1/2" x 3/4" OAK SKU 100250278
2. BUILD IN THREE UNITS (SHADED "A" "B" "C") AND WIRE SEPARATELY
3. CIRCUIT EACH LEVEL AS PER UNIT BREAKLINES. EACH UNIT TO BE ONE CHANNEL. CONFIRM WITH LIGHTING DESIGNERS

1 **SL & SR PLATFORMS: GROUNDPLAN PLACEMENT**
Scale: 1/4" = 1'-0"

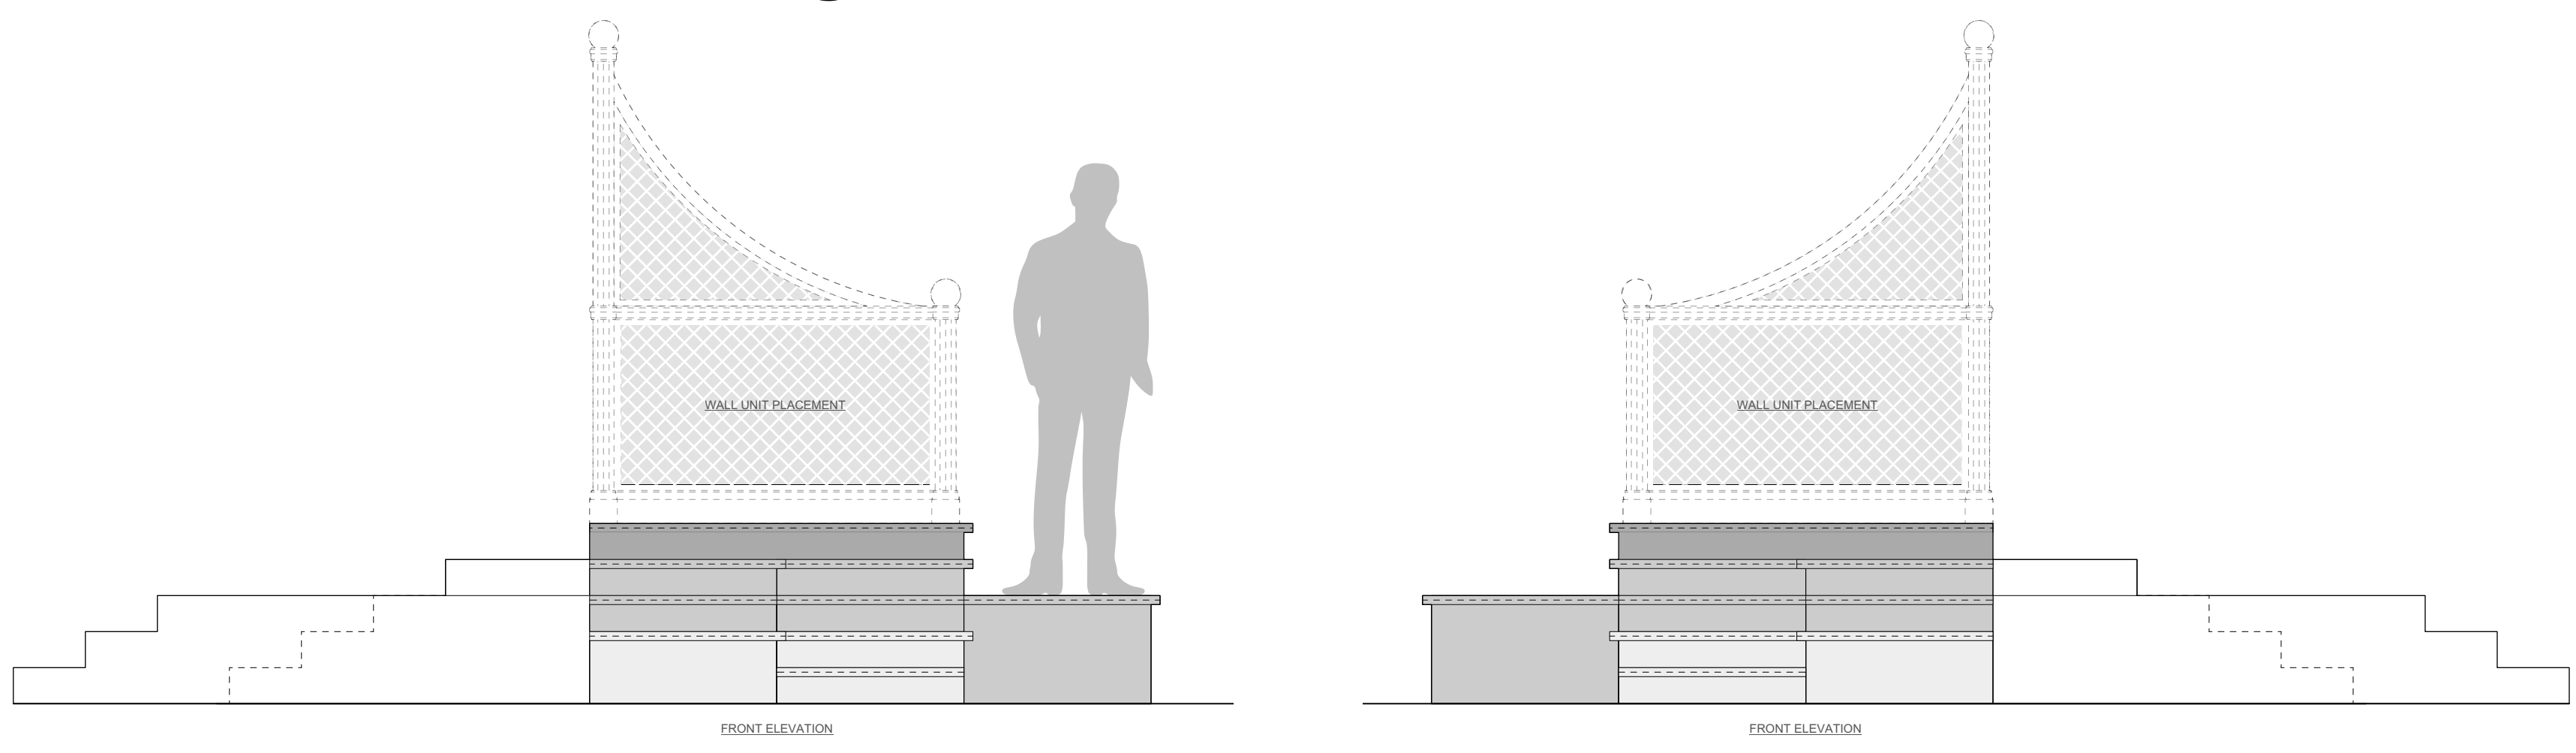

2 **SL & SR PLATFORMS: FRONT ELEVATION**
Scale: 1/2" = 1'-0"

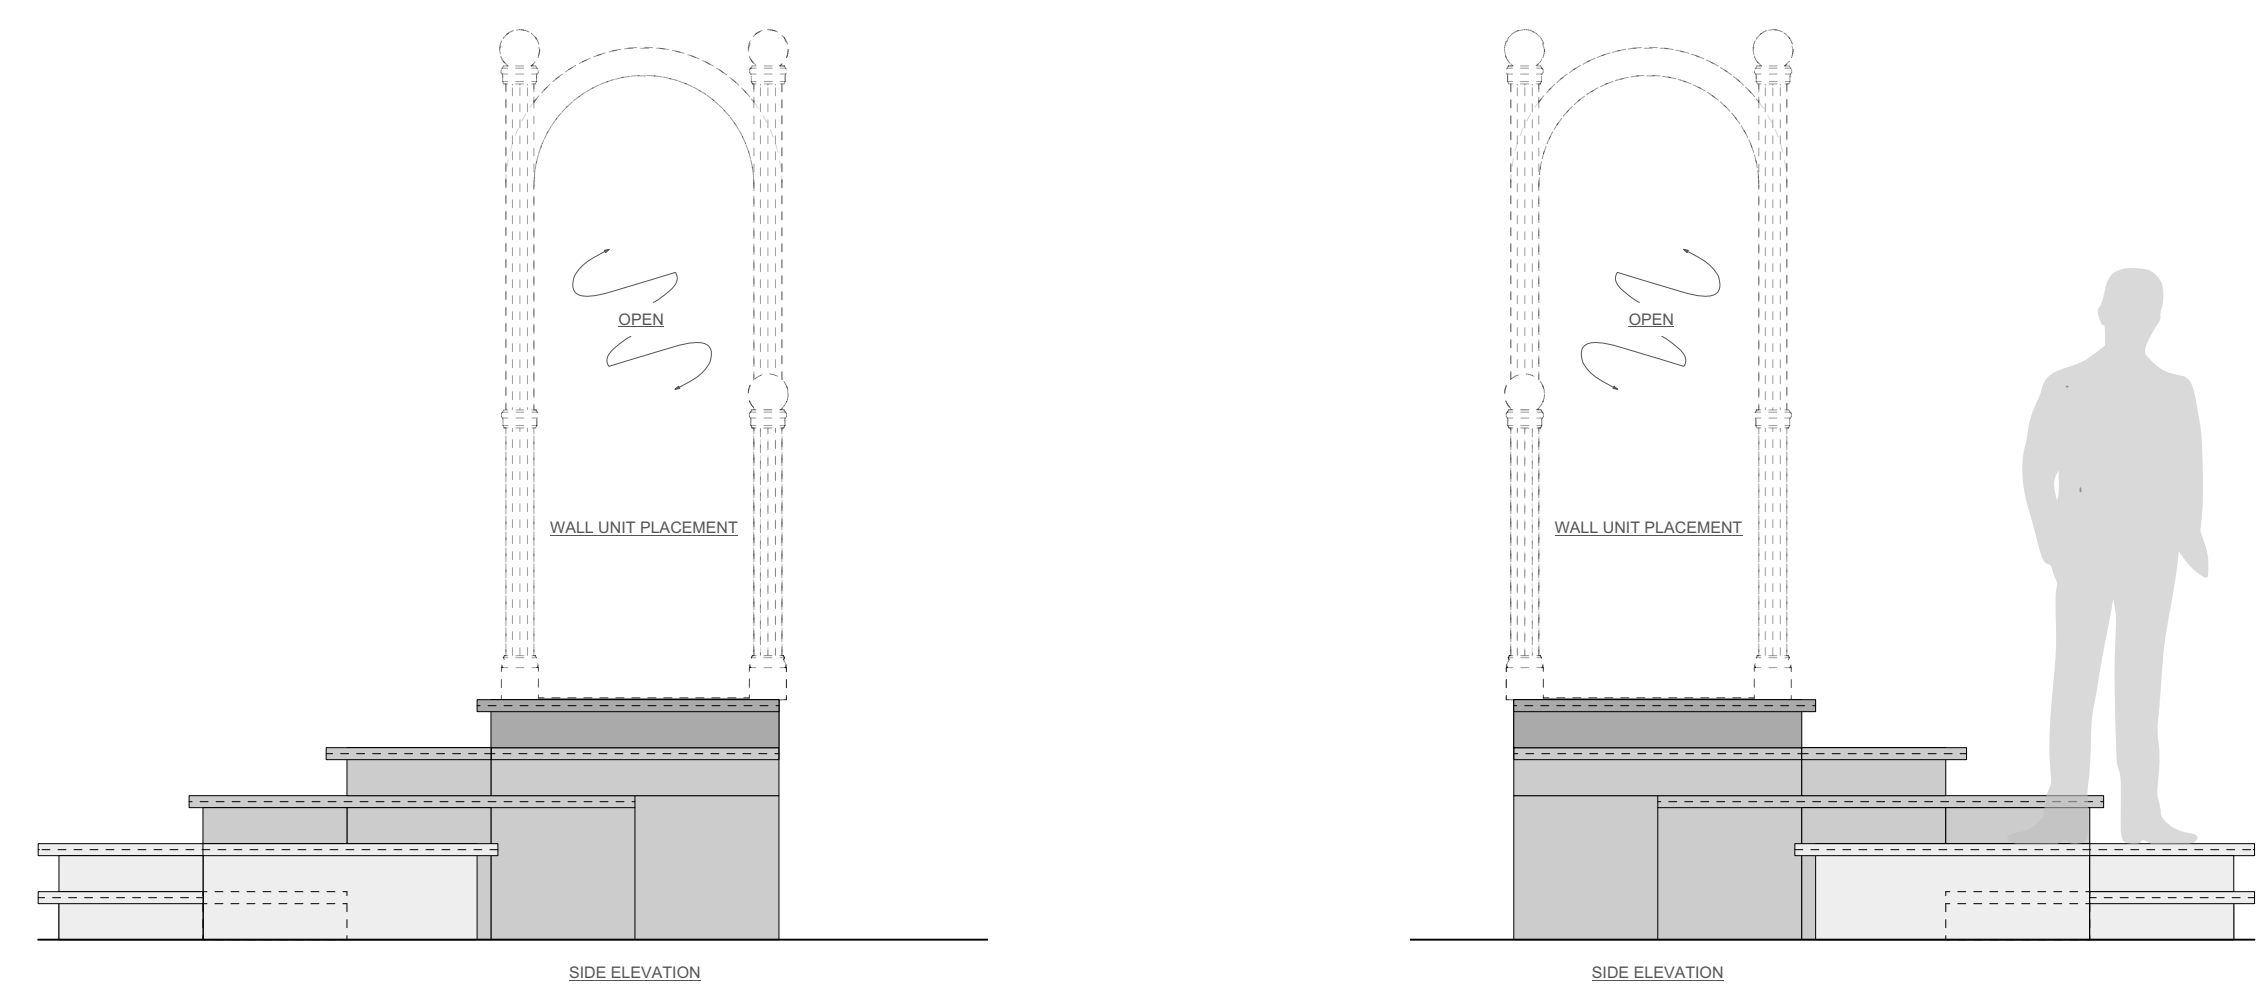

3 **SL & SR PLATFORMS: SIDE ELEVATION**
Scale: 1/2" = 1'-0"

The Princeton Triangle Club
at the McCarter Theatre Presents
PAGEANT PENDING



Book, Music, and Lyrics
TRIANGLE WRITERS
WORKSHOP

Direction Sam Hayes
Choreography Taylor Gordon
Music Direction Pete Mills
Set Design Court Watson
Costume Design Stephanie Echevarria
Lighting Design Alex Slisher & Al Potter
Scenic Draughtsperson Jonas Harrison


SL AND SR PLATFORM UNITS
Scale: 1/2" = 1'-0" (PRINTED 18" X 24")
1/4" = 1'-0" (PRINTED 11" X 17")
Draft Date: 10.7.24
Plate No.

6


of [13]

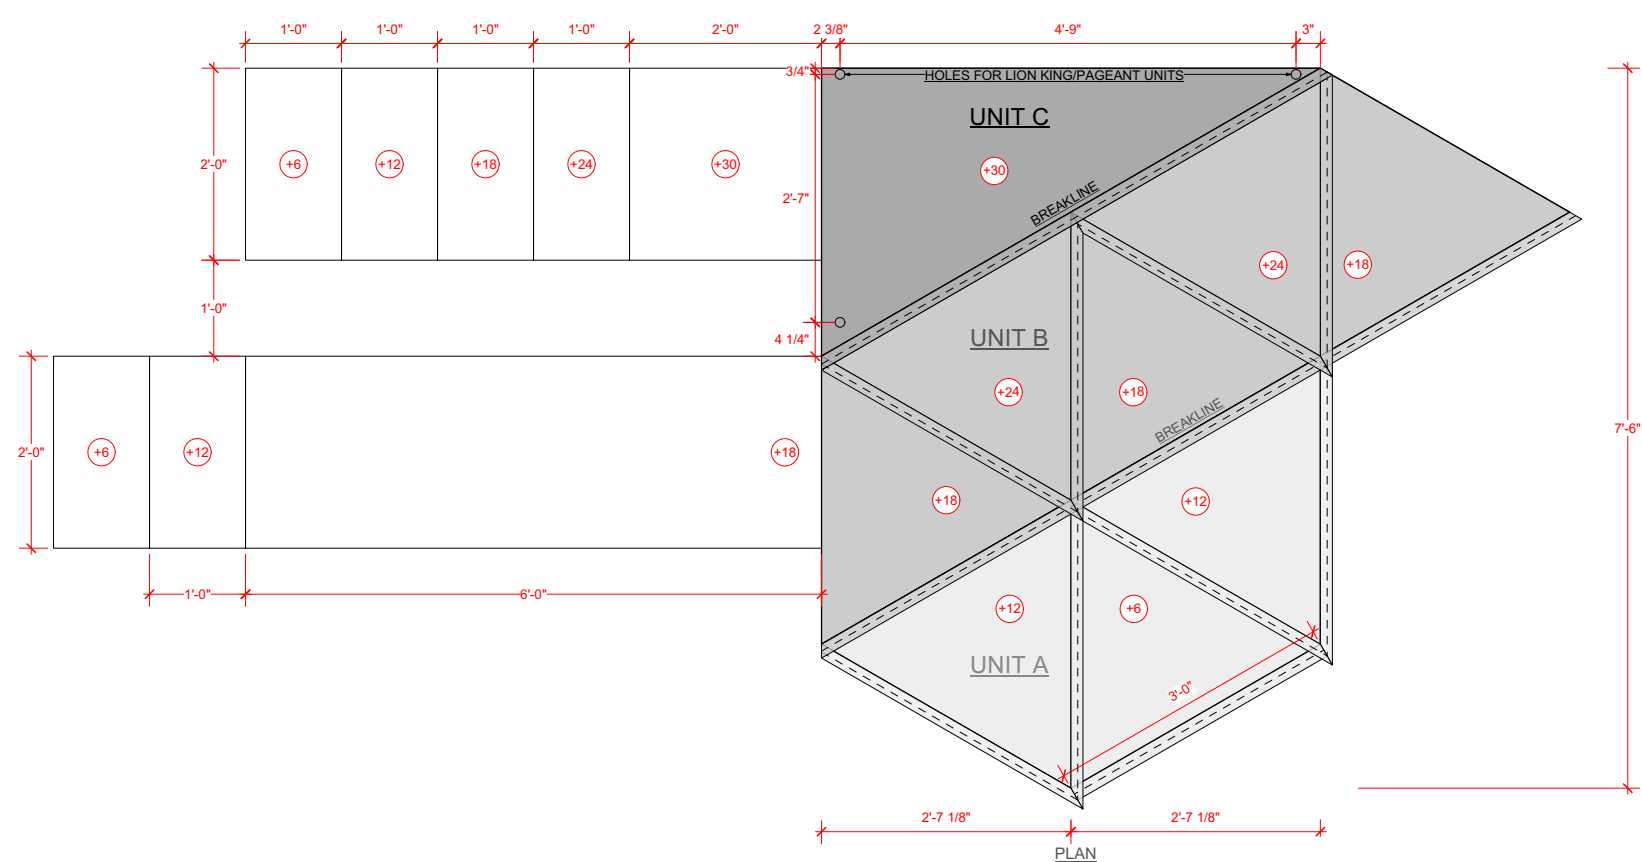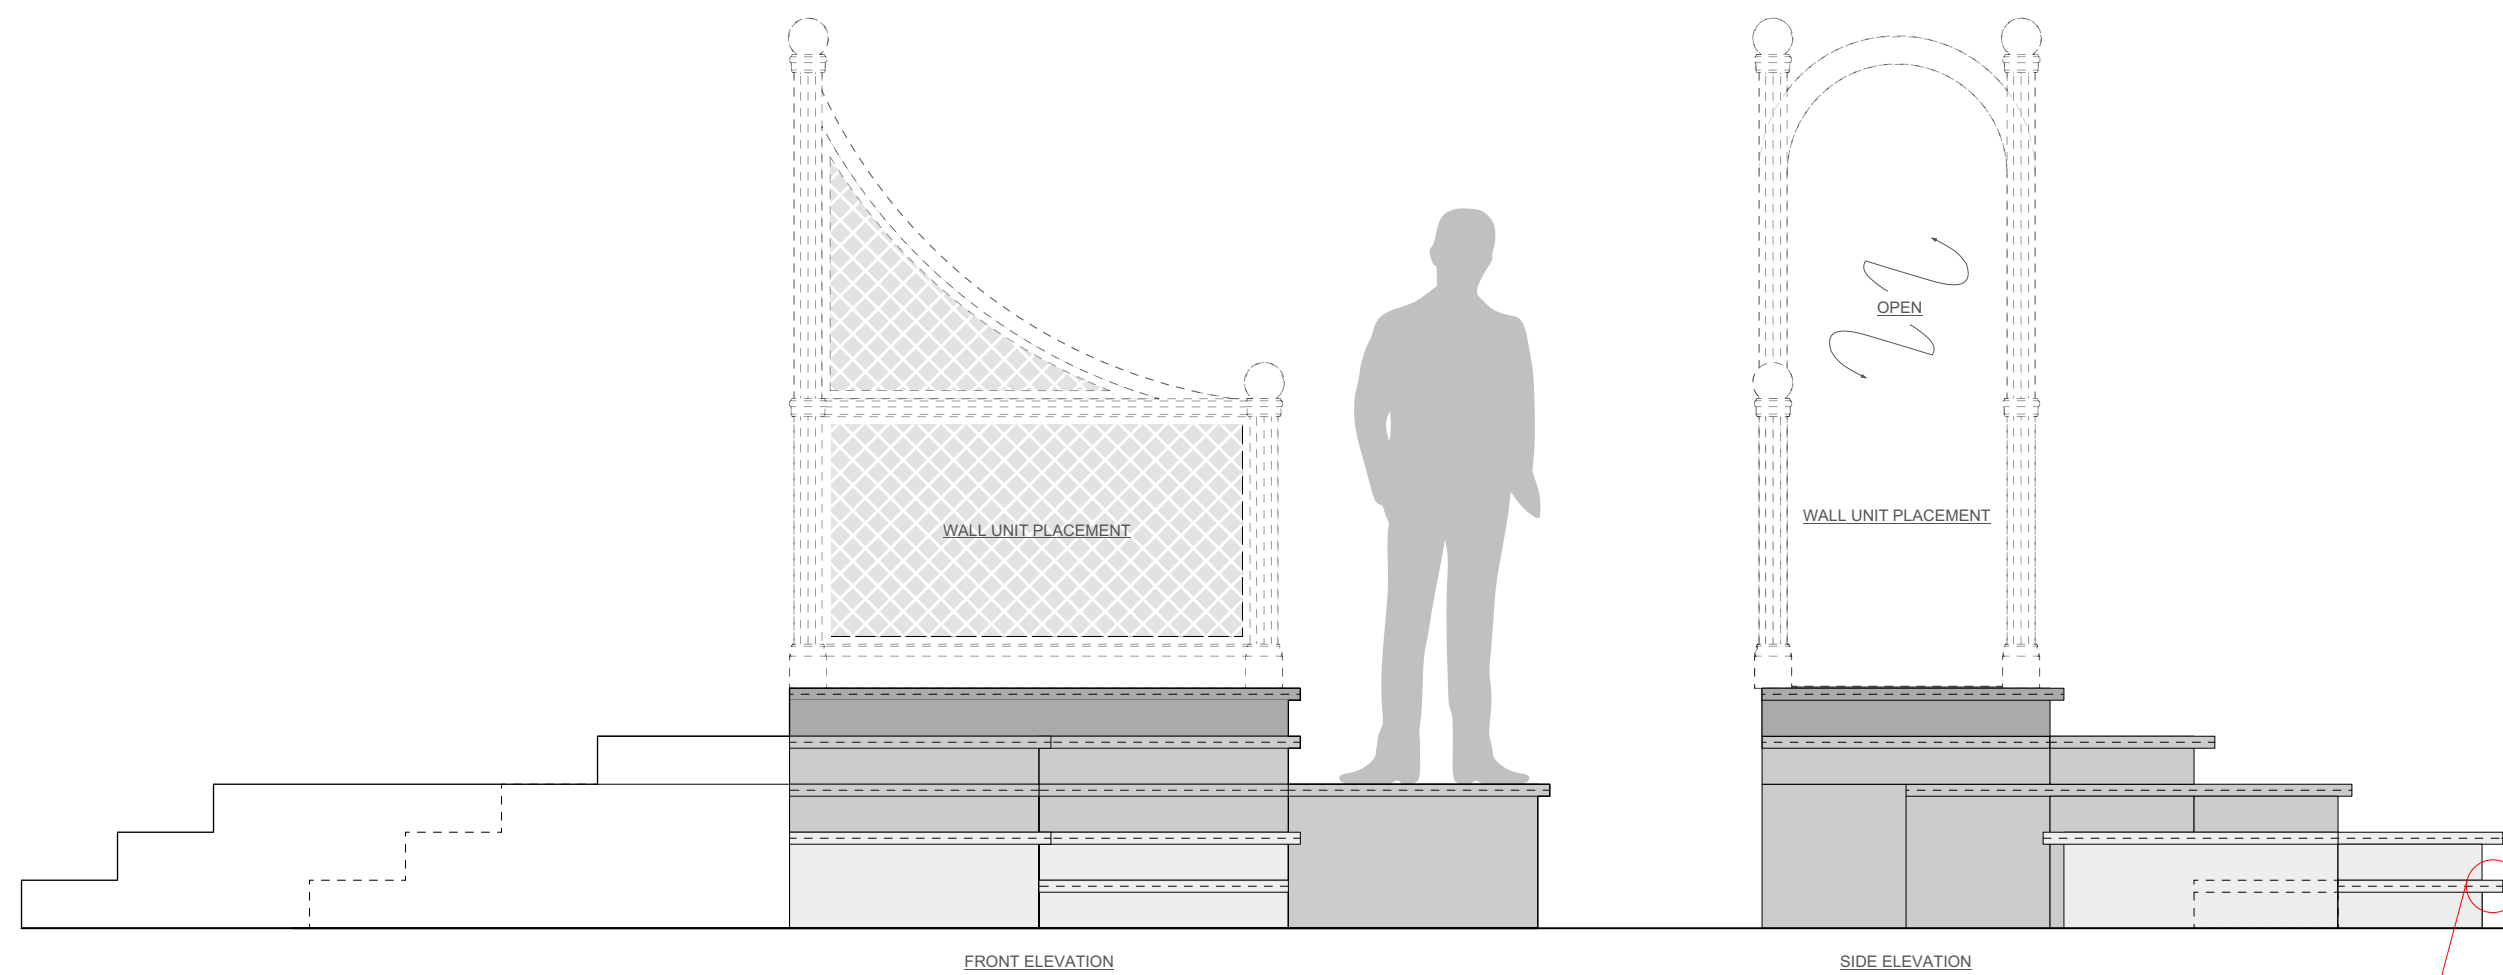

1 **SR PLATFORM ELEVATION**
Scale: 1/2" = 1'-0"

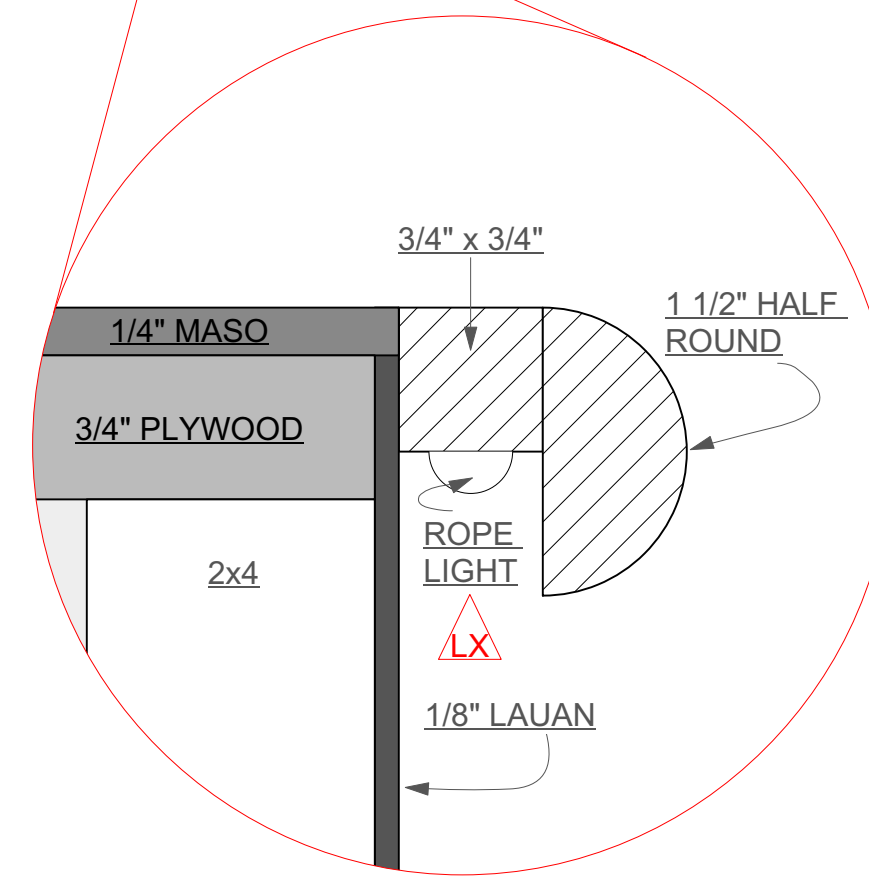

2 **PLATFORM BUILD DETAIL**
Scale: Actual Size

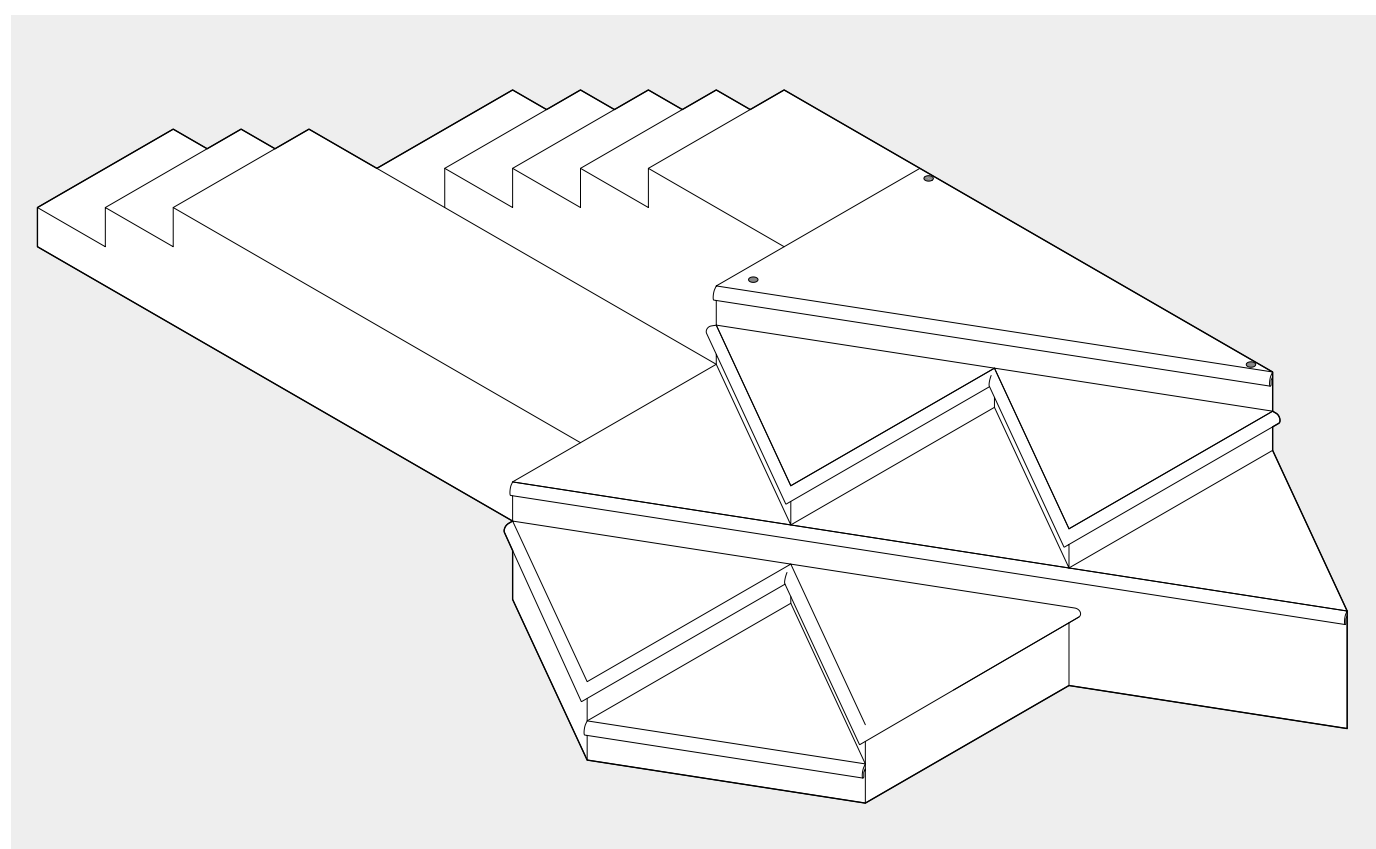

3 **SR PLATFORM ISOMETRIC VIEW**
Scale: 1/2" = 1'-0"

NOTES:



1. MOULDING: HOME DEPOT 1-1/2" x 3/4" OAK SKU 100250278
2. BUILD IN THREE UNITS (SHADED "A" "B" "C") AND WIRE SEPARATELY
3. CIRCUIT EACH LEVEL AS PER UNIT BREAKLINES. EACH UNIT TO BE ONE CHANNEL. CONFIRM WITH LIGHTING DESIGNERS

The Princeton Triangle Club
at the McCarter Theatre Presents
PAGEANT PENDING


Book, Music, and Lyrics
TRIANGLE WRITERS
WORKSHOP

Direction Sam Hayes
Choreography Taylor Gordon
Music Direction Pete Mills
Set Design Court Watson
Costume Design Stephanie Echevarria
Lighting Design Alex Slisher & Al Potter
Scenic Draughtsperson Jonas Harrison


SR PLATFORM UNIT
Scale: 1/2" = 1'-0" (PRINTED 18" X 24")
1/4" = 1'-0" (PRINTED 11" X 17")
Draft Date: 10.7.24
Plate No.

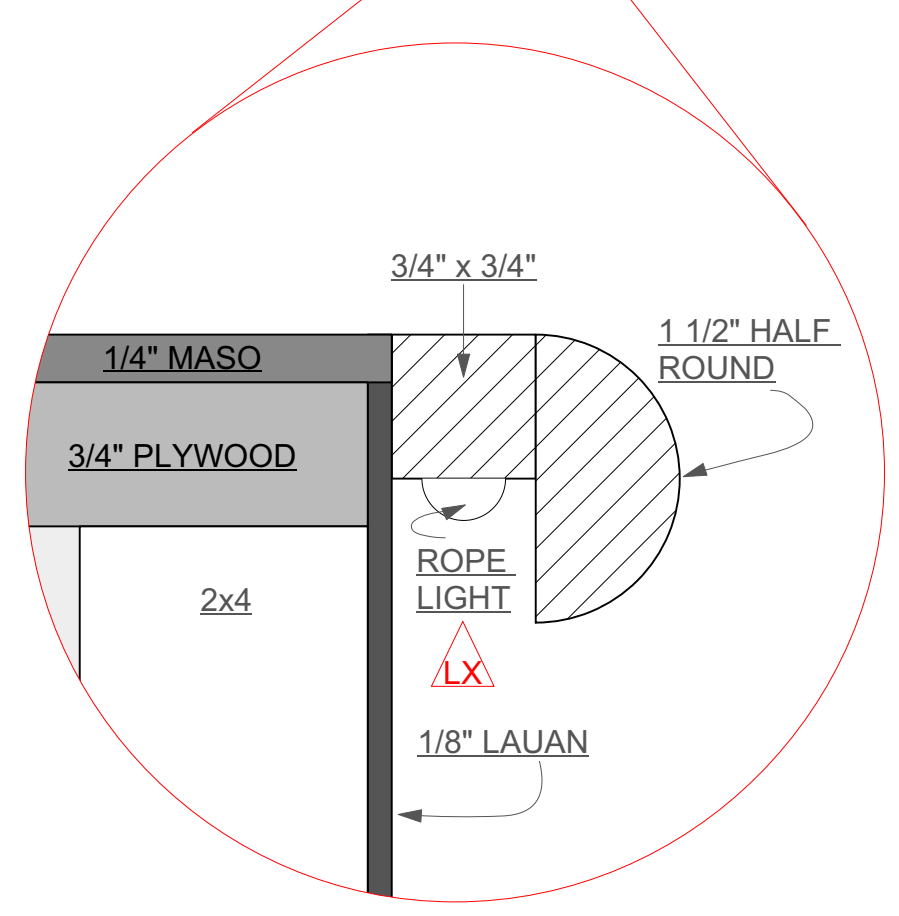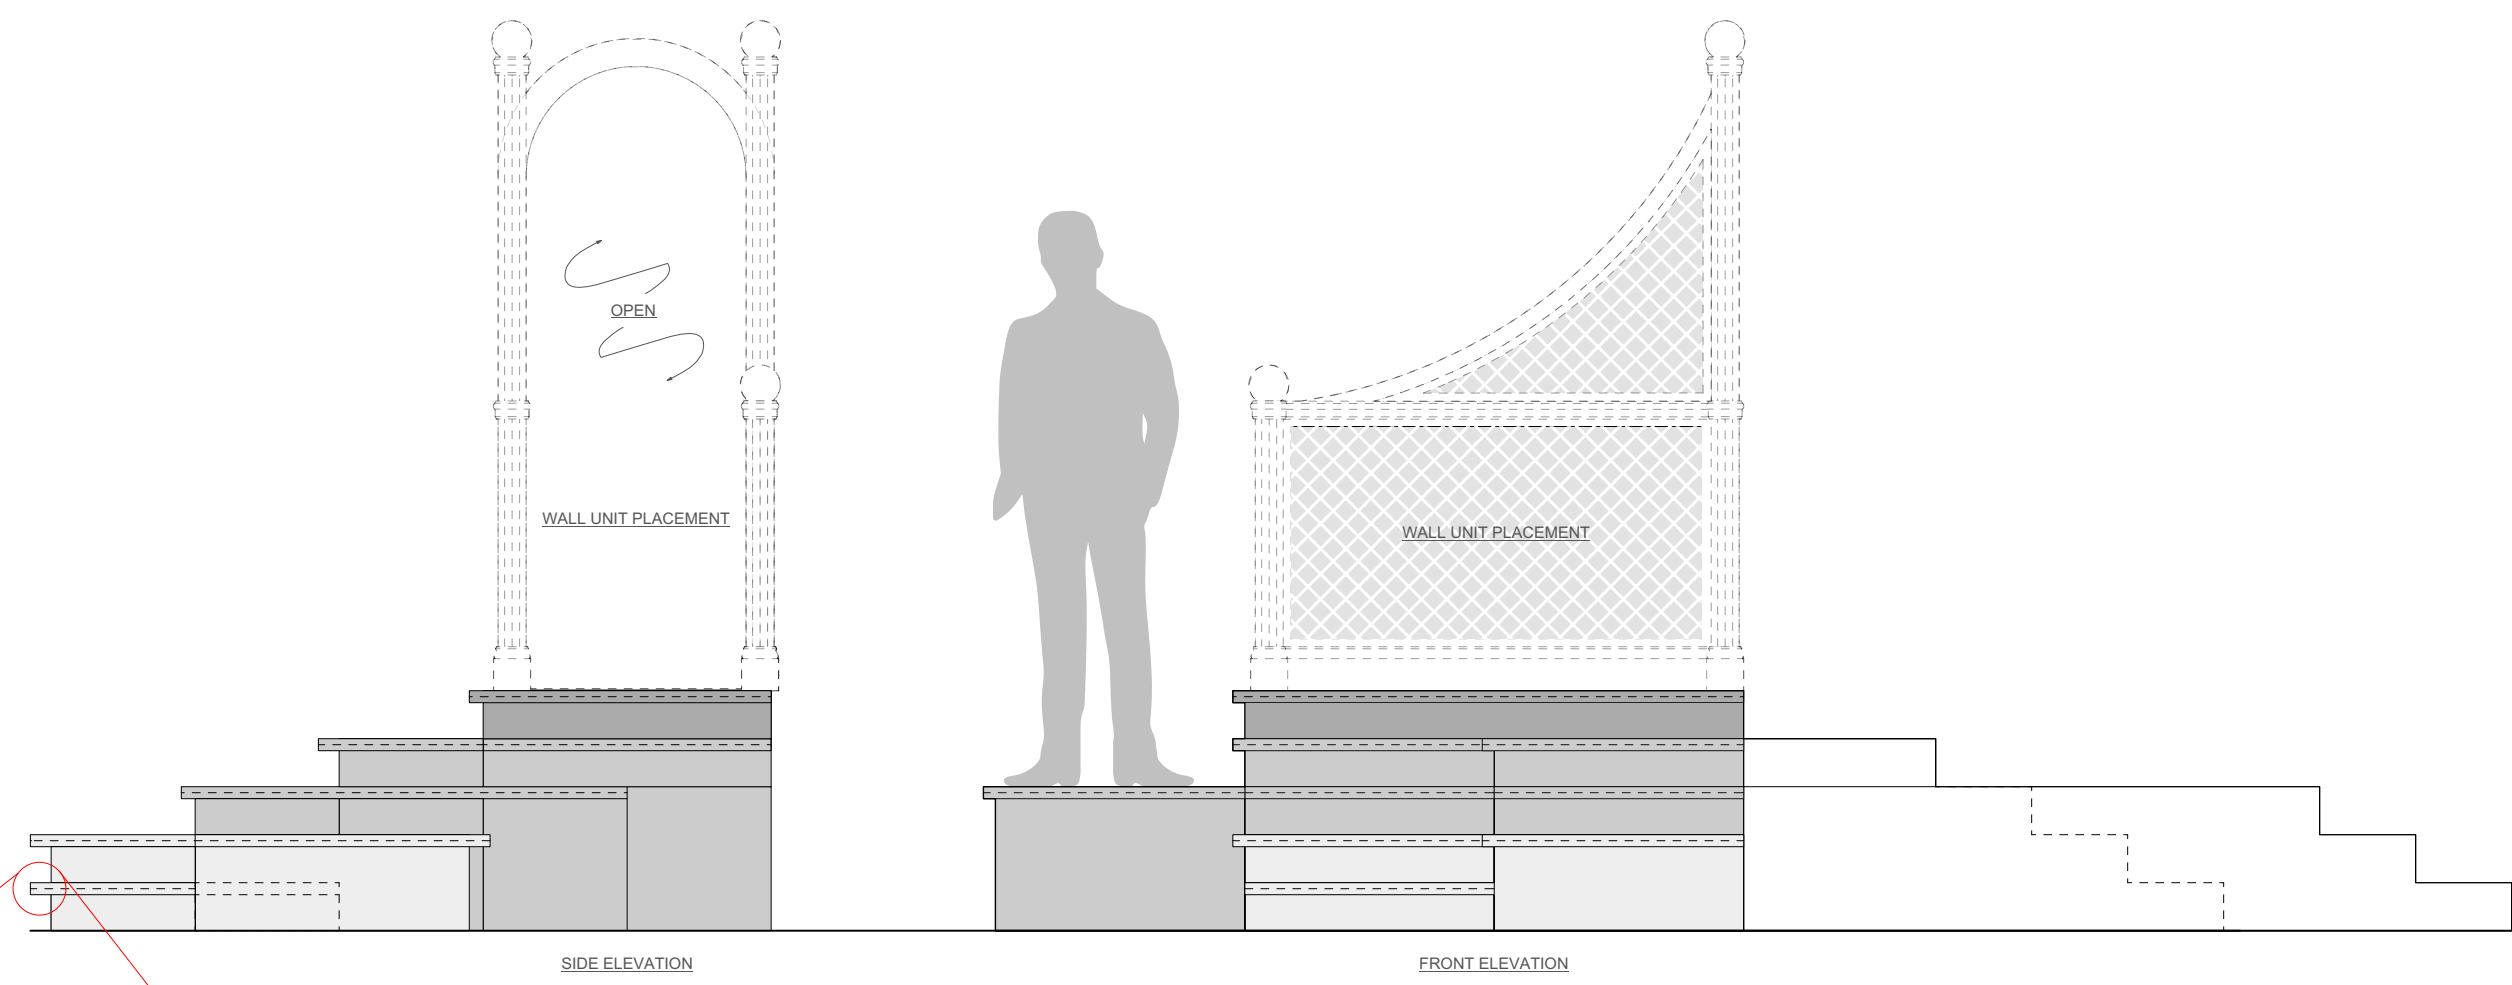

2 **PLATFORM BUILD DETAIL**
Scale: Actual Size

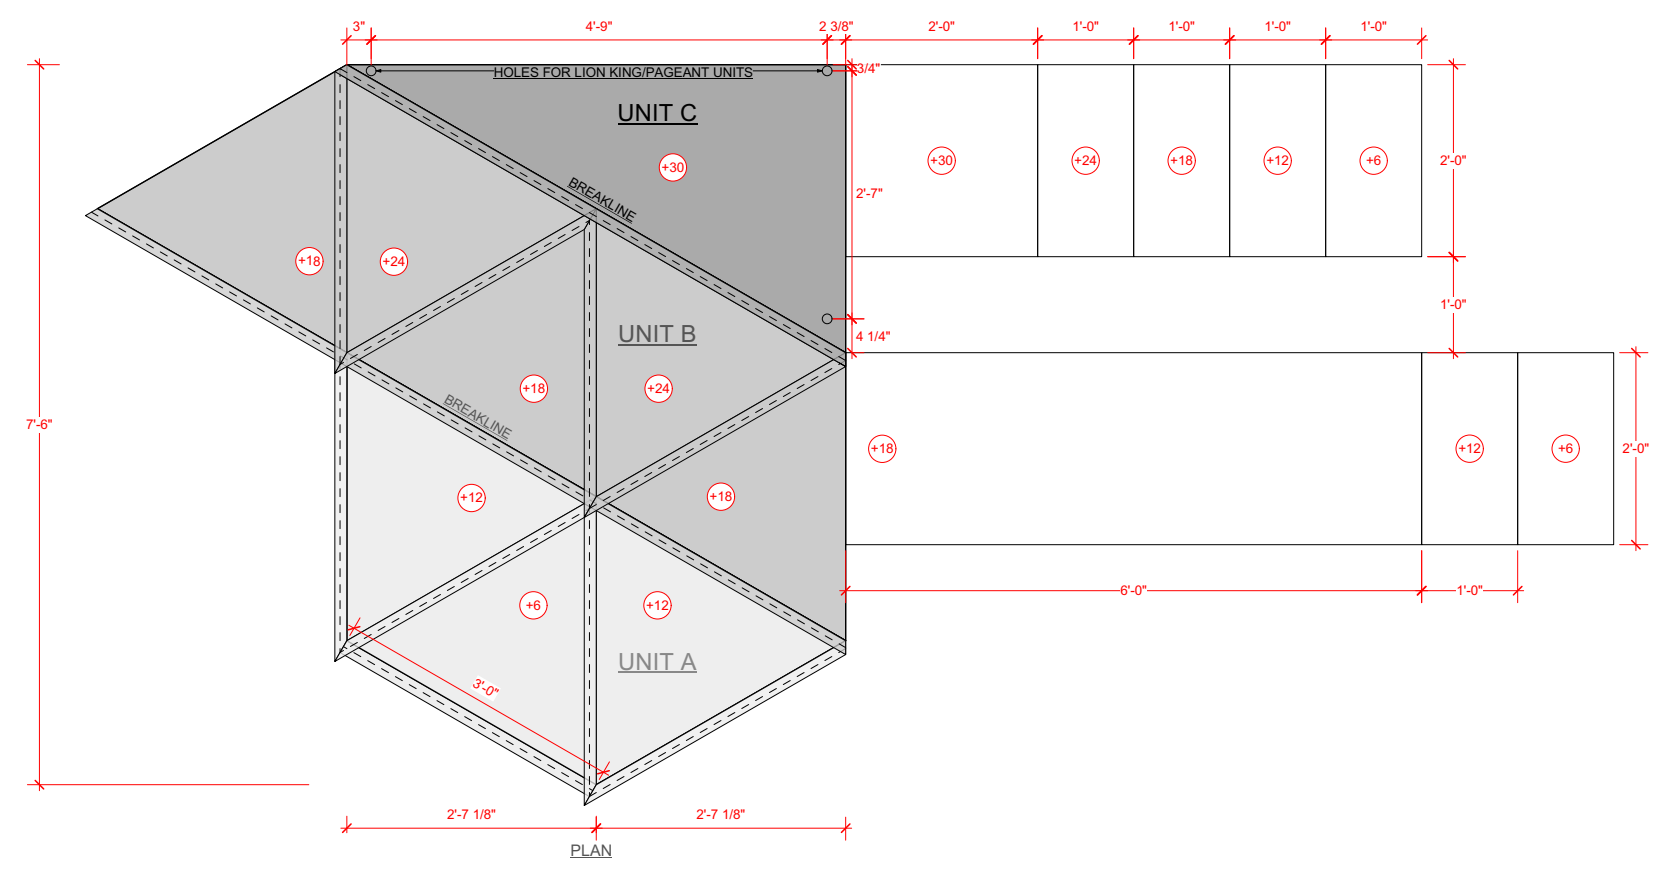

1 **SL PLATFORM ELEVATION**
Scale: 1/2" = 1'-0"

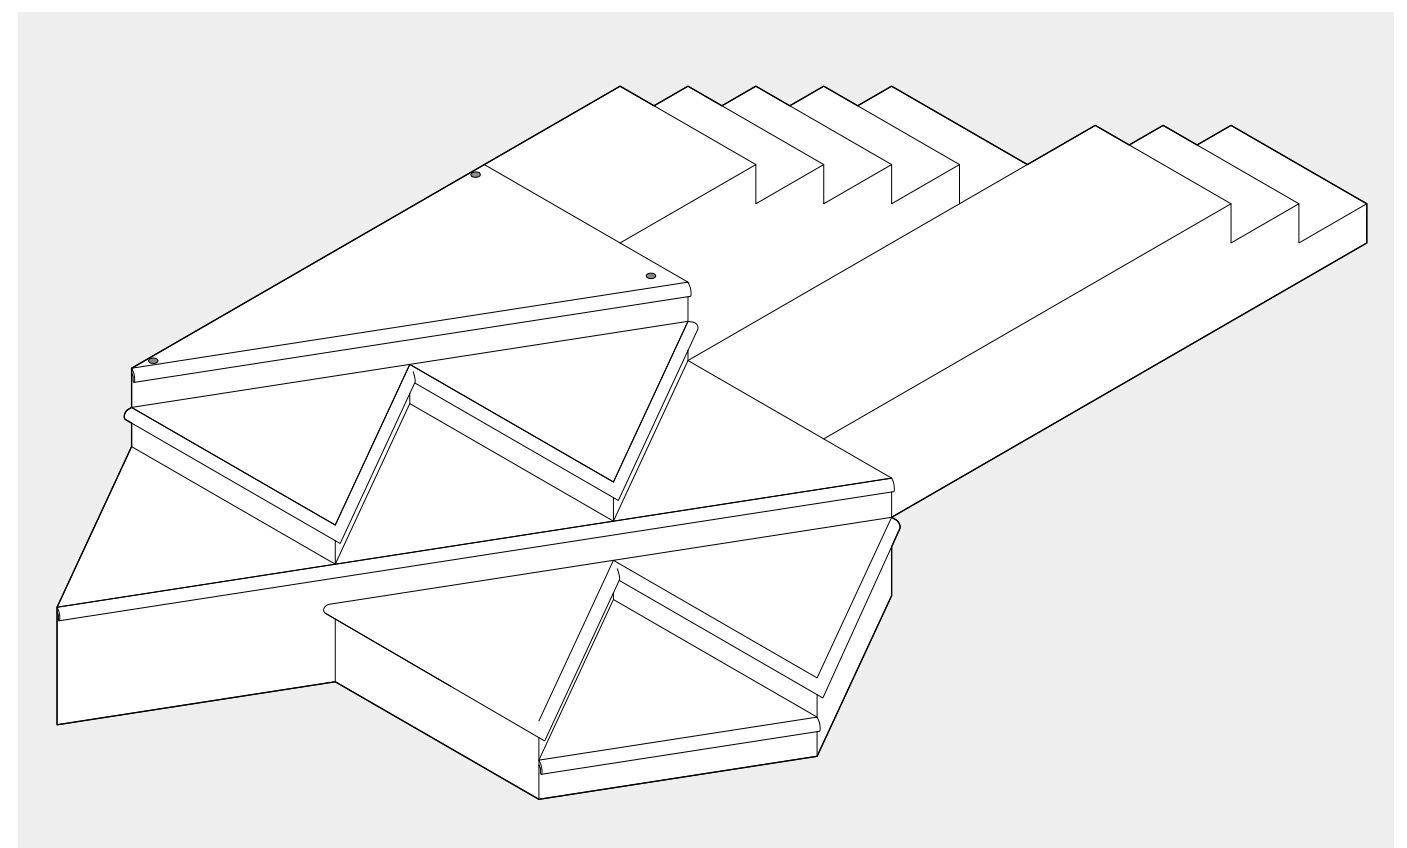

3 **SL PLATFORM ISOMETRIC VIEW**
Scale: 1/2" = 1'-0"

- NOTES:
1. MOULDING: HOME DEPOT 1-1/2" x 3/4" OAK SKU 100250278
 2. BUILD IN THREE UNITS (SHADED "A" "B" "C") AND WIRE SEPARATELY
 3. CIRCUIT EACH LEVEL AS PER UNIT BREAKLINES. EACH UNIT TO BE ONE CHANNEL. CONFIRM WITH LIGHTING DESIGNERS

The Princeton Triangle Club
at the McCarter Theatre Presents
PAGEANT PENDING


Book, Music, and Lyrics
TRIANGLE WRITERS
WORKSHOP

Direction Sam Hayes
Choreography Taylor Gordon
Music Direction Pete Mills
Set Design Court Watson
Costume Design Stephanie Echevarria
Lighting Design Alex Slisher & Al Potter
Scenic Draughtsperson Jonas Harrison

SL PLATFORM UNIT
Scale: 1/2" = 1'-0" (PRINTED 18" X 24")
1/4" = 1'-0" (PRINTED 11" X 17")
Draft Date: 10.7.24
Plate No.

8


of [13]

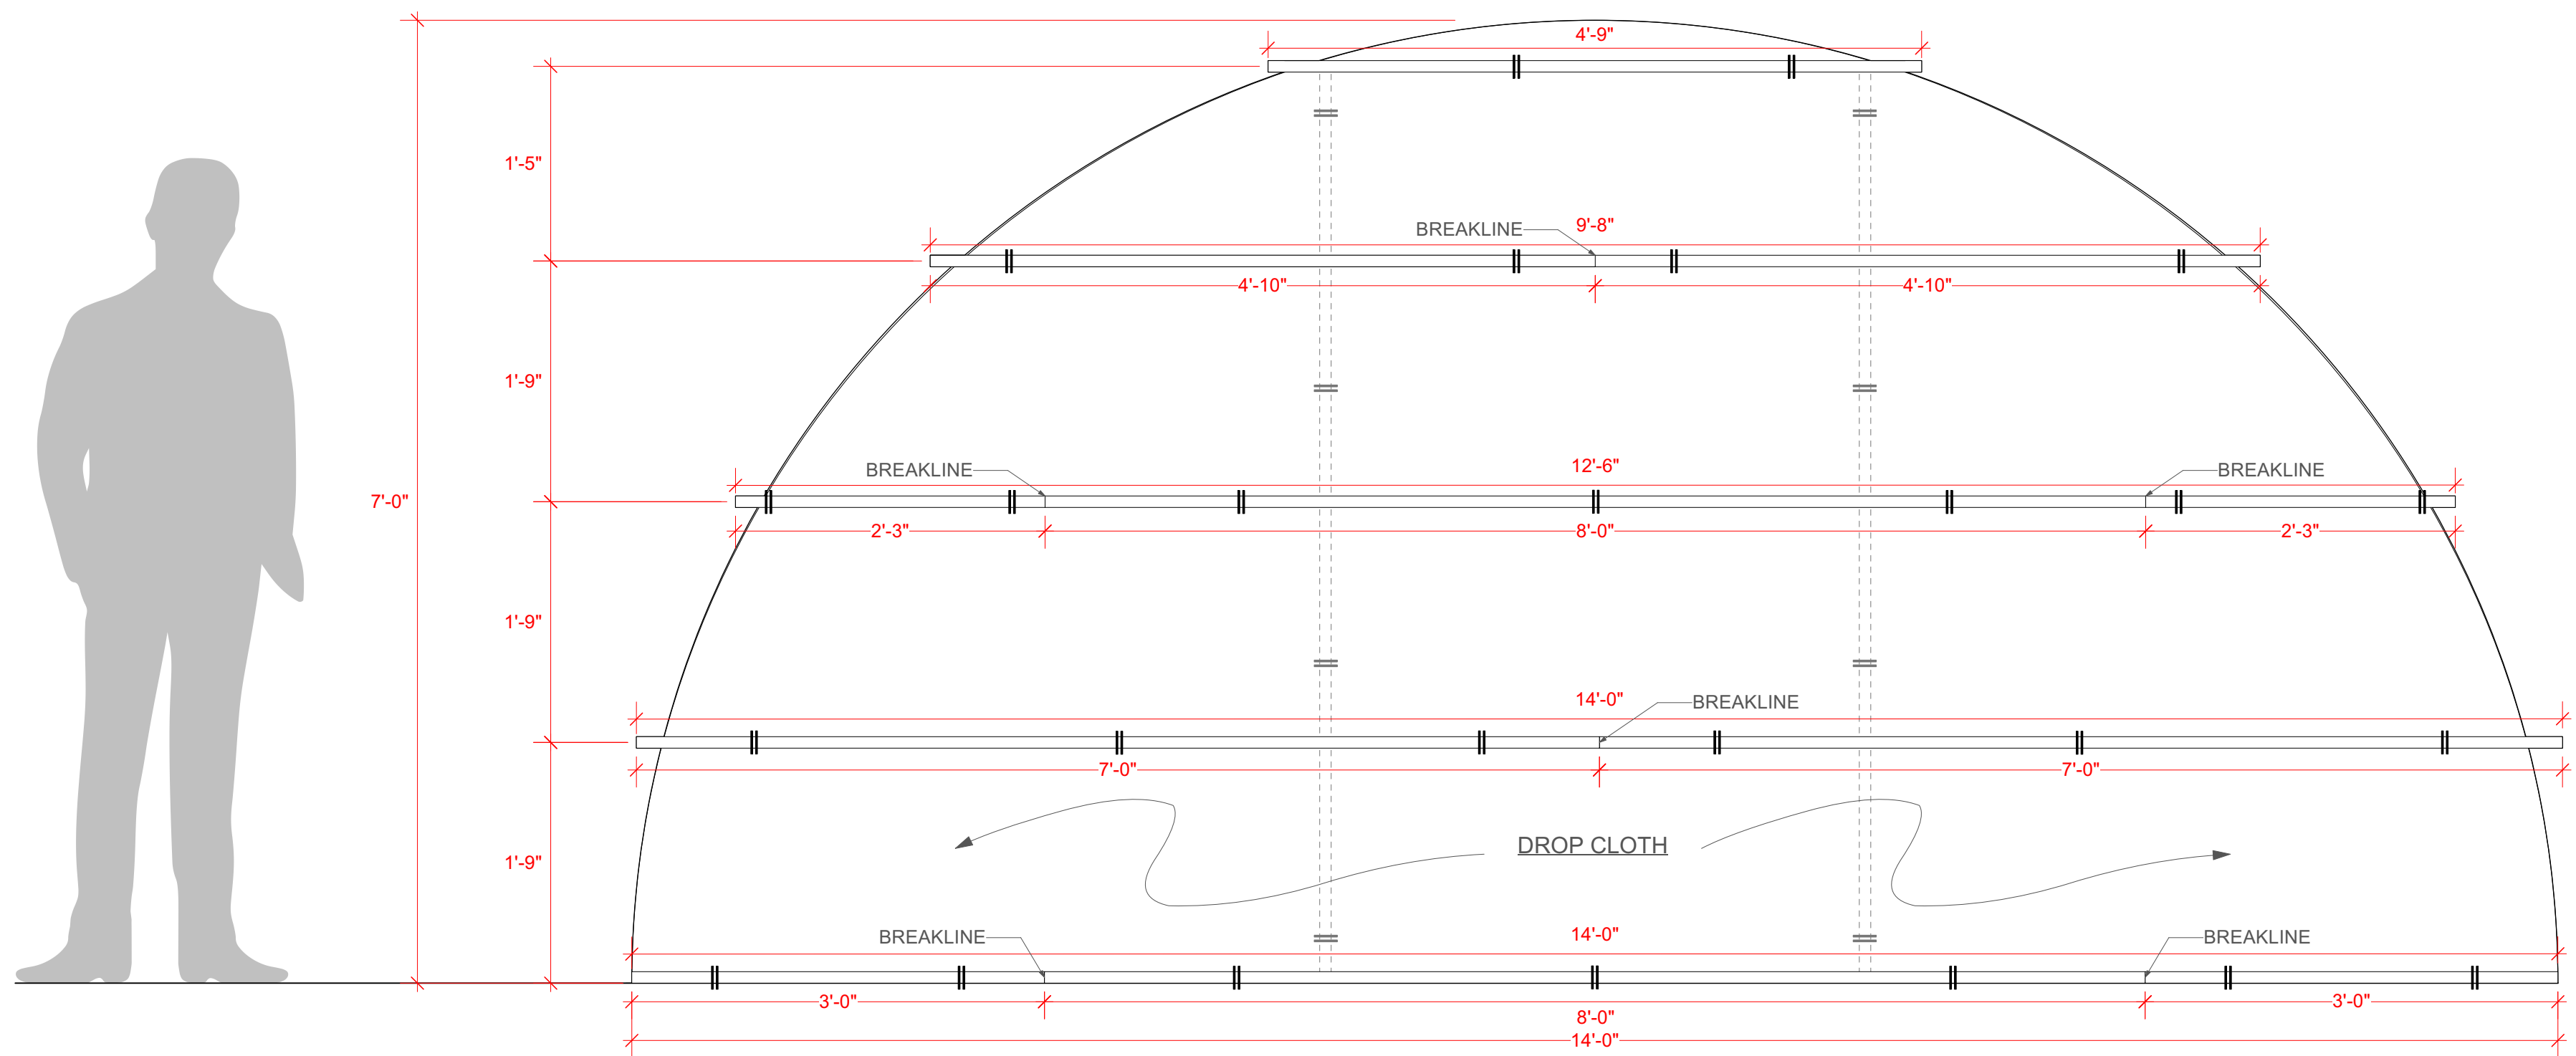

FRONT ELEVATION

NOTES:

1. ZIP TIE HORIZONTAL BAMBOO STICKS TO DROPCLOTH
2. ADD TWO ZIP-TIED POLES TO UPSTAGE SIDE FOR PERFORMERS TO RAISE
3. ROLL TO STORE
4. USE EXISTING PAINT-SPATTERED DROPCLOTH. ADD HAND-SPATTER OF YELLOW AND ORANGE OMBRE.
5. BAMBOO STICKS TO BE HOME DEPOT ECOSTAKE BAMBOO SKU 1009113202

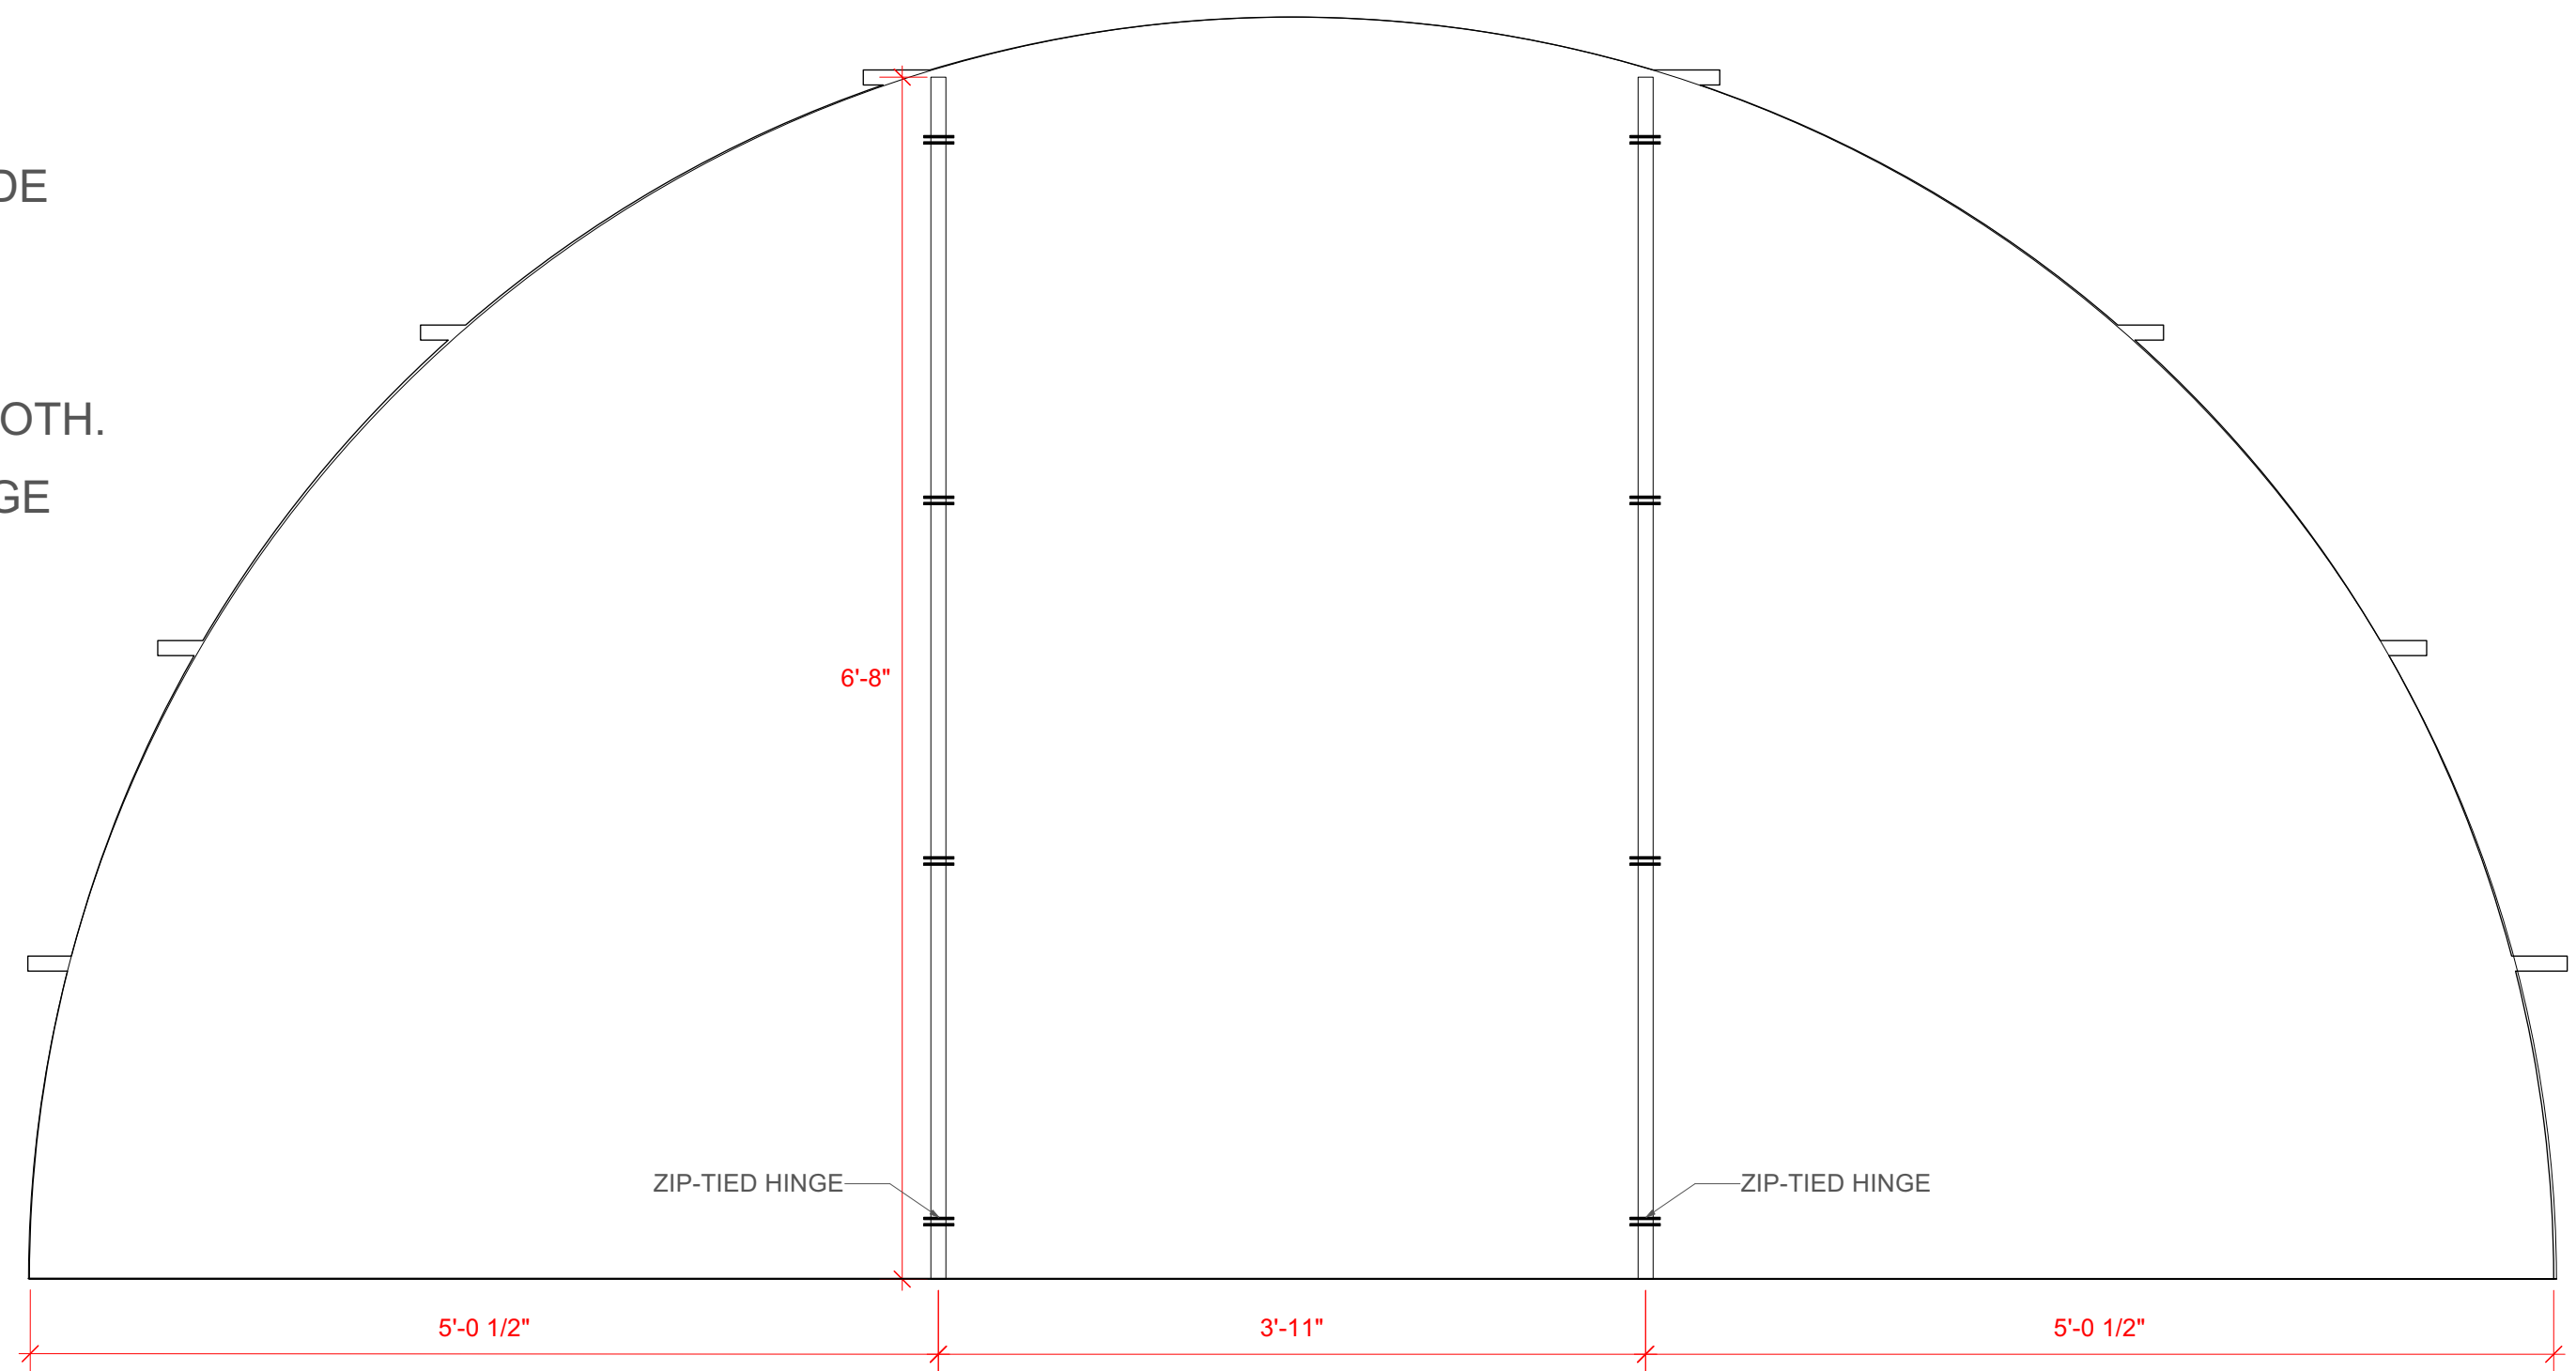

BACK ELEVATION

The Princeton Triangle Club
at the McCarter Theatre Presents
PAGEANT PENDING

Book, Music, and Lyrics
TRIANGLE WRITERS
WORKSHOP

Direction Sam Hayes
Choreography Taylor Gordon
Music Direction Pete Mills
Set Design Court Watson
Costume Design Stephanie Echevarria
Lighting Design Alex Slisher & Al Potter
Scenic Draughtsperson Jonas Harrison



LION KING SUN

Scale: 1" = 1'-0" (PRINTED 18" X 24")
1/2" = 1'-0" (PRINTED 11" X 17")


Draft Date: 10.7.24

Plate No.


9

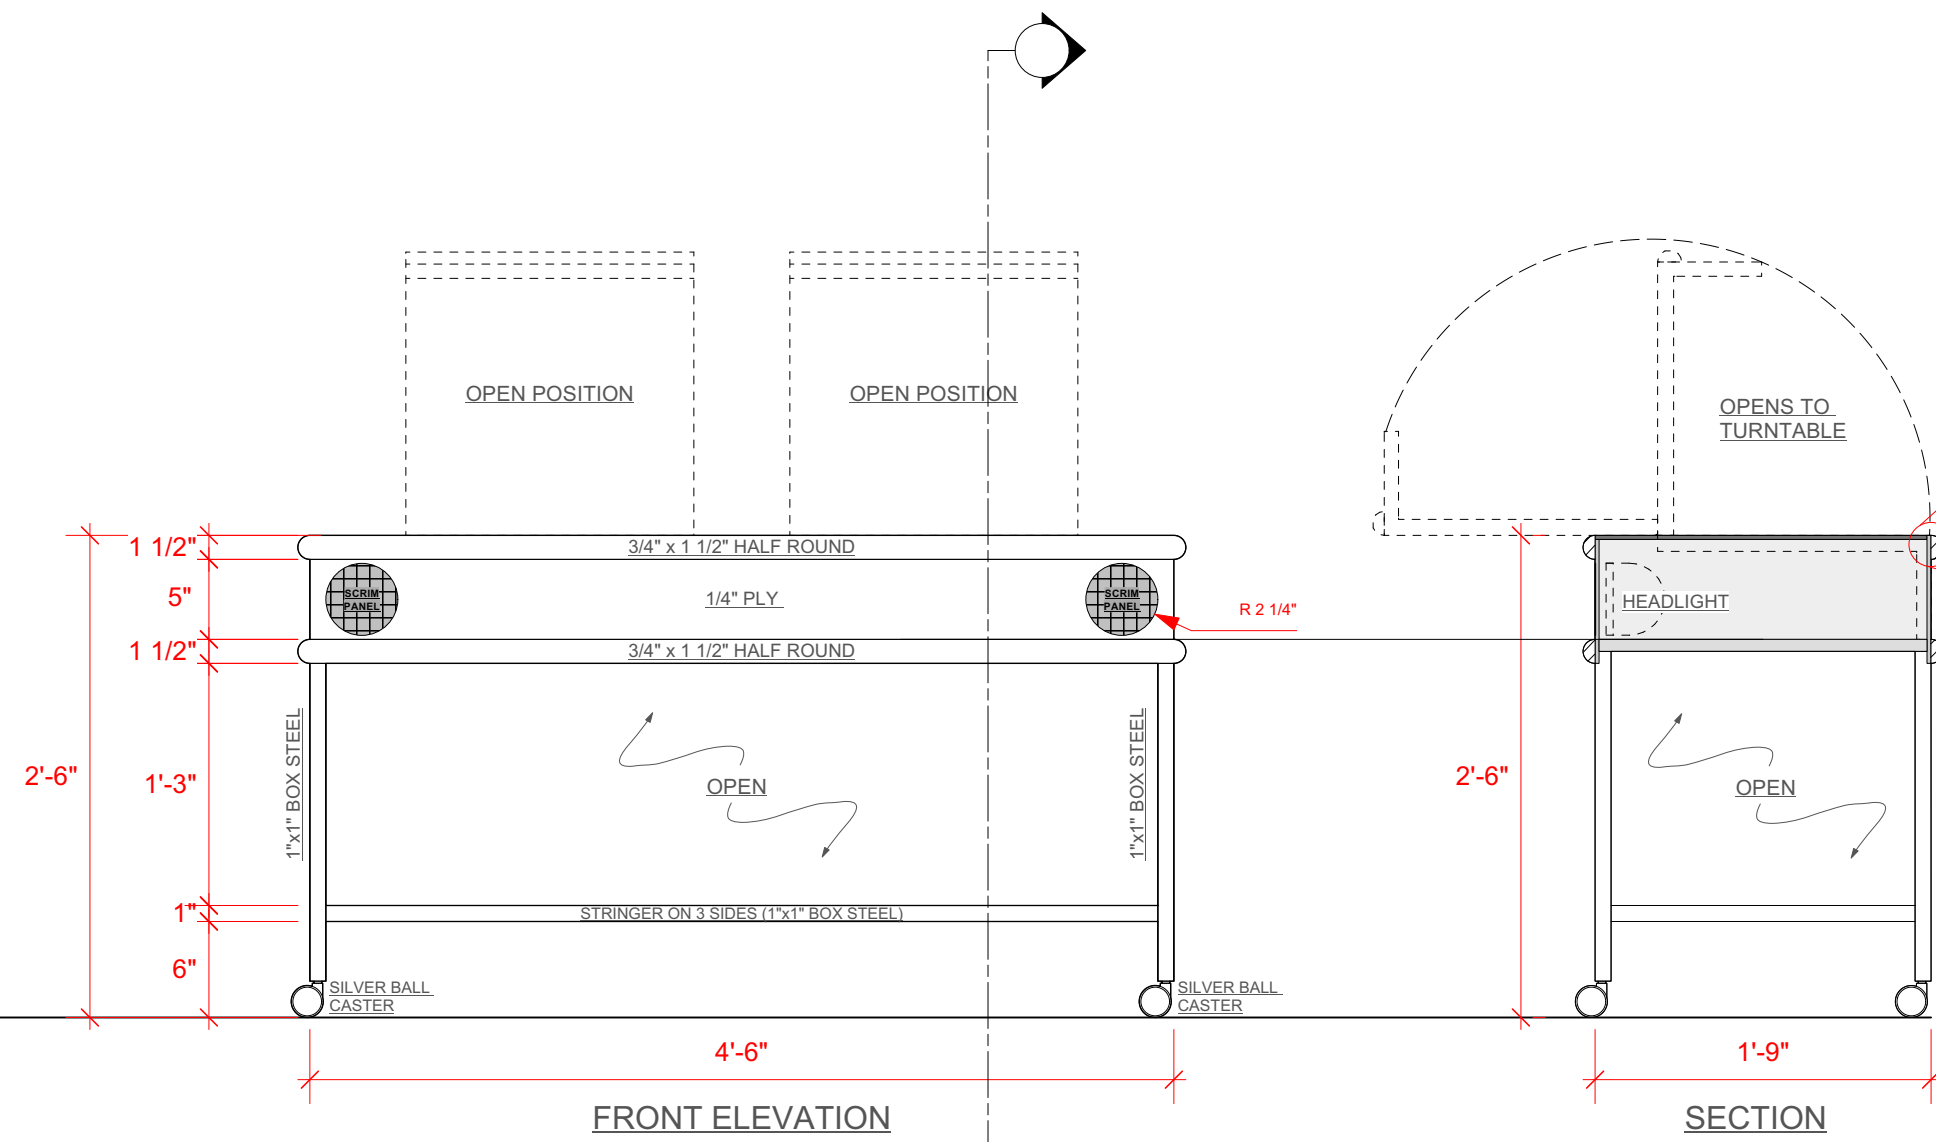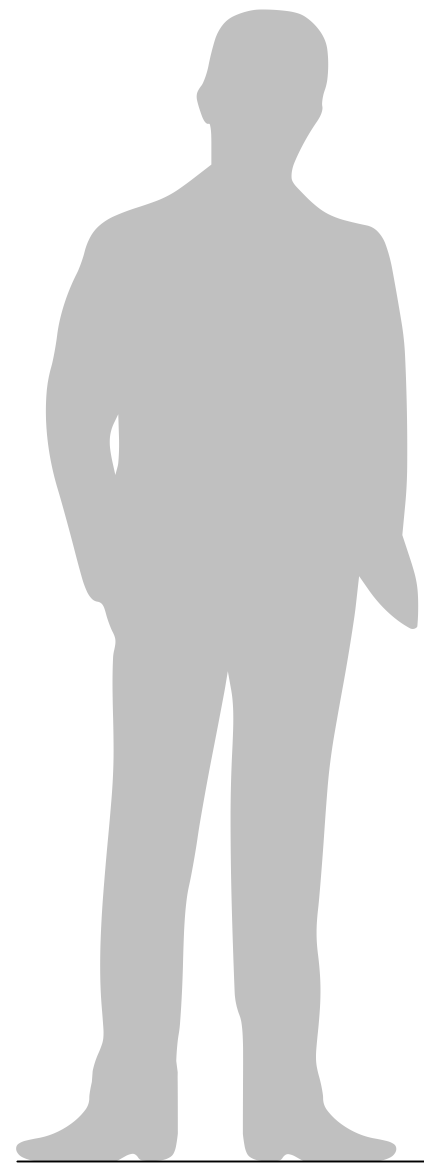

1 **TABLE BUILD DETAIL**
Scale: Actual Size

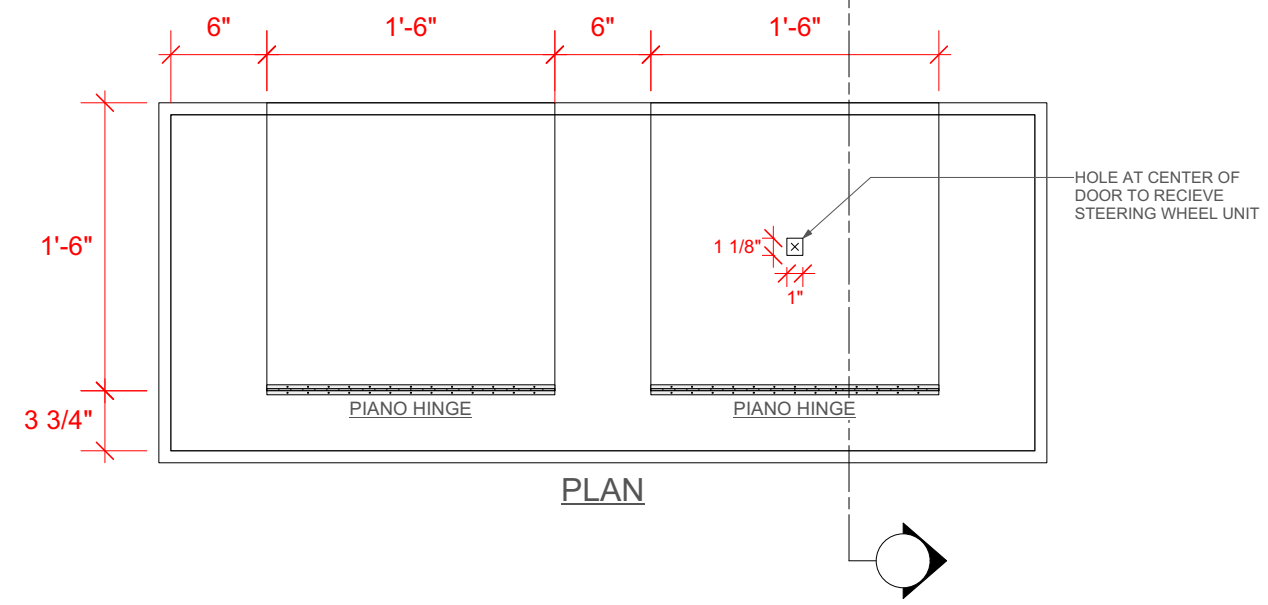

3 **JUDGE'S TABLE ELEVATION**
Scale: 1" = 1'-0"

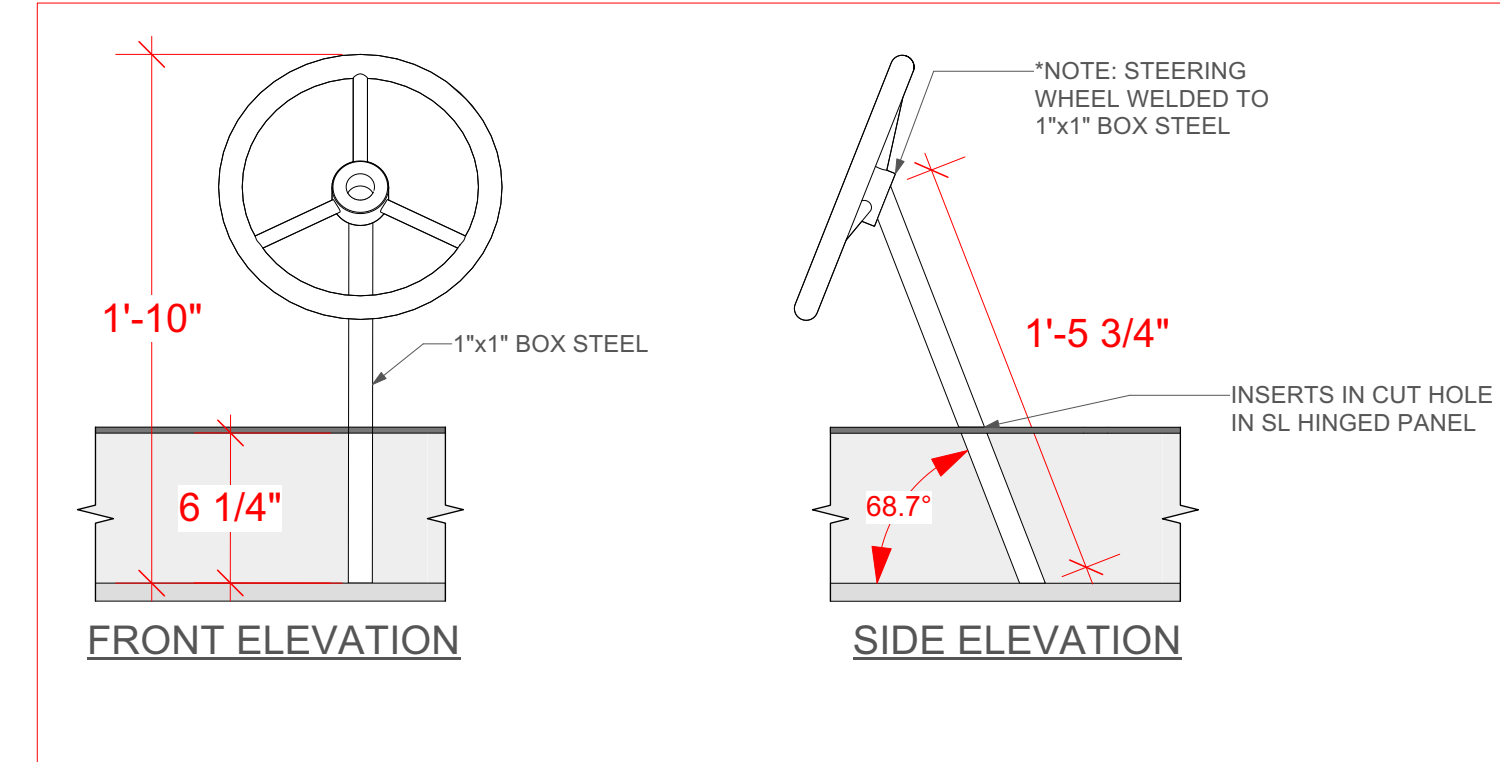

2 **STEERING WHEEL UNIT ELEVATION**
Scale: 1 1/2" = 1'-0"

NOTES:

1. MOULDING: HOME DEPOT 1-1/2" x 3/4" OAK SKU 1002502784
2. LEGS ARE 1"x1" BOX STEEL W/ SILVER BALL WHEELS
3. NOTE THE TWO HINGED PANELS THAT OPEN TO REVEAL DJ TURNTABLES PROP
4. PROVIDE TWO PAINTED SCRIM PANELS TO HIDE HEADLIGHTS WITHIN
5. CUT HOLE IN SL HINGED PANEL TO RECEIVE STEERING WHEEL UNIT

The Princeton Triangle Club
at the McCarter Theatre Presents
PAGEANT PENDING


Book, Music, and Lyrics TRIANGLE WRITERS WORKSHOP

Direction Sam Hayes
Choreography Taylor Gordon
Music Direction Pete Mills
Set Design Court Watson
Costume Design Stephanie Echevarria
Lighting Design Alex Slisher & Al Potter
Scenic Draughtsperson Jonas Harrison


JUDGE'S TABLE
Scale: 1" = 1'-0" (PRINTED 18" X 24")
1/2" = 1'-0" (PRINTED 11" X 17")
Draft Date: 10.7.24
Plate No.

10


of [13]

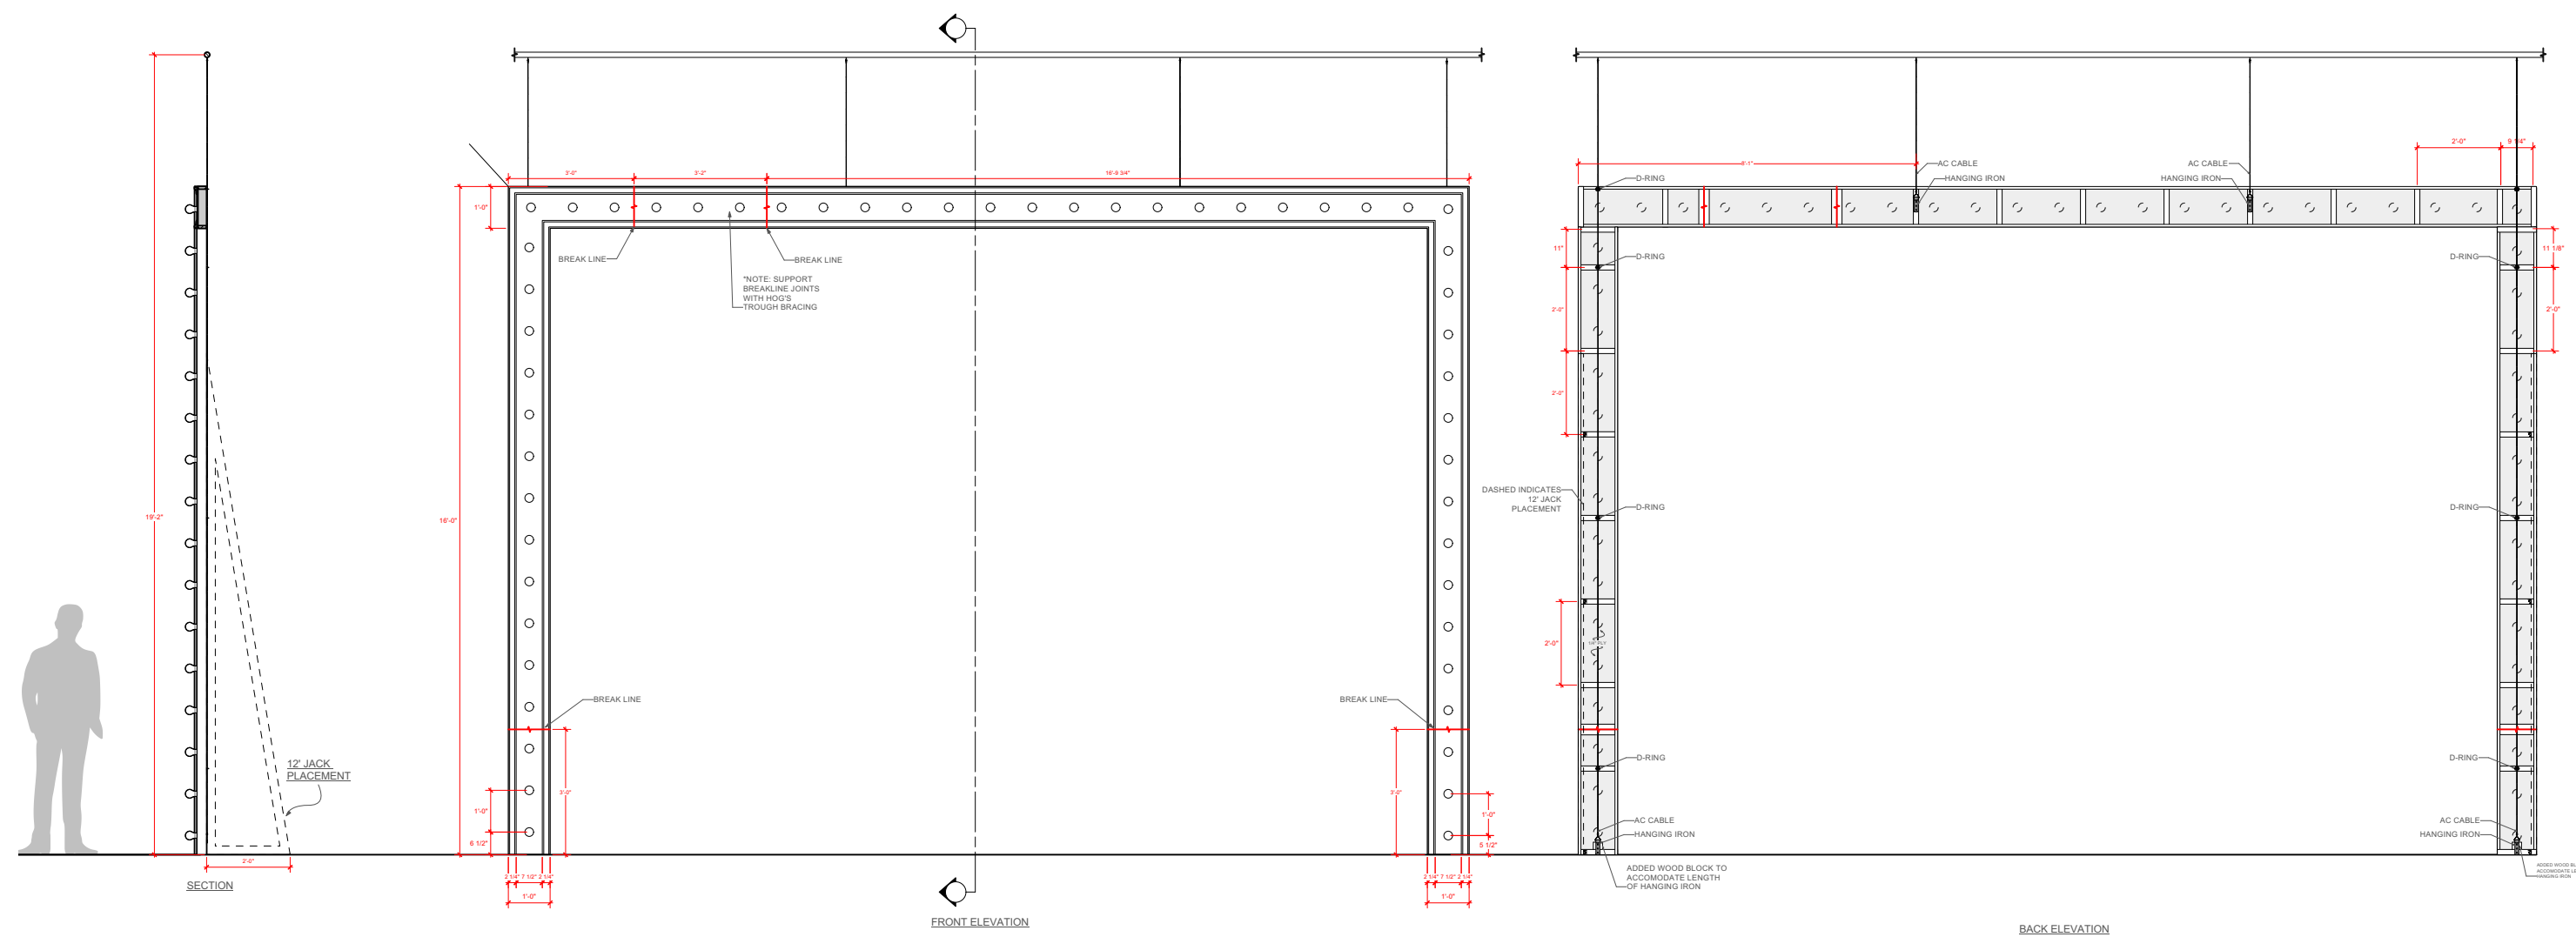

1 PROSCENIUM ELEVATION
Scale: 1/4" = 1'-0"

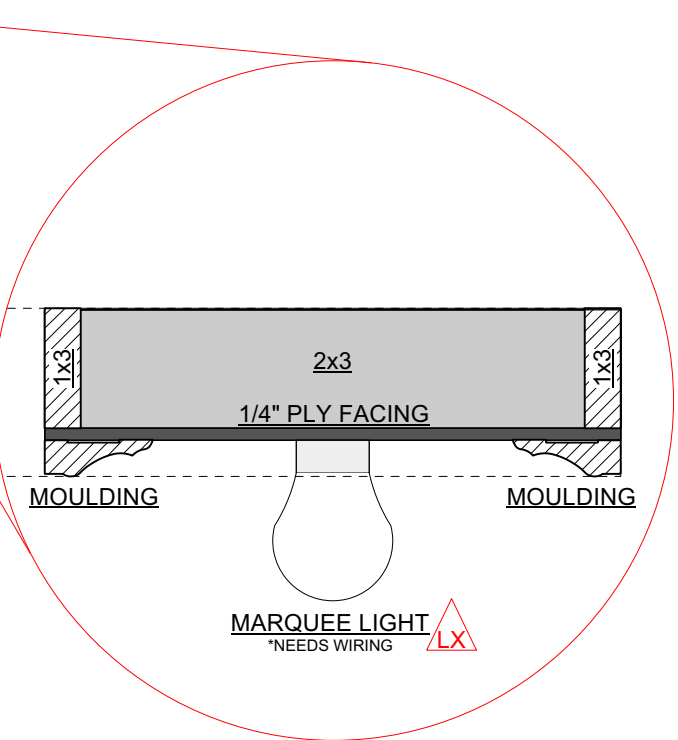

3 PROSCENIUM FRAME DETAIL
Scale: 3" = 1'-0"

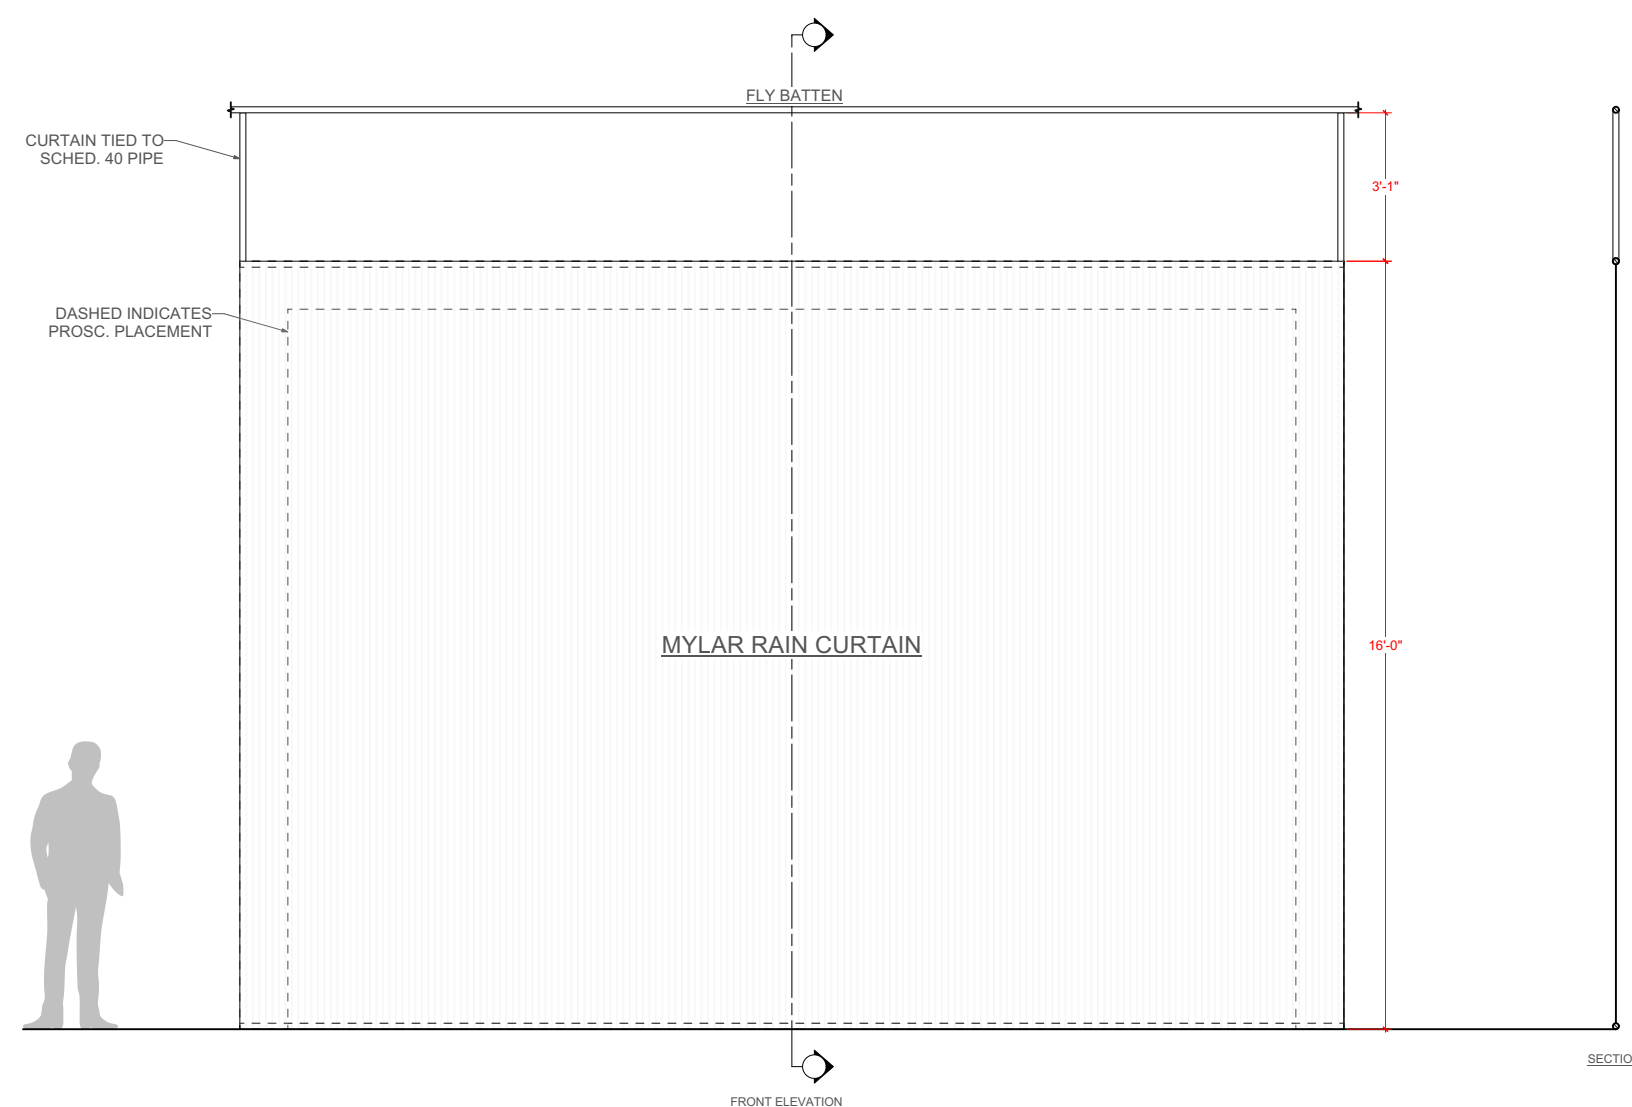

2 RAIN CURTAIN ELEVATION
Scale: 1/4" = 1'-0"

NOTES:

1. MOULDING: HOME DEPOT 2-1/4" x 9/16" CASING SKU 890789
2. BREAK LINES FOR STORAGE INDICATED IN RED.
3. MARQUEE LAMPS TO BE 1.5" DIAMETER ACRYLIC/PLASTIC ROUND BULBS. DISCUSS LAMP BASES, CIRCUITING, AND WIRING TO SUPPORT BREAKLINES AND THREE CHANNEL CHASE EFFECT.
4. PROVIDE HANGING RIGGING FOR MCCARTER
5. [4x] LENGTHS OF 19'-2" AC CABLE NEEDED FOR RIGGING TO PROPER TRIM HEIGHT
6. PROVIDE 12'-0"x18" JACKS WITH SANDBAG WEIGHTS FOR TOUR
7. RENT ROSEBRAND 16'-0" TALL x 24'-0" IFR METALLIC SILVER RAINCURTAIN

The Princeton Triangle Club
at the McCarter Theatre Presents
PAGEANT PENDING

Book, Music, and Lyrics
TRIANGLE WRITERS
WORKSHOP

Direction Sam Hayes
Choreography Taylor Gordon
Music Direction Pete Mills
Set Design Court Watson
Costume Design Stephanie Echevarria
Lighting Design Alex Slisher & Al Potter
Scenic Draughtsperson Jonas Harrison


FLYING PROSCENIUM

Scale: 1/4" = 1'-0" (PRINTED 18" X 24")


1/8" = 1'-0" (PRINTED 11" X 17")

Draft Date: 10.7.24

Plate No.

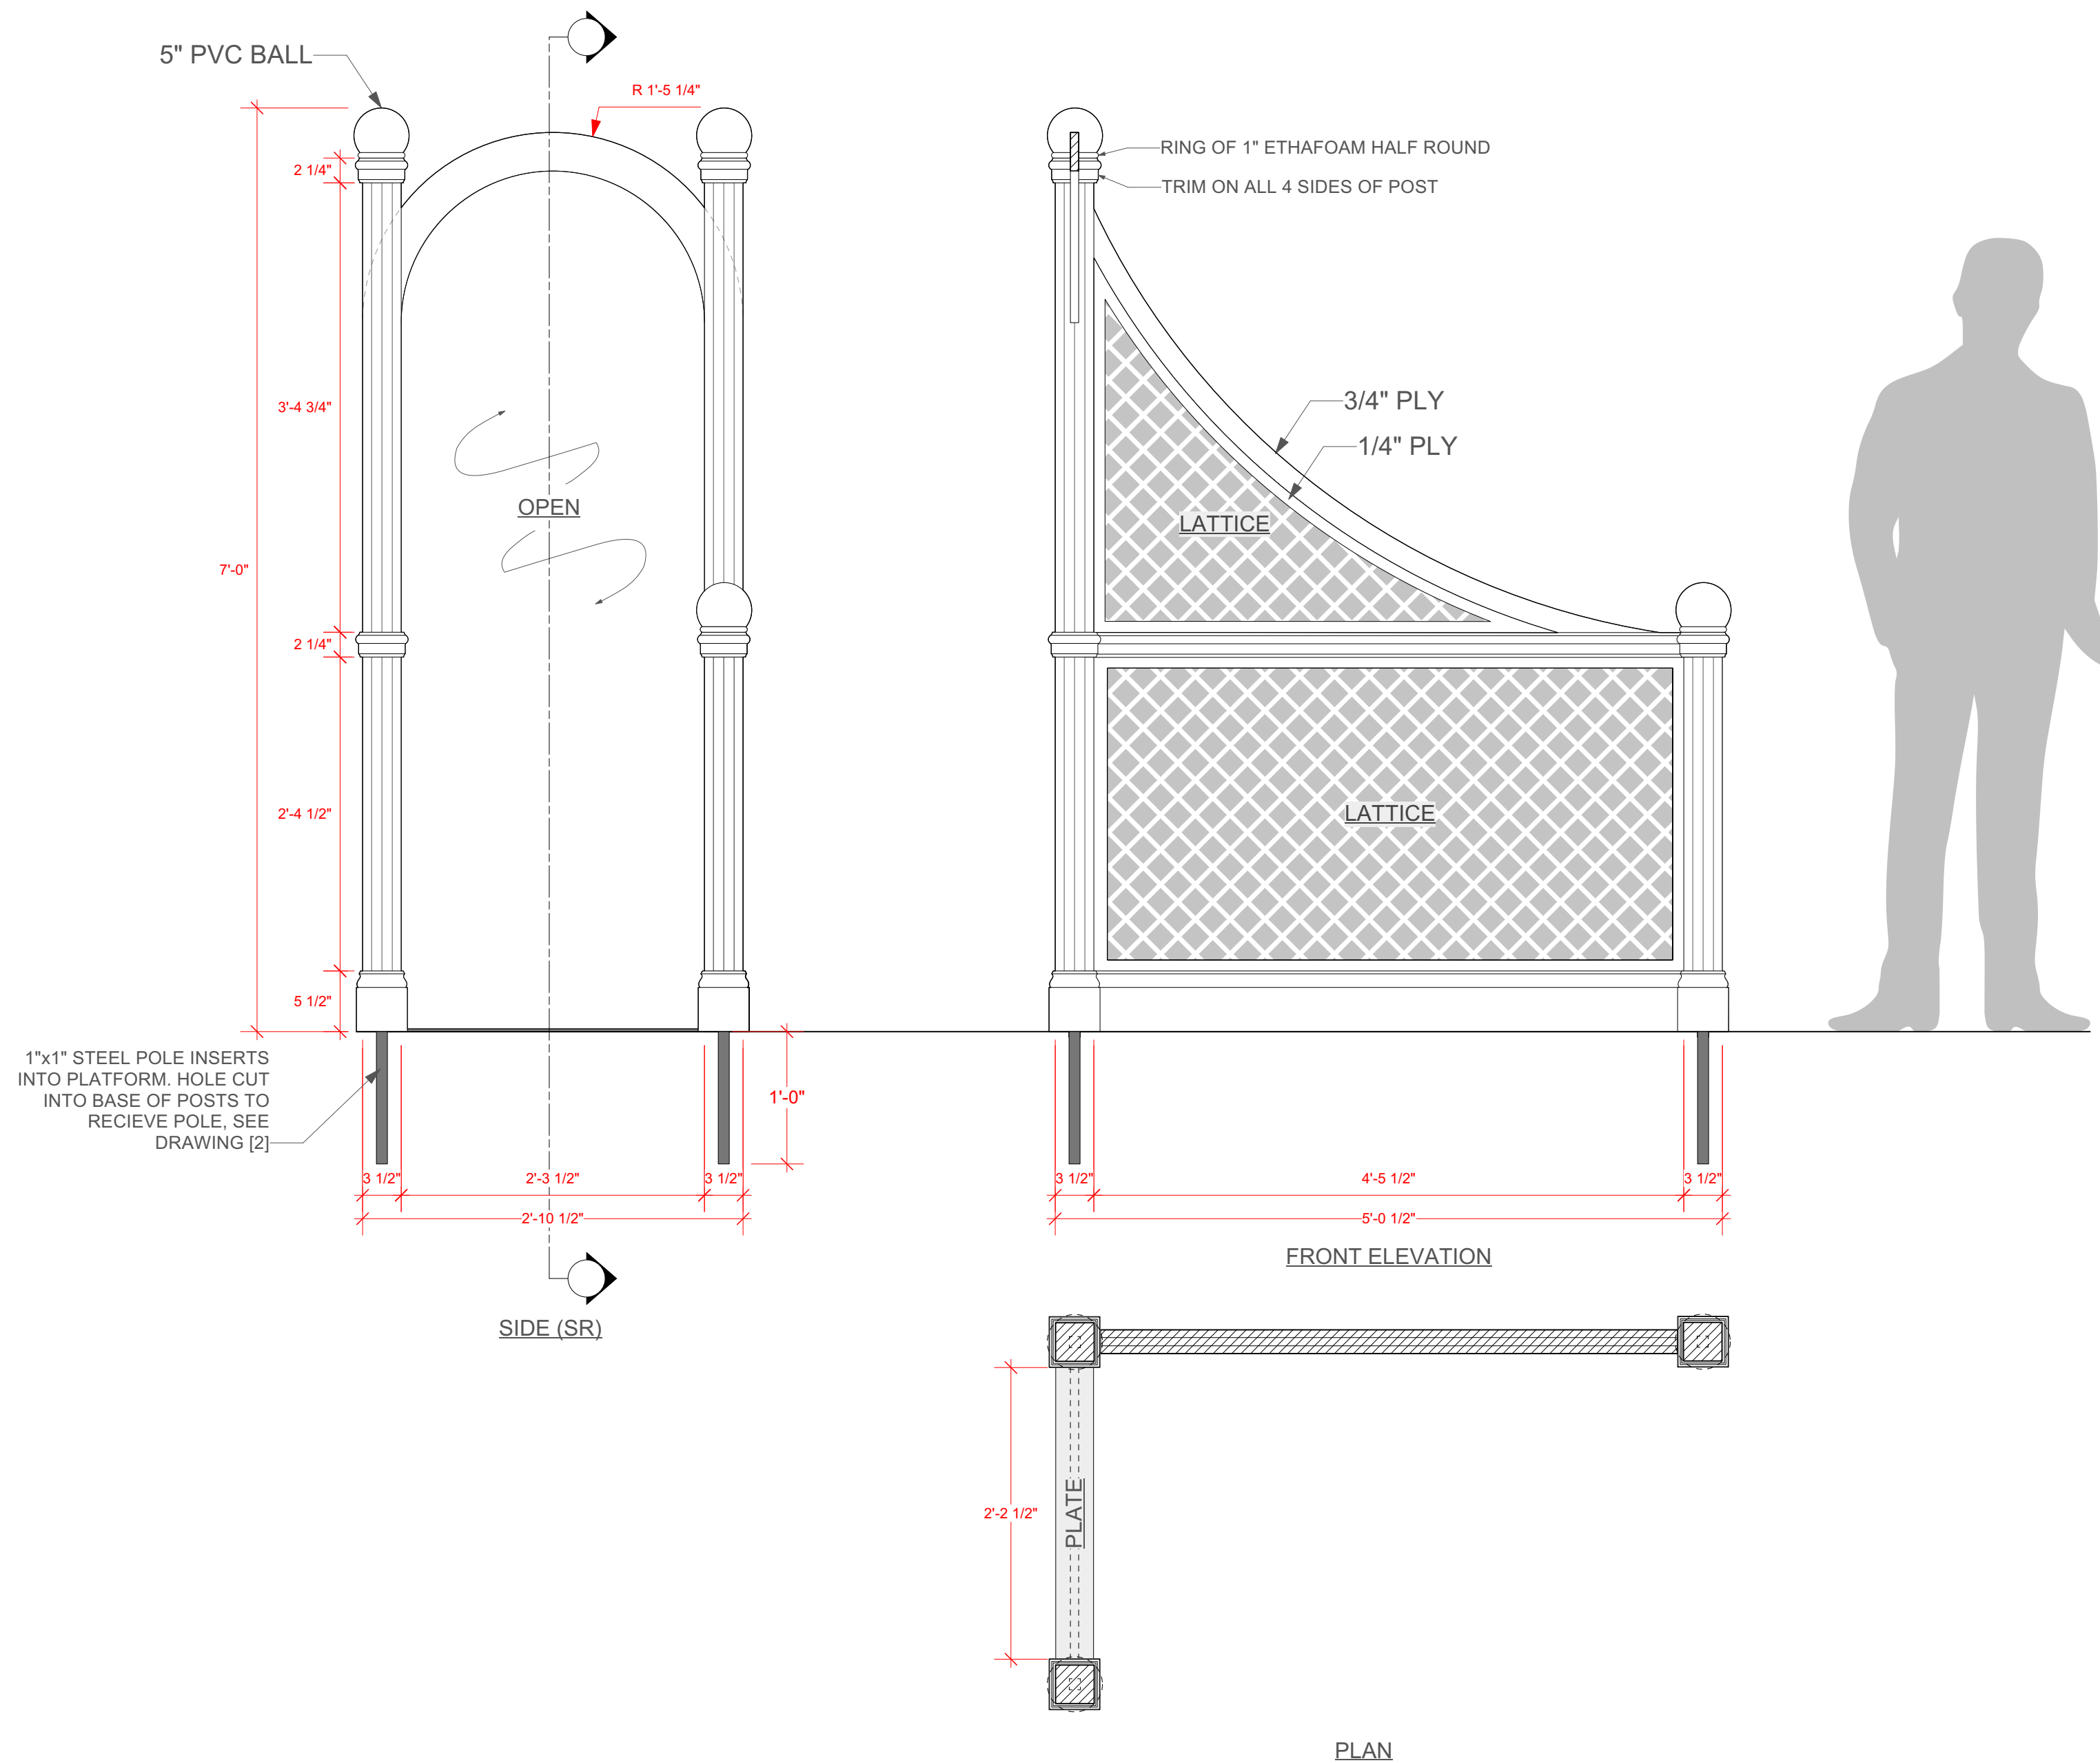

1 SR PAGEANT WALL UNIT ELEVATION
Scale: 1" = 1'-0"

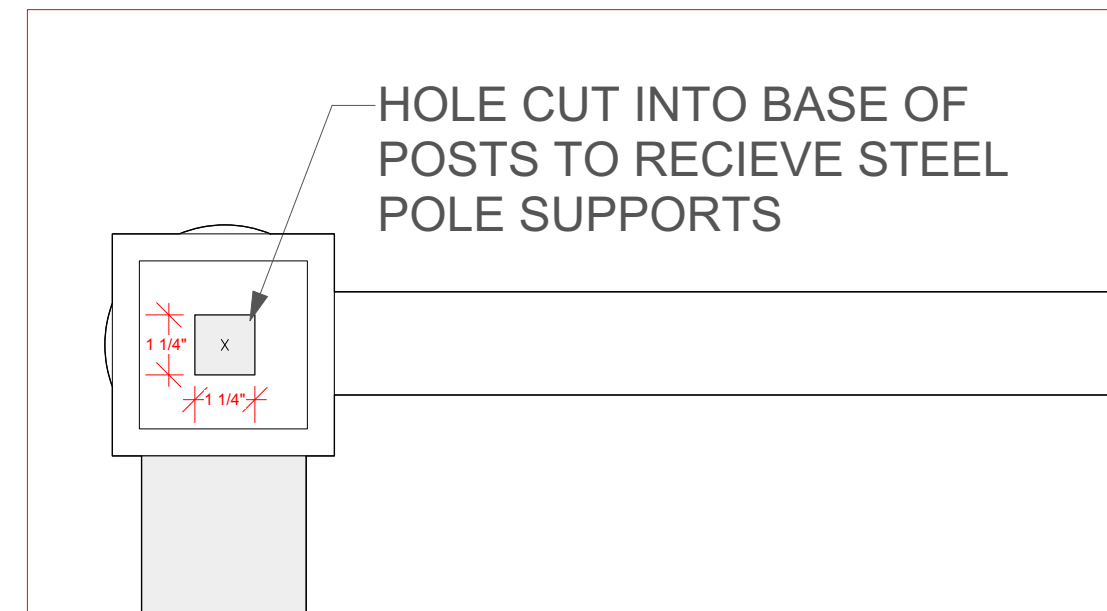

2 POST UNDERSIDE ELEVATION
Scale: 3" = 1'-0"

NOTES:

1. BASEBOARD: HOME DEPOT ALEXANDRIA L 163E7 9/16" x 5 1/4" SKU 1001402972
2. CHAIR RAIL: HOME DEPOT ROYAL 5445 9/16" x 2 1/4" PVC SKU 890789
3. LATTICE: HOME DEPOT VERANDA WHITE VINYL GARDEN DIAMOND
4. LATTICE CAP: BARETTE 3/4" WHITE VINYL
5. BALLS: AMAZON 5" PVC DODGEBALL

The Princeton Triangle Club
at the McCarter Theatre Presents
PAGEANT PENDING

Book, Music, and Lyrics
TRIANGLE WRITERS
WORKSHOP

Direction Sam Hayes
Choreography Taylor Gordon
Music Direction Pete Mills
Set Design Court Watson
Costume Design Stephanie Echevarria
Lighting Design Alex Slisher & Al Potter
Scenic Draughtsperson Jonas Harrison

SR WALL UNIT

Scale: 1" = 1'-0" (PRINTED 18" X 24")



1/2" = 1'-0" (PRINTED 11" X 17")

Draft Date: 10.7.24


Plate No.

12

of [12]

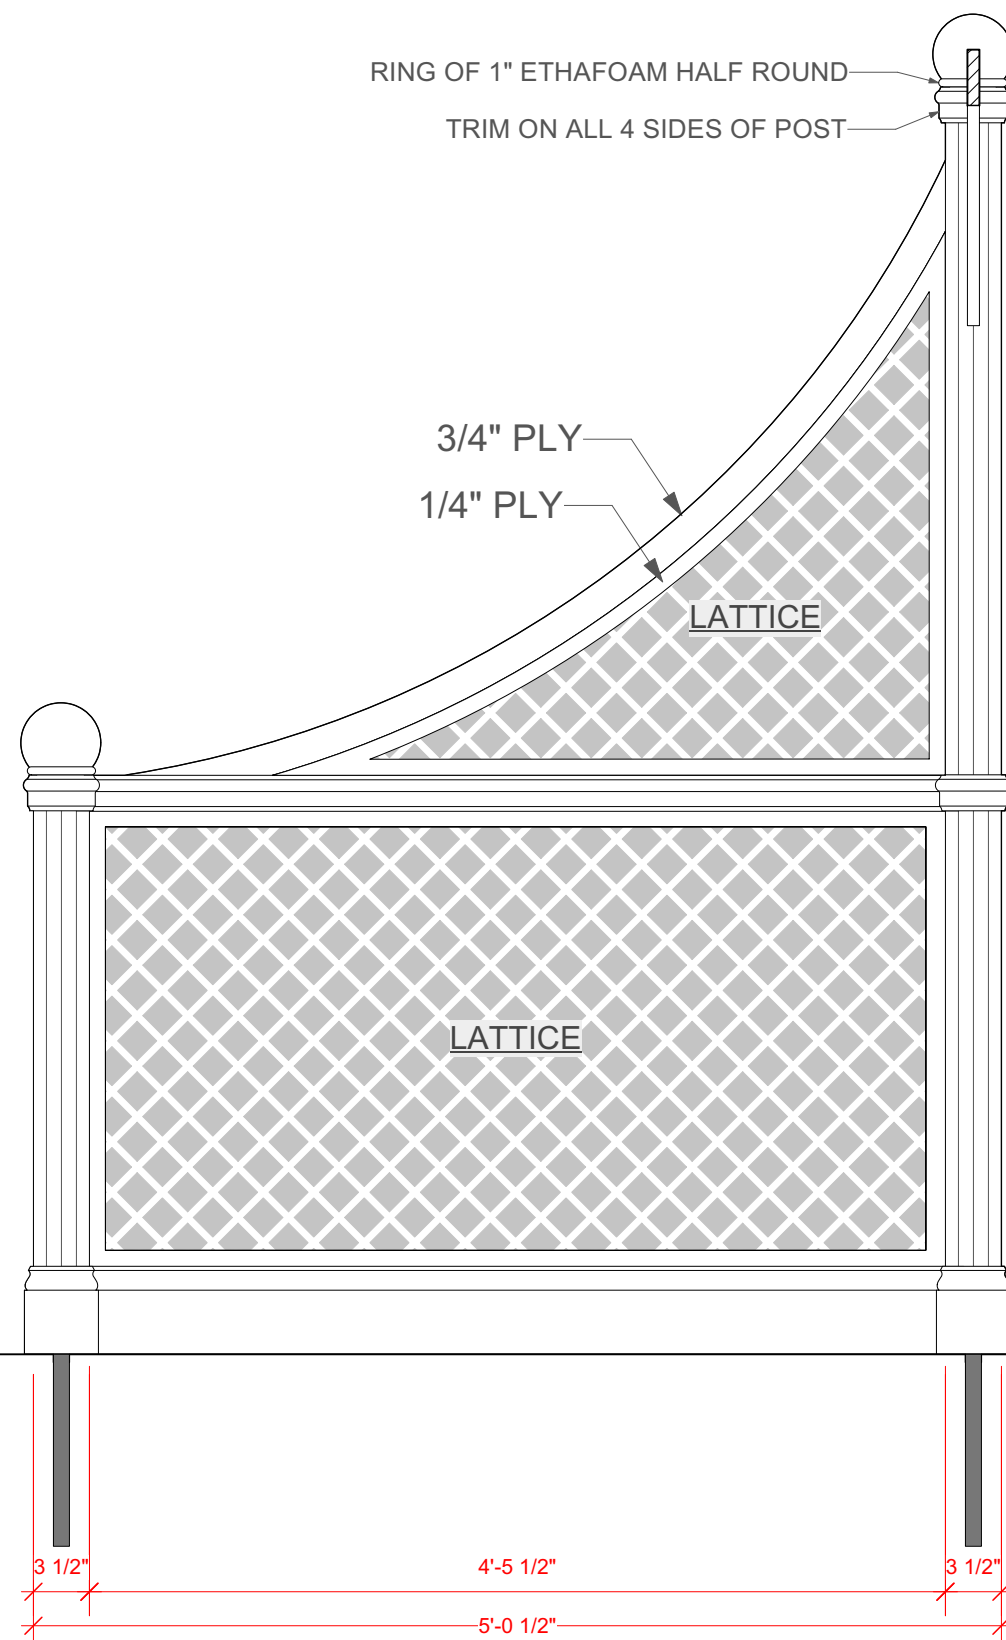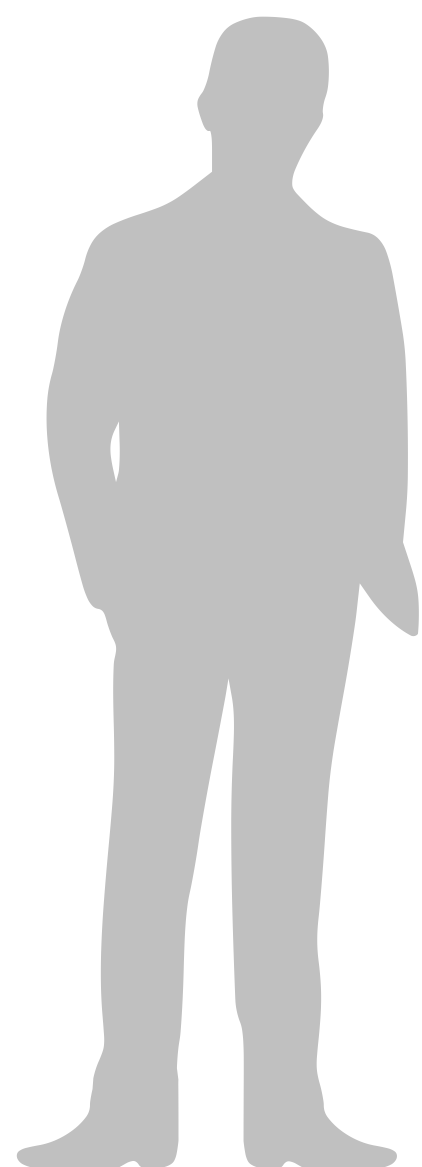

FRONT ELEVATION

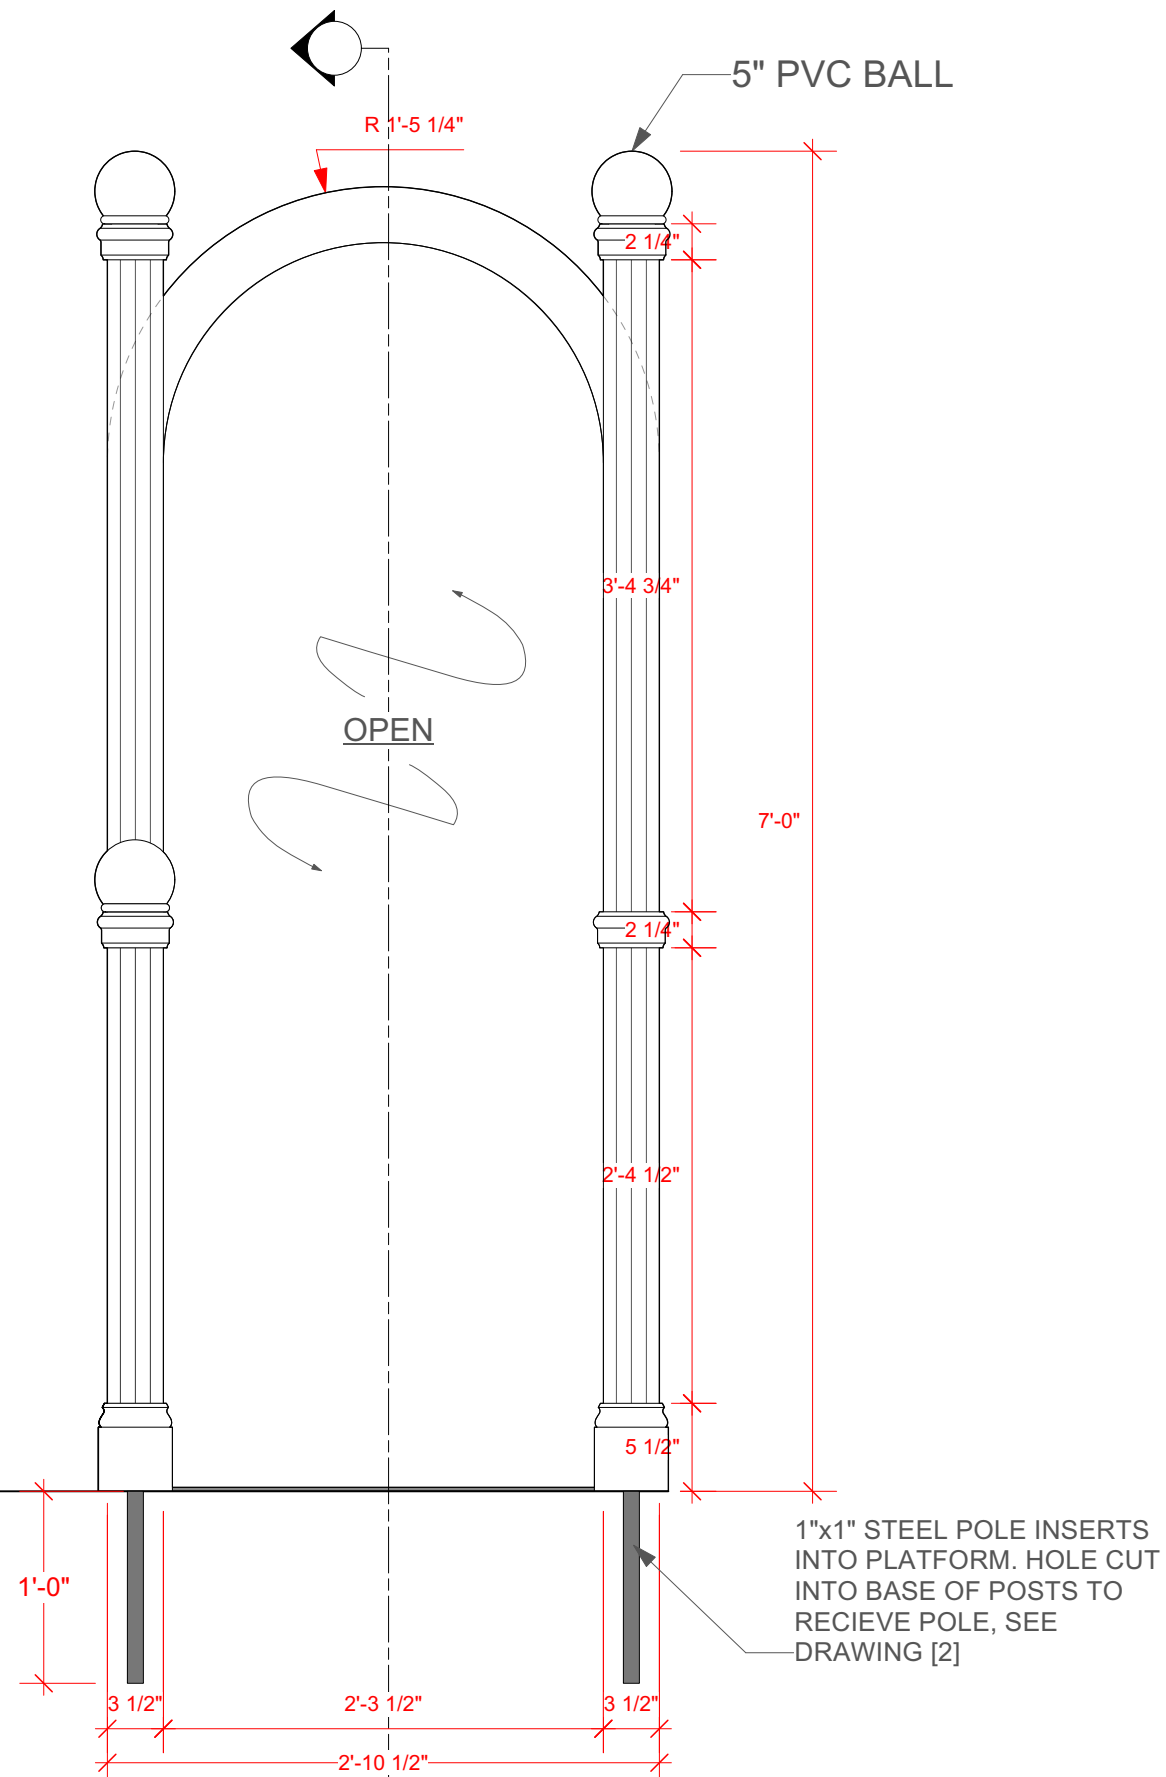


SIDE (SR)



PLAN

1 SL PAGEANT WALL UNIT ELEVATION
Scale: 1" = 1'-0"

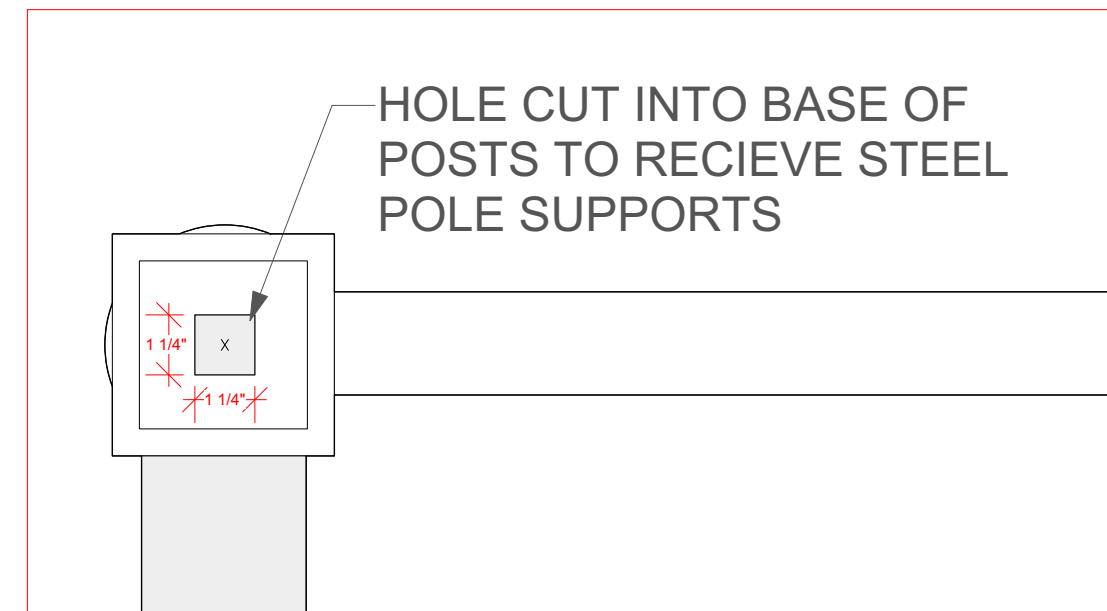

2 POST UNDERSIDE ELEVATION
Scale: 3" = 1'-0"

NOTES:

1. BASEBOARD: HOME DEPOT ALEXANDRIA L 163E7 9/16" x 5 1/4" SKU 1001402972
2. CHAIR RAIL: HOME DEPOT ROYAL 5445 9/16" x 2 1/4" PVC SKU 890789
3. LATTICE: HOME DEPOT VERANDA WHITE VINYL GARDEN DIAMOND
4. LATTICE CAP: BARETTE 3/4" WHITE VINYL
5. BALLS: AMAZON 5" PVC DODGEBALL

The Princeton Triangle Club
at the McCarter Theatre Presents
PAGEANT PENDING

Book, Music, and Lyrics
TRIANGLE WRITERS
WORKSHOP

Direction Sam Hayes
Choreography Taylor Gordon
Music Direction Pete Mills
Set Design Court Watson
Costume Design Stephanie Echevarria
Lighting Design Alex Slisher & Al Potter
Scenic Draughtsperson Jonas Harrison

SL WALL UNIT
Scale: 1" = 1'-0" (PRINTED 18" X 24")
1/2" = 1'-0" (PRINTED 11" X 17")
Draft Date: 10.7.24
Plate No.

13

of [13]